

CONTRACT PLANS COMPONENTS

LIGHTING PLANS

INDEX OF LIGHTING PLANS

SHEET NO.	SHEET DESCRIPTION
L-1	KEY SHEET
L-2 - L-7	TABULATION OF QUANTITIES
L-8	SYMBOLS AND LEGEND
L-9 - L-48	PEDESTRIAN LIGHTING-CONDUIT PLANS



STATE OF FLORIDA  
DEPARTMENT OF TRANSPORTATION

CONTRACT PLANS


FINANCIAL PROJECT ID 436319-1-52-03  
(FEDERAL FUNDS)  
BROWARD COUNTY (86000)

LYONS ROAD FROM C-14 CANAL TO SAWGRASS EXPRESSWAY

LIGHTING PLANS

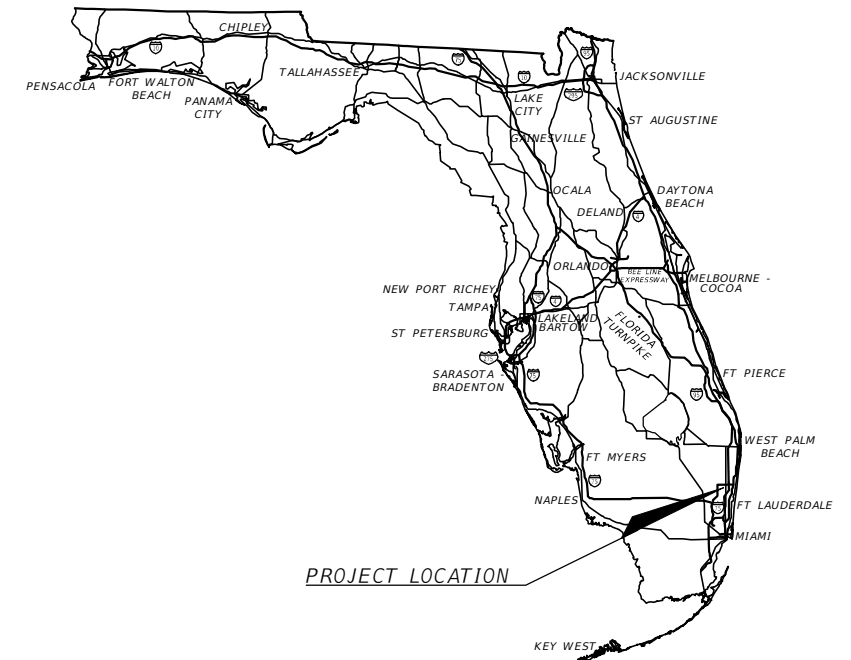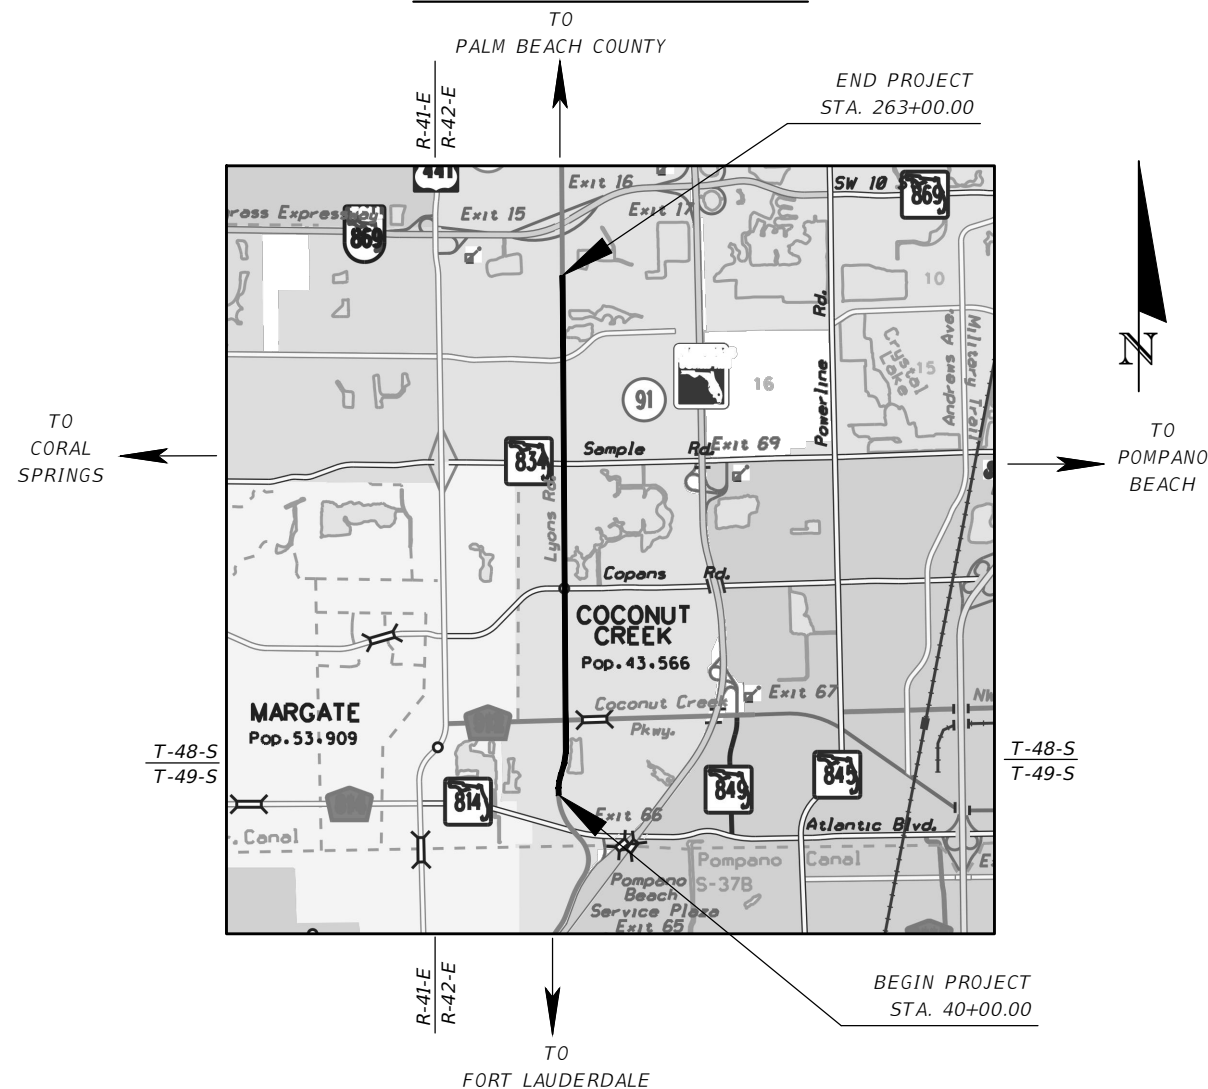

THIS PROJECT TO BE LET TO CONTRACT WITH FINANCIAL PROJECT IDS: 436319-1-52-01, 436319-1-52-02, AND 436319-1-52-04

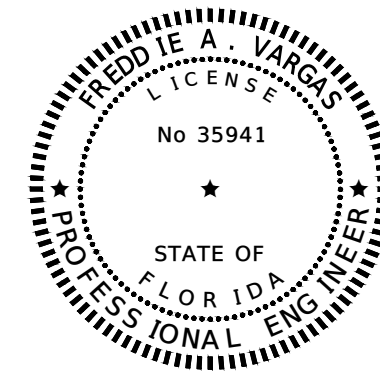

THIS ITEM HAS BEEN DIGITALLY SIGNED AND SEALED BY:

ON THE DATE ADJACENT TO THE SEAL PRINTED COPIES OF THIS DOCUMENT ARE NOT CONSIDERED SIGNED AND SEALED. THE SIGNATURE MUST BE VERIFIED IN THE ELECTRONIC DOCUMENTS.

FREDDIE A. VARGAS, P.E.  
P.E. LICENSE NO. 35941  
CARNAHAN PROCTOR & CROSS, INC.  
814 S. MILITARY TRAIL  
DEERFIELD BEACH, FL 33442

LIGHTING PLANS  
ENGINEER OF RECORD:

FREDDIE A. VARGAS, P.E.  
P.E. NO.: 35941  
CARNAHAN PROCTOR & CROSS, INC.  
814 S. MILITARY TRAIL  
DEERFIELD BEACH, FL 33442  
TEL. NO.: 954-972-3959  
CONTRACT NO.: 181201  
VENDOR NO.: 107801  
CERTIFICATE OF AUTHORIZATION NO.: 2936

FDOT PROJECT MANAGER:  
BRAD SALISBURY, P.E.

CONSTRUCTION CONTRACT NO.	FISCAL YEAR	SHEET NO.
T4522	20	L-1

GOVERNING STANDARD PLANS:  
Florida Department of Transportation, FY2019-20 Standard plans for Road and Bridge Construction and applicable Interim Revisions (Irs).

Standard Plans for Road Construction and associated Irs are available at the following website:  
<http://www.fdot.gov/design/Standardplans.shtm>

GOVERNING STANDARD SPECIFICATIONS:  
Florida Department of Transportation, JULY 2019 Standard Specifications for Road and Bridge Construction at the following website:

<http://www.fdot.gov/programmanagement/Implemented/SpecBooks>

**TABULATION OF QUANTITIES**

PAY ITEM NO.	DESCRIPTION	UNIT	SHEET NUMBERS														TOTAL THIS SHEET		GRAND TOTAL	
			L- 9		L- 10		L- 11		L- 12		L- 13		L- 14		L- 15		PLAN	FINAL	PLAN	FINAL
			PLAN	FINAL	PLAN	FINAL	PLAN	FINAL	PLAN	FINAL	PLAN	FINAL	PLAN	FINAL	PLAN	FINAL				
630 2 11	CONDUIT, FURNISH & INSTALL, OPEN TRENCH	LF	361.00		574.00		387.00				422.00		222.00		249.00		2215.00			
630 2 12	CONDUIT, FURNISH & INSTALL, DIRECTIONAL BORE	LF					197.00		575.00		126.00		359.00		332.00		1589.00			
635 2 11	PULL & SPLICE BOX, F&I, 13" x 24" COVER SIZE	EA	3.00		4.00		4.00		4.00		4.00		6.00		5.00		30.00			

THE OFFICIAL RECORD OF THIS SHEET IS THE ELECTRONIC FILE DIGITALLY SIGNED AND SEALED UNDER RULE 61C15-23.004, F.A.C.

<i>REVISIONS</i>				FREDDIE A. VARGAS, P.E. P.E. LICENSE NUMBER 35941 CARNAHAN PROCTOR & CROSS, INC. 814 S. MILITARY TRAIL DEERFIELD BEACH, FL 33442 CERTIFICATE OF AUTHORIZATION 2936	STATE OF FLORIDA DEPARTMENT OF TRANSPORTATION			<i>TABULATION OF QUANTITIES</i>	SHEET NO.
DATE	DESCRIPTION	DATE	DESCRIPTION		ROAD NO.	COUNTY	FINANCIAL PROJECT ID		L-2
----	----	----	----			BROWARD	436319-1-52-03		

**TABULATION OF QUANTITIES**

PAY ITEM NO.	DESCRIPTION	UNIT	SHEET NUMBERS														TOTAL THIS SHEET		GRAND TOTAL			
			L- 16		L- 17		L- 18		L- 19		L- 20		L- 21		L- 22		PLAN	FINAL	PLAN	FINAL		
			PLAN	FINAL	PLAN	FINAL	PLAN	FINAL	PLAN	FINAL	PLAN	FINAL	PLAN	FINAL	PLAN	FINAL						
630 2 11	CONDUIT, FURNISH & INSTALL, OPEN TRENCH	LF	319.00		145.00							451.00		488.00		570.00		1973.00				
630 2 12	CONDUIT, FURNISH & INSTALL, DIRECTIONAL BORE	LF	248.00		416.00		580.00		595.00		119.00		84.00					2042.00				
635 2 11	PULL & SPLICE BOX, F&I, 13" x 24" COVER SIZE	EA	4.00		4.00		4.00		3.00		3.00		5.00		4.00			27.00				

--	--	--	--	--	--	--	--	--	--	--	--	--	--	--	--	--	--	--	--	--	--	--

THE OFFICIAL RECORD OF THIS SHEET IS THE ELECTRONIC FILE DIGITALLY SIGNED AND SEALED UNDER RULE 61C15-23.004, F.A.C.

<b>REVISIONS</b>				FREDDIE A. VARGAS, P.E. P.E. LICENSE NUMBER 35941 CARNAHAN PROCTOR & CROSS, INC. 814 S. MILITARY TRAIL DEERFIELD BEACH, FL 33442 CERTIFICATE OF AUTHORIZATION 2936	STATE OF FLORIDA DEPARTMENT OF TRANSPORTATION			TABULATION OF QUANTITIES	SHEET NO.
DATE	DESCRIPTION	DATE	DESCRIPTION		ROAD NO.	COUNTY	FINANCIAL PROJECT ID		L-3
----	----	----	----			BROWARD	436319-1-52-03		

TABULATION OF QUANTITIES

PAY ITEM NO.	DESCRIPTION	UNIT	SHEET NUMBERS														TOTAL THIS SHEET		GRAND TOTAL	
			L- 23		L- 24		L- 25		L- 26		L- 27		L- 28		L- 29					
			PLAN	FINAL	PLAN	FINAL	PLAN	FINAL	PLAN	FINAL	PLAN	FINAL	PLAN	FINAL	PLAN	FINAL	PLAN	FINAL	PLAN	FINAL
630 2 11	CONDUIT, FURNISH & INSTALL, OPEN TRENCH	LF	427.00		403.00		410.00		407.00		570.00		420.00		484.00		3121.00			
630 2 12	CONDUIT, FURNISH & INSTALL, DIRECTIONAL BORE	LF	133.00		167.00		165.00		164.00				140.00		86.00		855.00			
635 2 11	PULL & SPLICE BOX, F&I, 13" x 24" COVER SIZE	EA	3.00		6.00		4.00		4.00		4.00		4.00		5.00		30.00			

THE OFFICIAL RECORD OF THIS SHEET IS THE ELECTRONIC FILE DIGITALLY SIGNED AND SEALED UNDER RULE 61C15-23.004, F.A.C.

REVISIONS				FREDDIE A. VARGAS, P.E. P.E. LICENSE NUMBER 35941 CARNAHAN PROCTOR & CROSS, INC. 814 S. MILITARY TRAIL DEERFIELD BEACH, FL 33442 CERTIFICATE OF AUTHORIZATION 2936	STATE OF FLORIDA DEPARTMENT OF TRANSPORTATION			<i>TABULATION OF QUANTITIES</i>	SHEET NO.
DATE	DESCRIPTION	DATE	DESCRIPTION		ROAD NO.	COUNTY	FINANCIAL PROJECT ID		L-4
----	----	----	----			BROWARD	436319-1-52-03		

TABULATION OF QUANTITIES

PAY ITEM NO.	DESCRIPTION	UNIT	SHEET NUMBERS														TOTAL THIS SHEET		GRAND TOTAL	
			L- 30		L- 31		L- 32		L- 33		L- 34		L- 35		L- 36					
			PLAN	FINAL	PLAN	FINAL	PLAN	FINAL	PLAN	FINAL	PLAN	FINAL	PLAN	FINAL	PLAN	FINAL	PLAN	FINAL	PLAN	FINAL
630 2 11	CONDUIT, FURNISH & INSTALL, OPEN TRENCH	LF	500.00	460.00	580.00	304.00	288.00	474.00	270.00	2876.00										
630 2 12	CONDUIT, FURNISH & INSTALL, DIRECTIONAL BORE	LF	70.00	121.00		259.00	297.00	86.00	300.00	1133.00										
635 2 11	PULL & SPLICE BOX, F&I, 13" x 24" COVER SIZE	EA	4.00	6.00	4.00	3.00	3.00	5.00	4.00	29.00										

THE OFFICIAL RECORD OF THIS SHEET IS THE ELECTRONIC FILE DIGITALLY SIGNED AND SEALED UNDER RULE 61C15-23.004, F.A.C.

REVISIONS				FREDDIE A. VARGAS, P.E. P.E. LICENSE NUMBER 35941 CARNAHAN PROCTOR & CROSS, INC. 814 S. MILITARY TRAIL DEERFIELD BEACH, FL 33442 CERTIFICATE OF AUTHORIZATION 2936	STATE OF FLORIDA DEPARTMENT OF TRANSPORTATION			<i>TABULATION OF QUANTITIES</i>	SHEET NO.
DATE	DESCRIPTION	DATE	DESCRIPTION		ROAD NO.	COUNTY	FINANCIAL PROJECT ID		L-5
----	----	----				BROWARD	436319-1-52-03		

**TABULATION OF QUANTITIES**

PAY ITEM NO.	DESCRIPTION	UNIT	SHEET NUMBERS														TOTAL THIS SHEET		GRAND TOTAL	
			L- 37		L- 38		L- 39		L- 40		L- 41		L- 42		L- 43		PLAN	FINAL	PLAN	FINAL
			PLAN	FINAL	PLAN	FINAL	PLAN	FINAL	PLAN	FINAL	PLAN	FINAL	PLAN	FINAL	PLAN	FINAL				
630 2 11	CONDUIT, FURNISH & INSTALL, OPEN TRENCH	LF	290.00				396.00										686.00			
630 2 12	CONDUIT, FURNISH & INSTALL, DIRECTIONAL BORE	LF	280.00		560.00		187.00		561.00		571.00		580.00		570.00		3309.00			
635 2 11	PULL & SPLICE BOX, F&I, 13" x 24" COVER SIZE	EA	3.00		3.00		4.00		5.00		4.00		3.00		4.00		26.00			

THE OFFICIAL RECORD OF THIS SHEET IS THE ELECTRONIC FILE DIGITALLY SIGNED AND SEALED UNDER RULE 61C15-23.004, F.A.C.

REVISIONS				FREDDIE A. VARGAS, P.E. P.E. LICENSE NUMBER 35941 CARNAHAN PROCTOR & CROSS, INC. 814 S. MILITARY TRAIL DEERFIELD BEACH, FL 33442 CERTIFICATE OF AUTHORIZATION 2936	STATE OF FLORIDA DEPARTMENT OF TRANSPORTATION			<i>TABULATION OF QUANTITIES</i>	SHEET NO.
DATE	DESCRIPTION	DATE	DESCRIPTION		ROAD NO.	COUNTY	FINANCIAL PROJECT ID		L-6
----	-----					BROWARD	436319-1-52-03		

TABULATION OF QUANTITIES

PAY ITEM NO.	DESCRIPTION	UNIT	SHEET NUMBERS														TOTAL THIS SHEET		GRAND TOTAL	
			L- 44		L- 45		L- 46		L- 47		L- 48									
			PLAN	FINAL	PLAN	FINAL	PLAN	FINAL	PLAN	FINAL	PLAN	FINAL	PLAN	FINAL	PLAN	FINAL	PLAN	FINAL	PLAN	FINAL
630 2 11	CONDUIT, FURNISH & INSTALL, OPEN TRENCH	LF	154.00	456.00													610.00	11481.00		
630 2 12	CONDUIT, FURNISH & INSTALL, DIRECTIONAL BORE	LF	416.00	105.00	570.00		570.00			330.00							1991.00	10919.00		
635 2 11	PULL & SPLICE BOX, F&I, 13" x 24" COVER SIZE	EA	5.00	4.00	4.00		3.00			3.00							19.00	161.00		

<p align="center">REVISIONS</p> <table border="1"> <thead> <tr> <th>DATE</th> <th>DESCRIPTION</th> <th>DATE</th> <th>DESCRIPTION</th> </tr> </thead> <tbody> <tr> <td>----</td> <td>----</td> <td>----</td> <td>----</td> </tr> </tbody> </table>				DATE	DESCRIPTION	DATE	DESCRIPTION	----	----	----	----	<p>FREDDIE A. VARGAS, P.E.          P.E. LICENSE NUMBER 35941          CARNAHAN PROCTOR &amp; CROSS, INC.          814 S. MILITARY TRAIL          DEERFIELD BEACH, FL 33442          CERTIFICATE OF AUTHORIZATION 2936</p>	<p align="center">STATE OF FLORIDA          DEPARTMENT OF TRANSPORTATION</p> <table border="1"> <tr> <td>ROAD NO.</td> <td>COUNTY</td> <td>FINANCIAL PROJECT ID</td> </tr> <tr> <td></td> <td align="center">BROWARD</td> <td align="center">436319-1-52-03</td> </tr> </table>	ROAD NO.	COUNTY	FINANCIAL PROJECT ID		BROWARD	436319-1-52-03	<p align="center"><i>TABULATION OF QUANTITIES</i></p>	<p>SHEET NO.</p> <p align="center">L- 7</p>
DATE	DESCRIPTION	DATE	DESCRIPTION																		
----	----	----	----																		
ROAD NO.	COUNTY	FINANCIAL PROJECT ID																			
	BROWARD	436319-1-52-03																			

THE OFFICIAL RECORD OF THIS SHEET IS THE ELECTRONIC FILE DIGITALLY SIGNED AND SEALED UNDER RULE 61C15-23.004, F.A.C.

**SYMBOLS**



**LEGEND DESCRIPTION**

One (1) 2" Schedule 40 PVC conduit



One (1) 2" HDPE conduit (directional bore), unless otherwise noted on plan. Extend conduit beyond edge of pavement to pull boxes.




Pull box

**NOTE:**

The lighting system will be maintained by City of Coconut Creek/ Broward County upon final acceptance.

REVISIONS				FREDDIE A. VARGAS, P.E. P.E. LICENSE NUMBER 35941 CARNAHAN PROCTOR & CROSS, INC. 814 S. MILITARY TRAIL DEERFIELD BEACH, FL 33442 CERTIFICATE OF AUTHORIZATION 2936	STATE OF FLORIDA DEPARTMENT OF TRANSPORTATION			<i>SYMBOLS AND LEGEND</i>	SHEET NO.  L-8
DATE	DESCRIPTION	DATE	DESCRIPTION		ROAD NO.	COUNTY	FINANCIAL PROJECT ID		
---	---					BROWARD	436319-1-52-03		




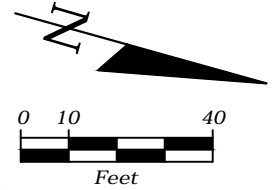

**BEGIN PEDESTRIAN LIGHTING CONDUIT  
STA. 40+00.00**



EXIST. R/W LINE  
PEDESTRIAN LIGHTING CONDUIT

CUT TREES

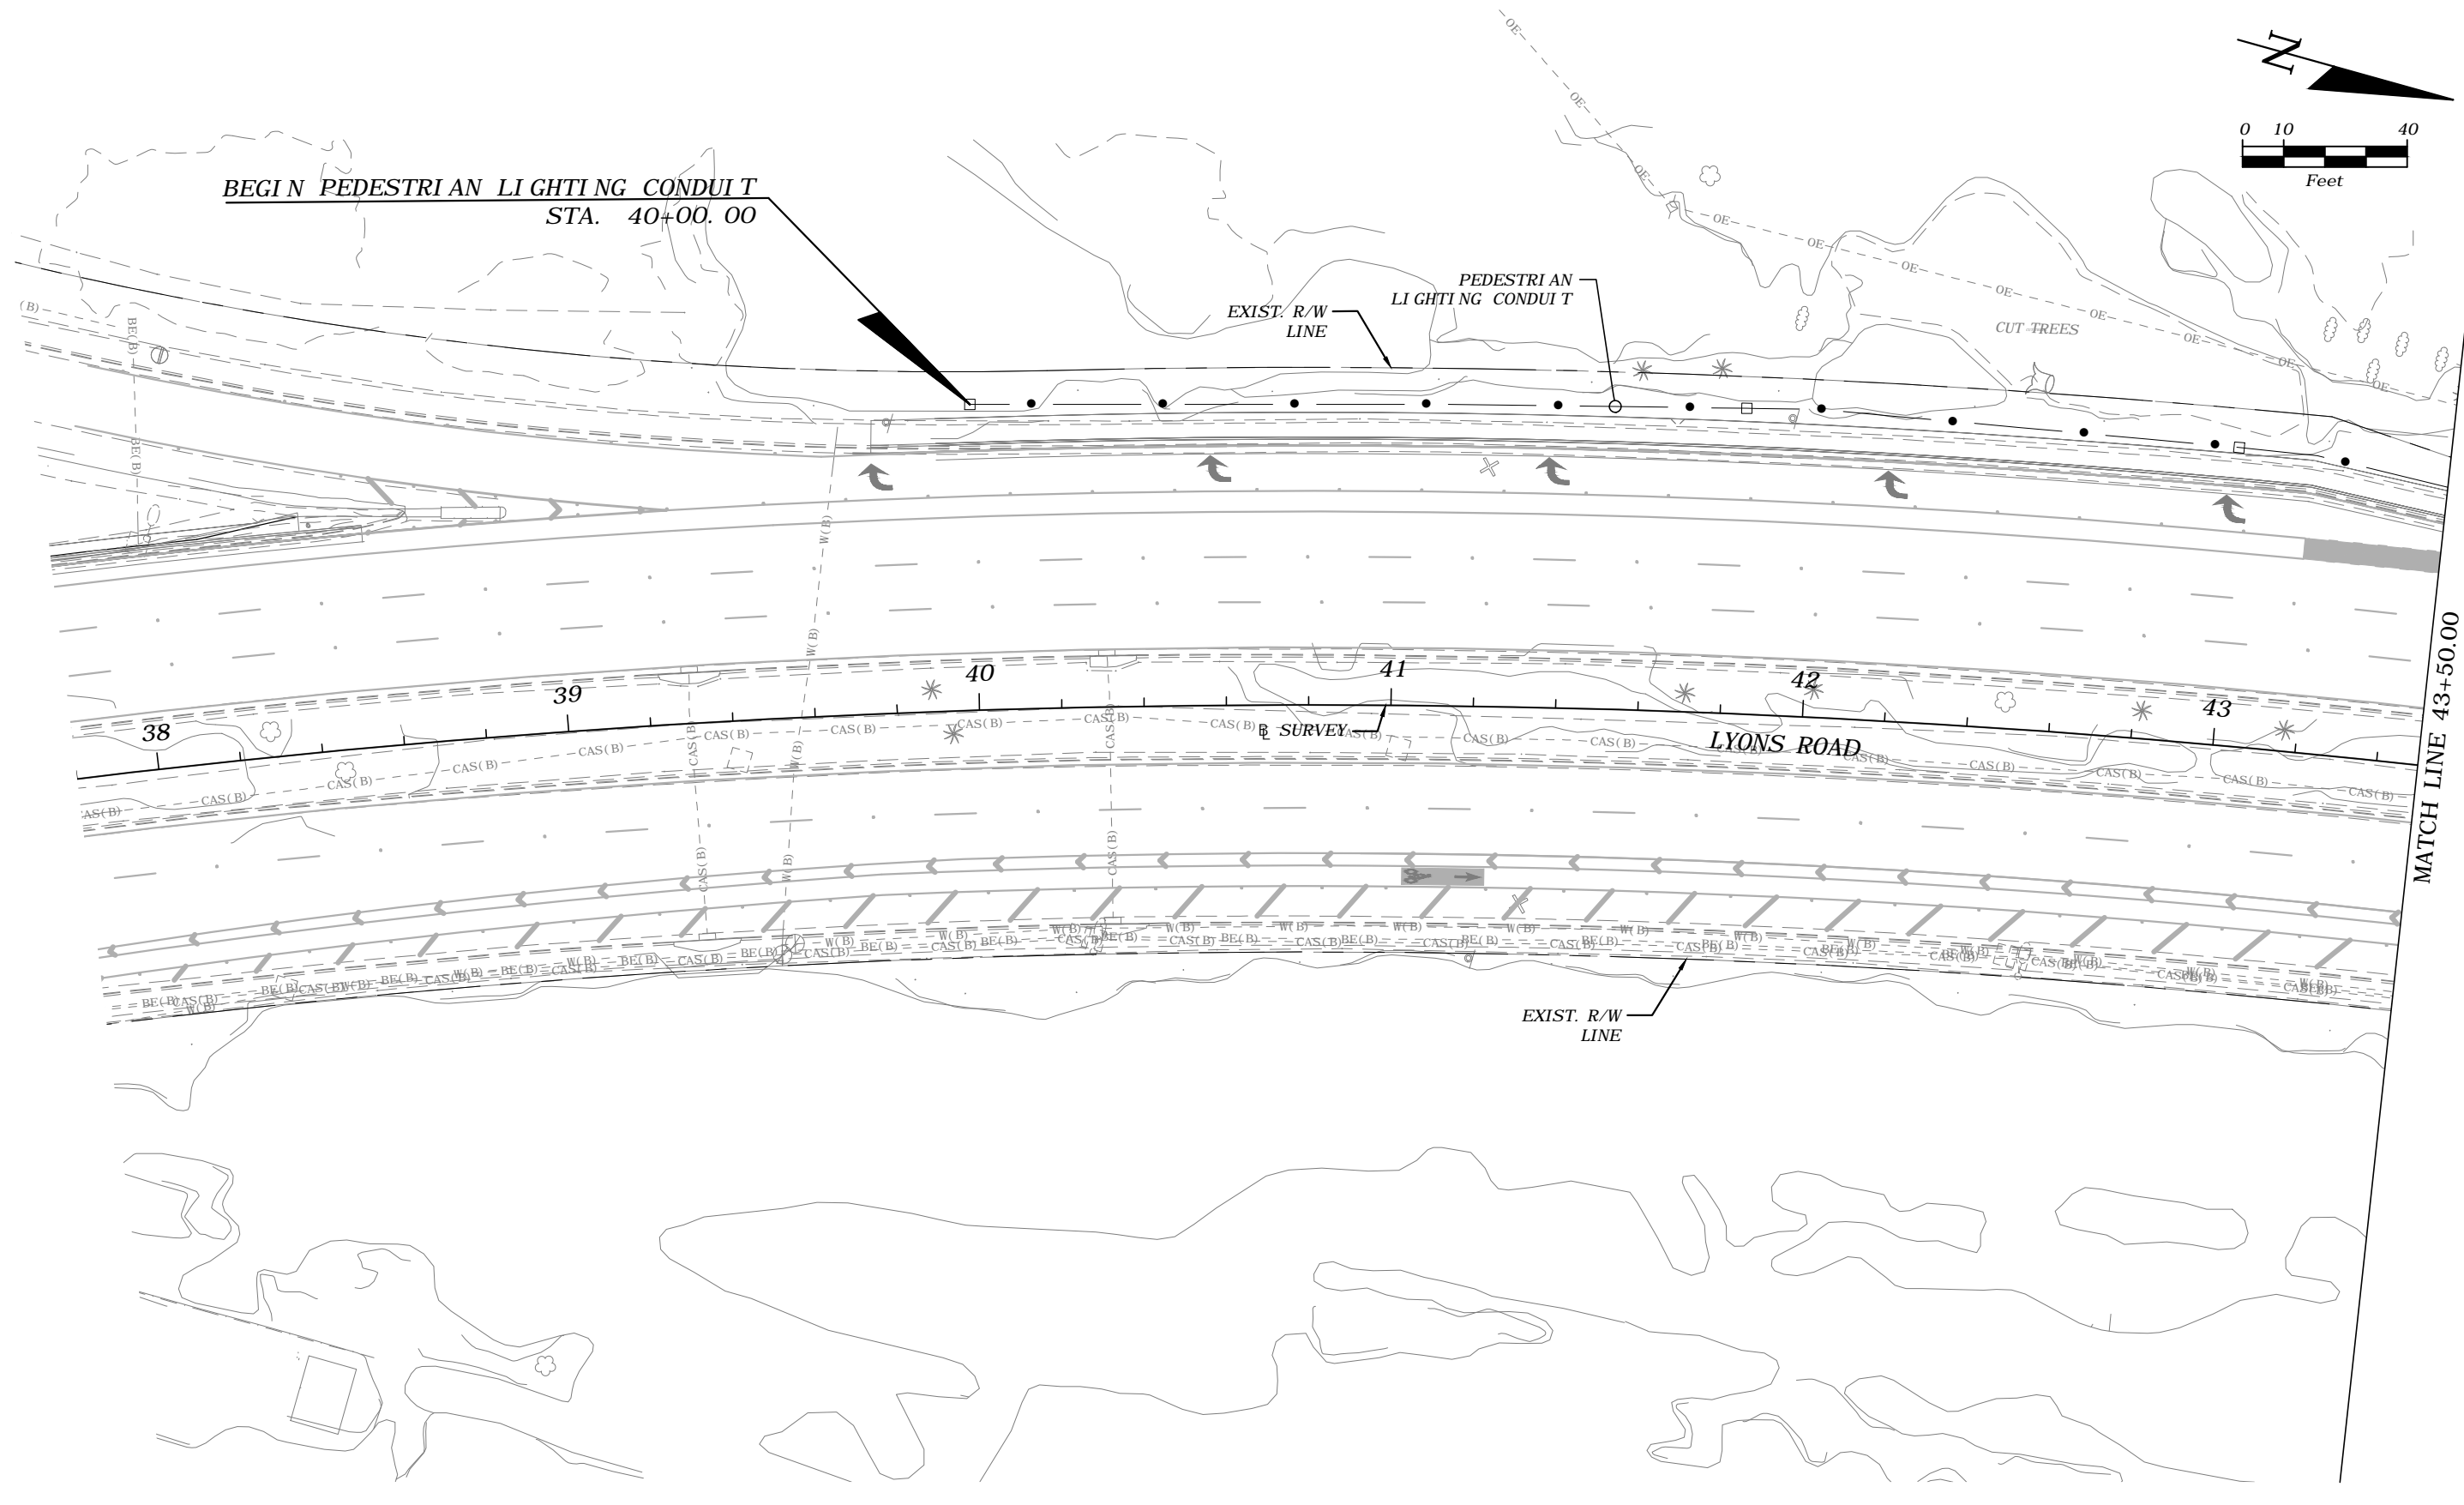

MATCH LINE 43+50.00

REVISIONS				FREDDIE A. VARGAS, P.E. P.E. LICENSE NUMBER 35941 CARNAHAN PROCTOR & CROSS, INC. 814 S. MILITARY TRAIL DEERFIELD BEACH, FL 33442 CERTIFICATE OF AUTHORIZATION 2936	STATE OF FLORIDA DEPARTMENT OF TRANSPORTATION			<i>PEDESTRIAN LIGHTING-CONDUIT PLANS</i>	SHEET NO.
DATE	DESCRIPTION	DATE	DESCRIPTION		ROAD NO.	COUNTY	FINANCIAL PROJECT ID		L-9
---	---	---	---						

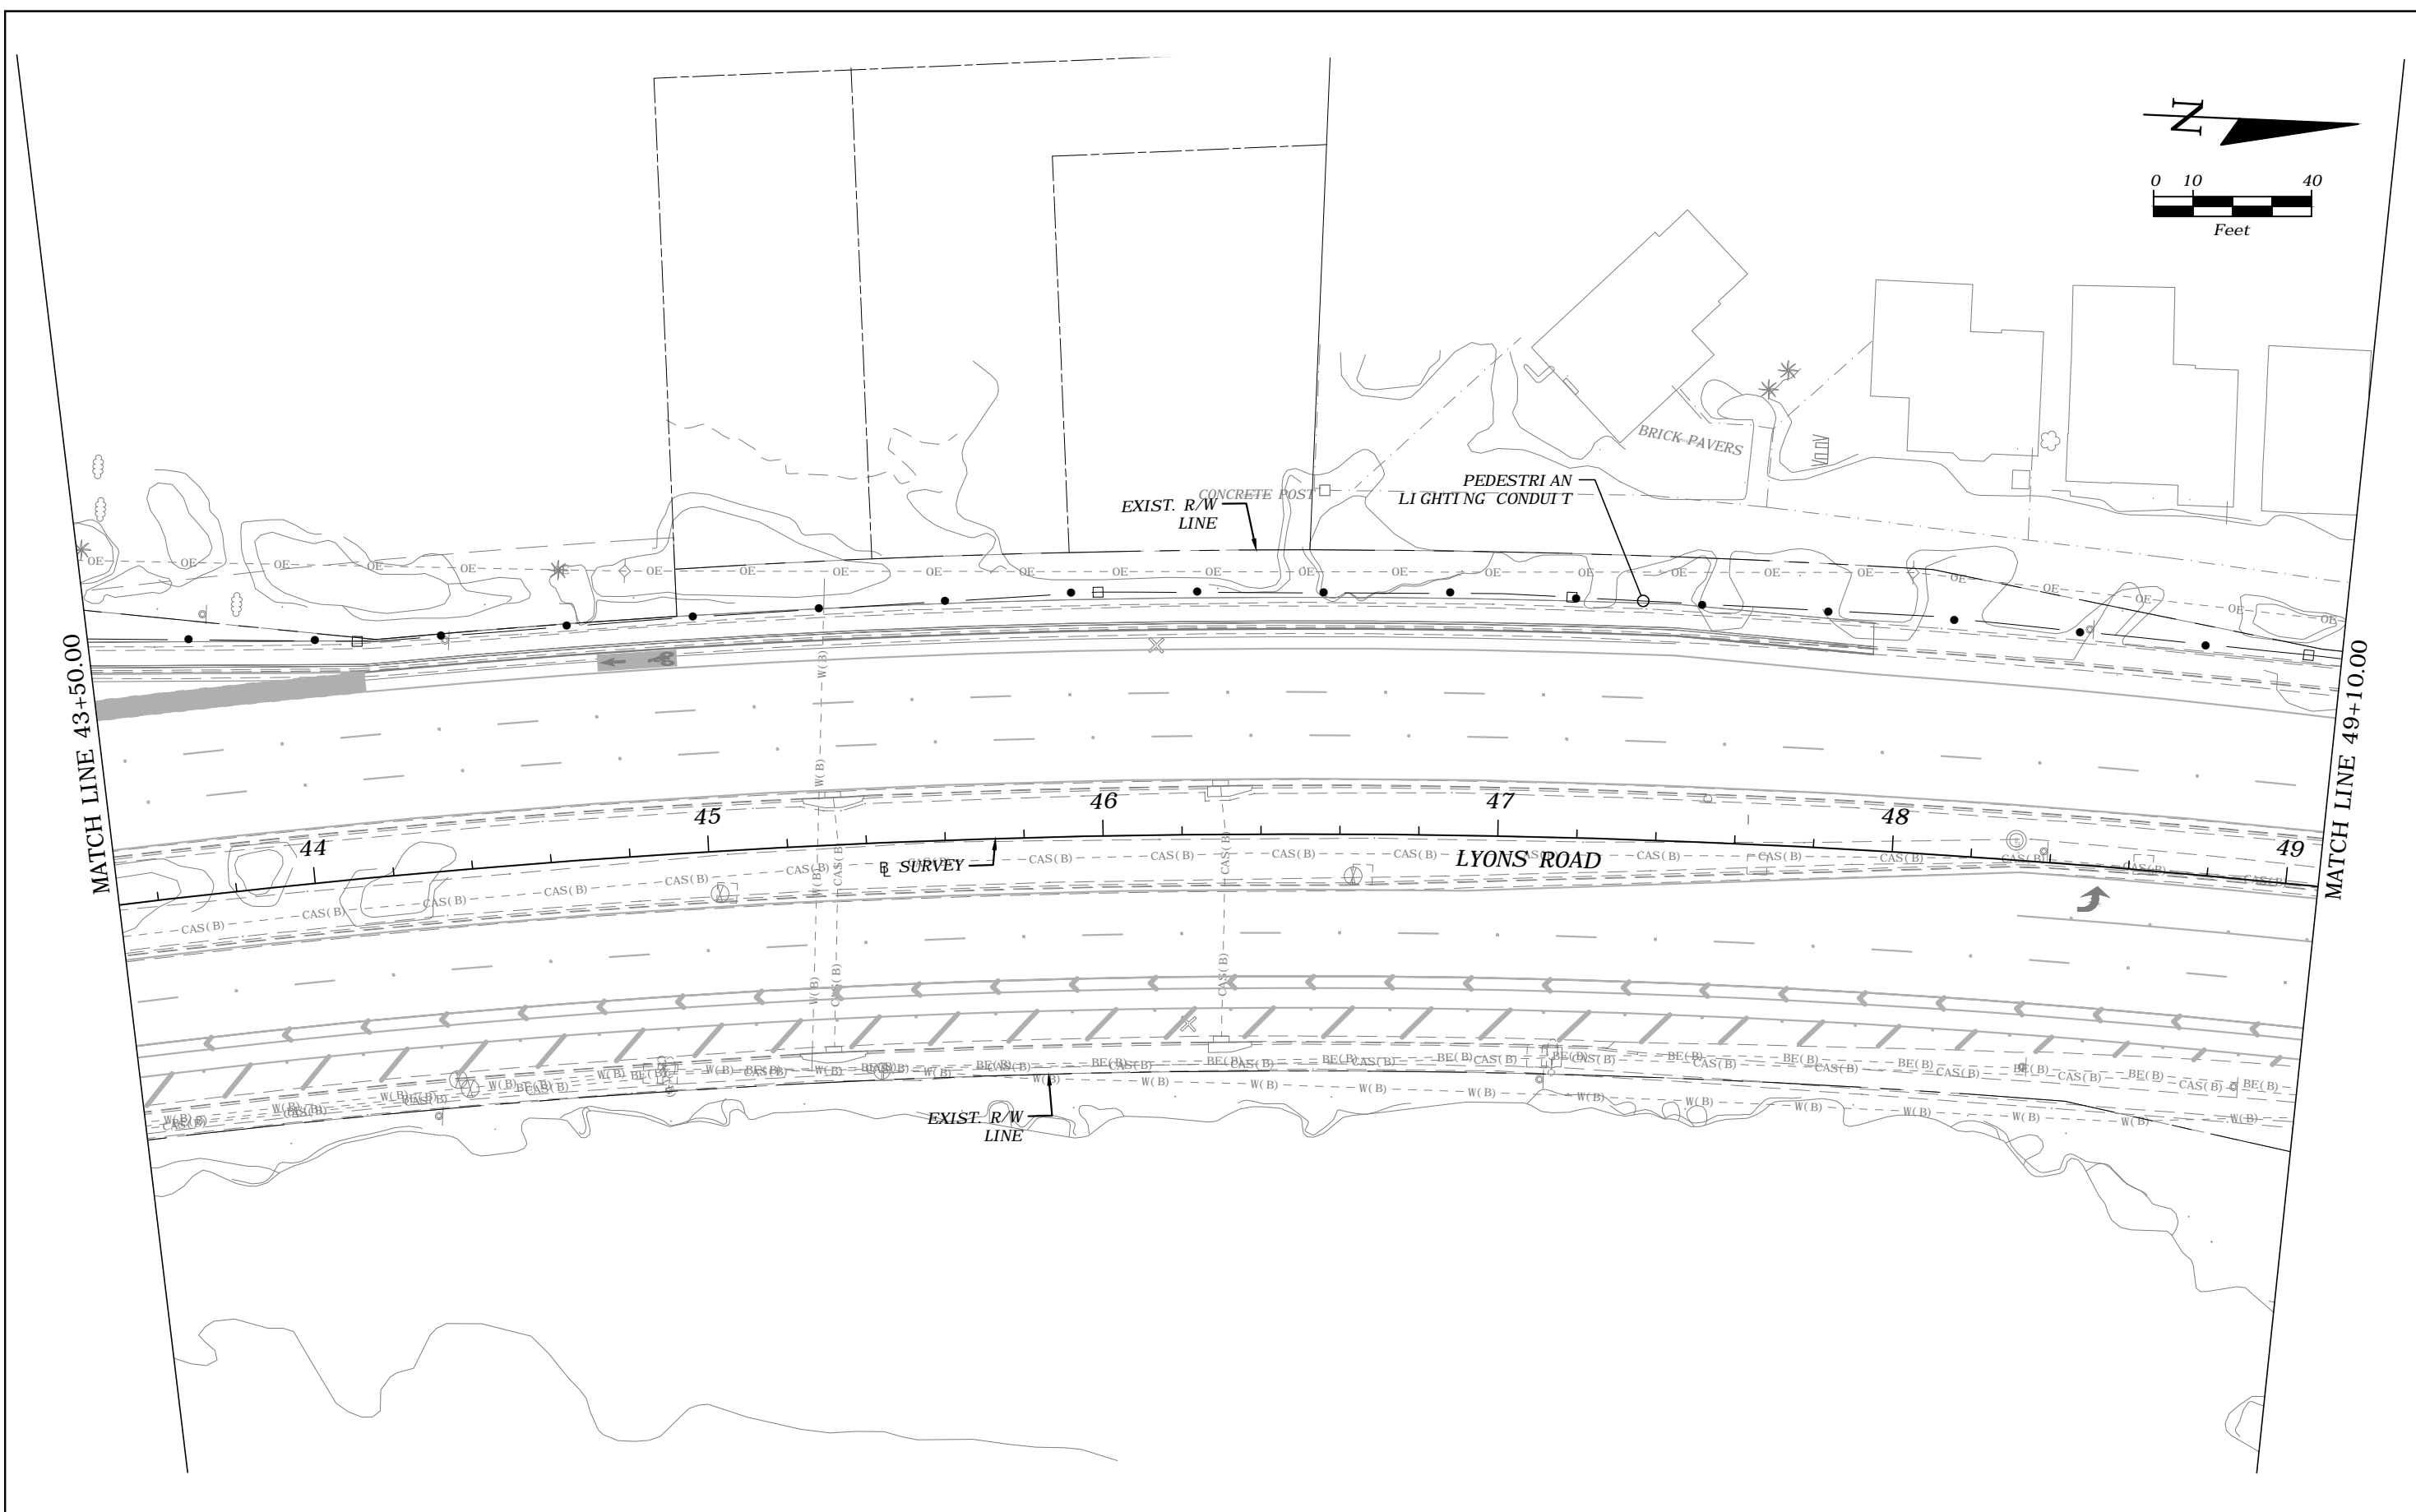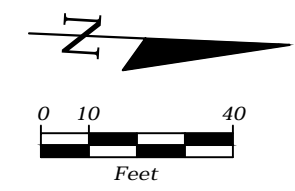



REVISIONS				FREDDIE A. VARGAS, P.E. P.E. LICENSE NUMBER 35941 CARNAHAN PROCTOR & CROSS, INC. 814 S. MILITARY TRAIL DEERFIELD BEACH, FL 33442 CERTIFICATE OF AUTHORIZATION 2936	STATE OF FLORIDA DEPARTMENT OF TRANSPORTATION			<i>PEDESTRIAN LIGHTING-CONDUIT          PLANS</i>	SHEET NO.  L-10
DATE	DESCRIPTION	DATE	DESCRIPTION		ROAD NO.	COUNTY	FINANCIAL PROJECT ID		
---	---								
					BROWARD	436319-1-52-03			

Terence Castillo

6/4/2019 11:20:16 AM

P:\projects\181201 - Pedestrian Light Features\43631915201\PLANL101.dwg

THE OFFICIAL RECORD OF THIS SHEET IS THE ELECTRONIC FILE DIGITALLY SIGNED AND SEALED UNDER RULE 61G15-23.004, F.A.C.

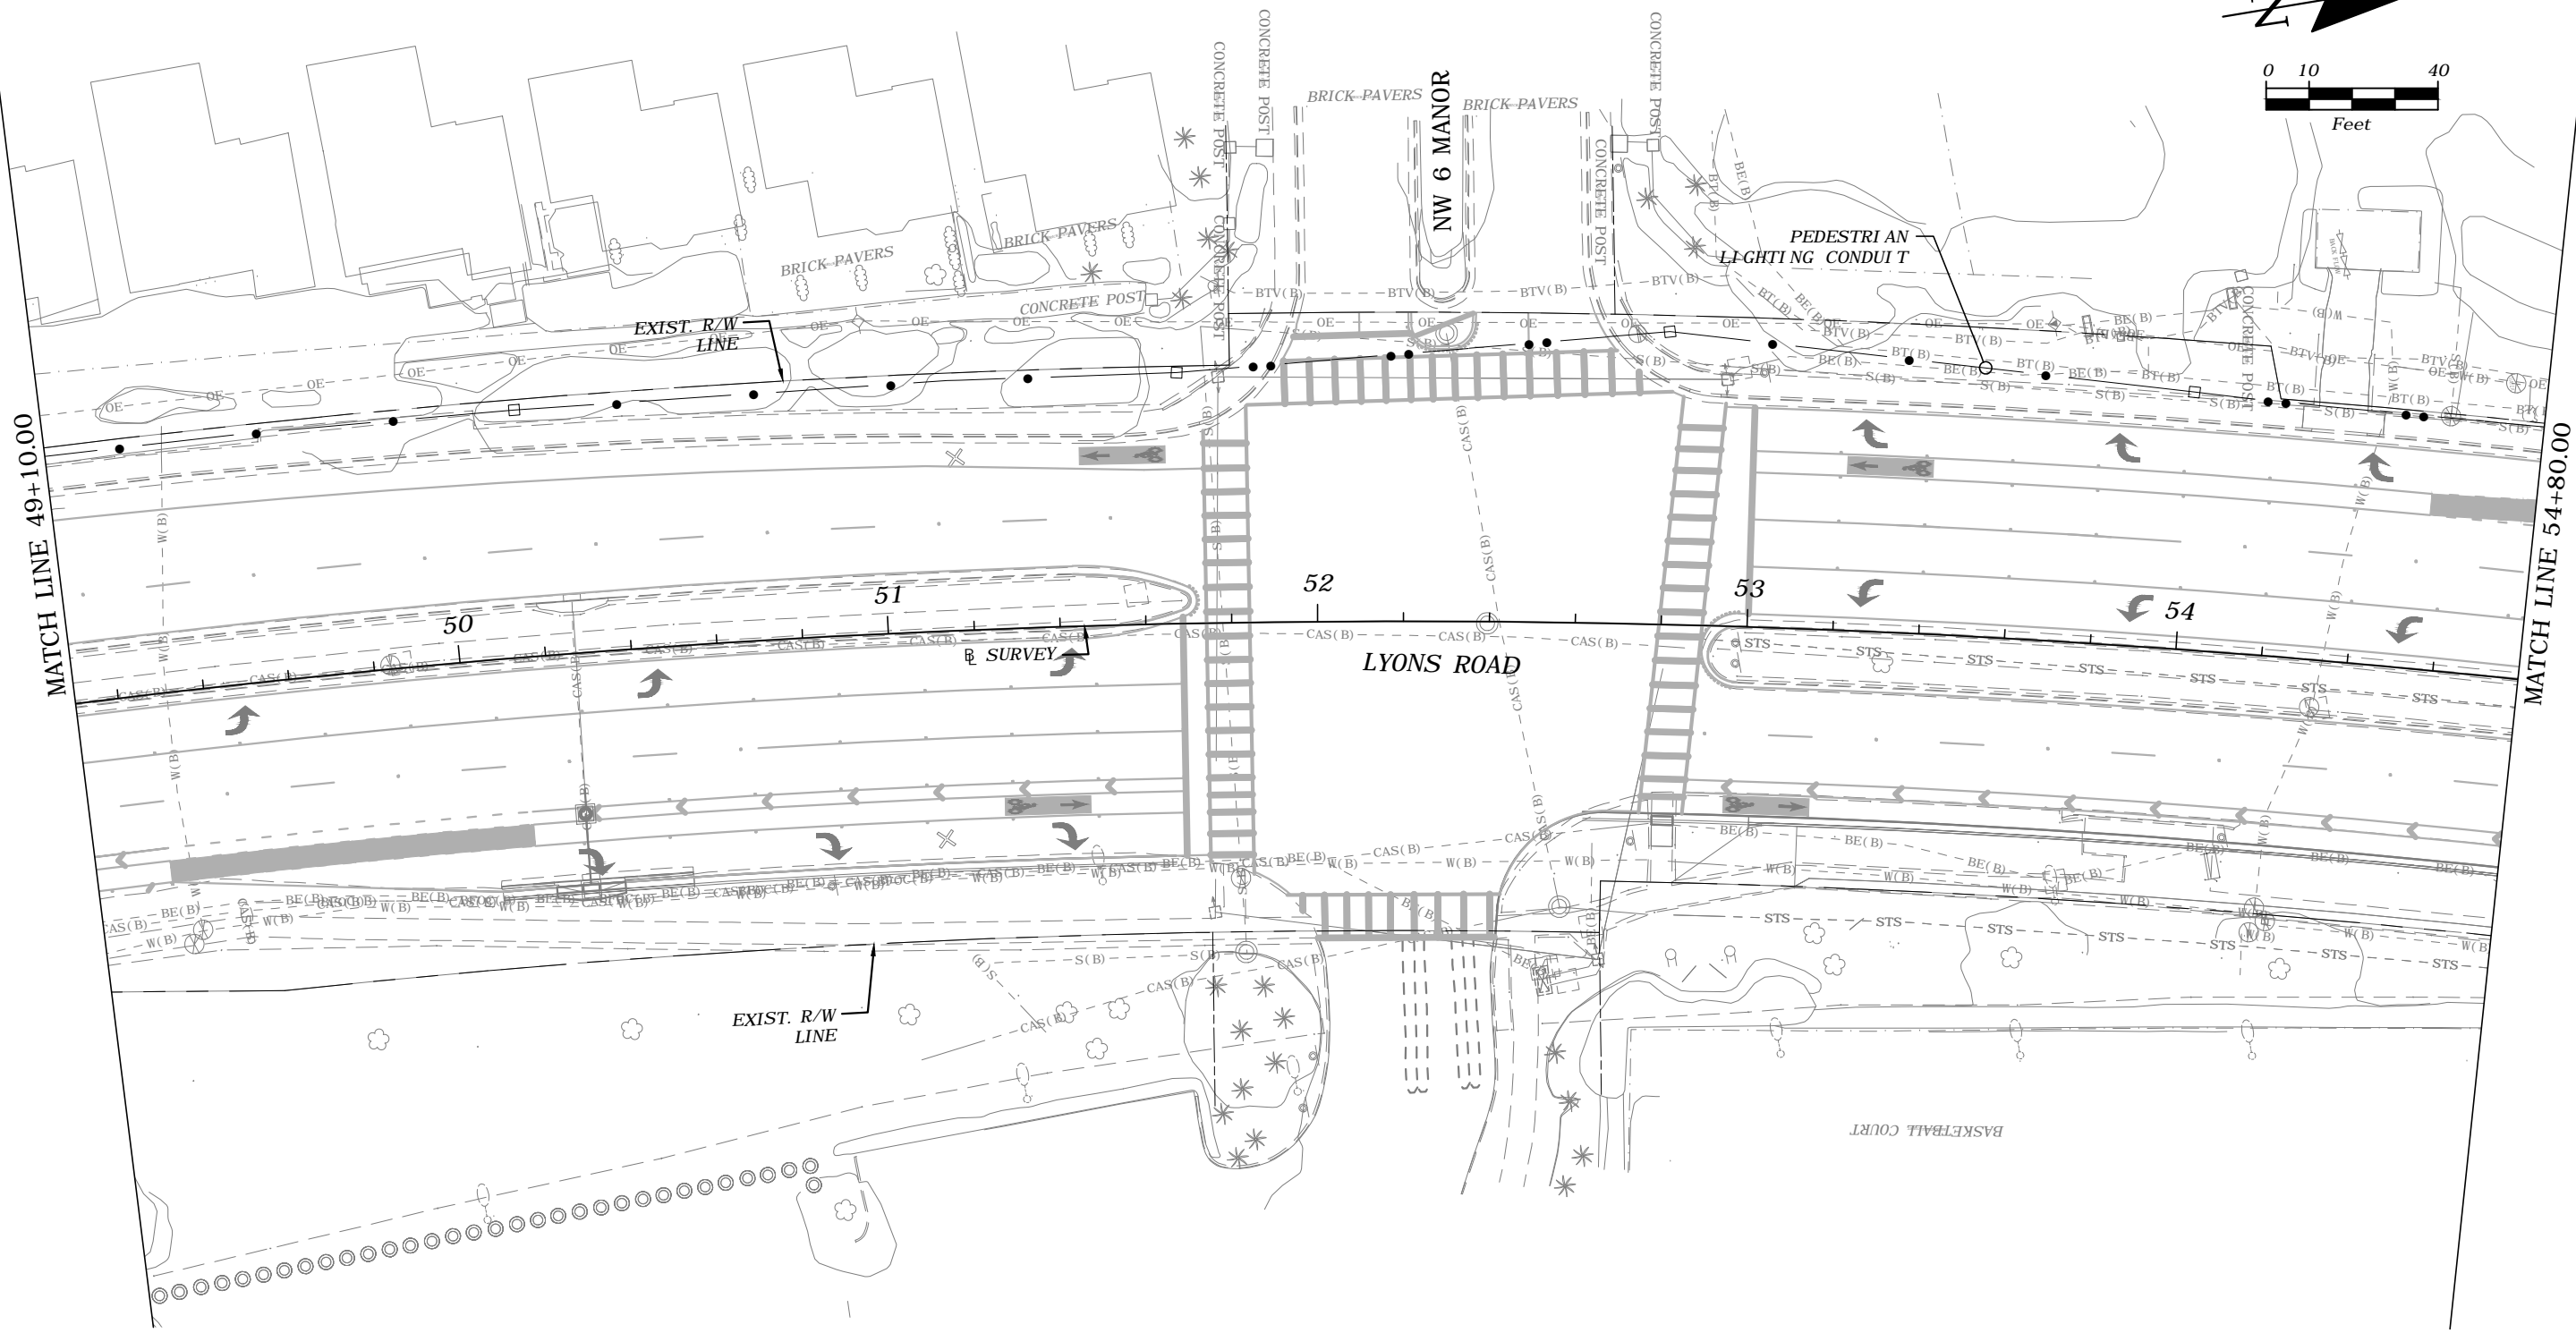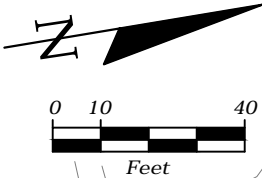


REVISIONS			
DATE	DESCRIPTION	DATE	DESCRIPTION
---	---	---	---

FREDDIE A. VARGAS, P.E.  
P.E. LICENSE NUMBER 35941  
CARNAHAN PROCTOR & CROSS, INC.  
814 S. MILITARY TRAIL  
DEERFIELD BEACH, FL 33442  
CERTIFICATE OF AUTHORIZATION 2936

STATE OF FLORIDA DEPARTMENT OF TRANSPORTATION		
ROAD NO.	COUNTY	FINANCIAL PROJECT ID
	BROWARD	436319-1-52-03


*PEDESTRIAN LIGHTING-CONDUIT  
PLANS*

SHEET NO.  
L-11

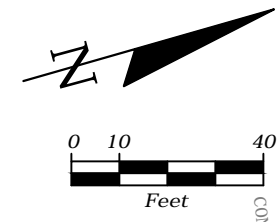

MATCH LINE 54+80.00

MATCH LINE 60+60.00

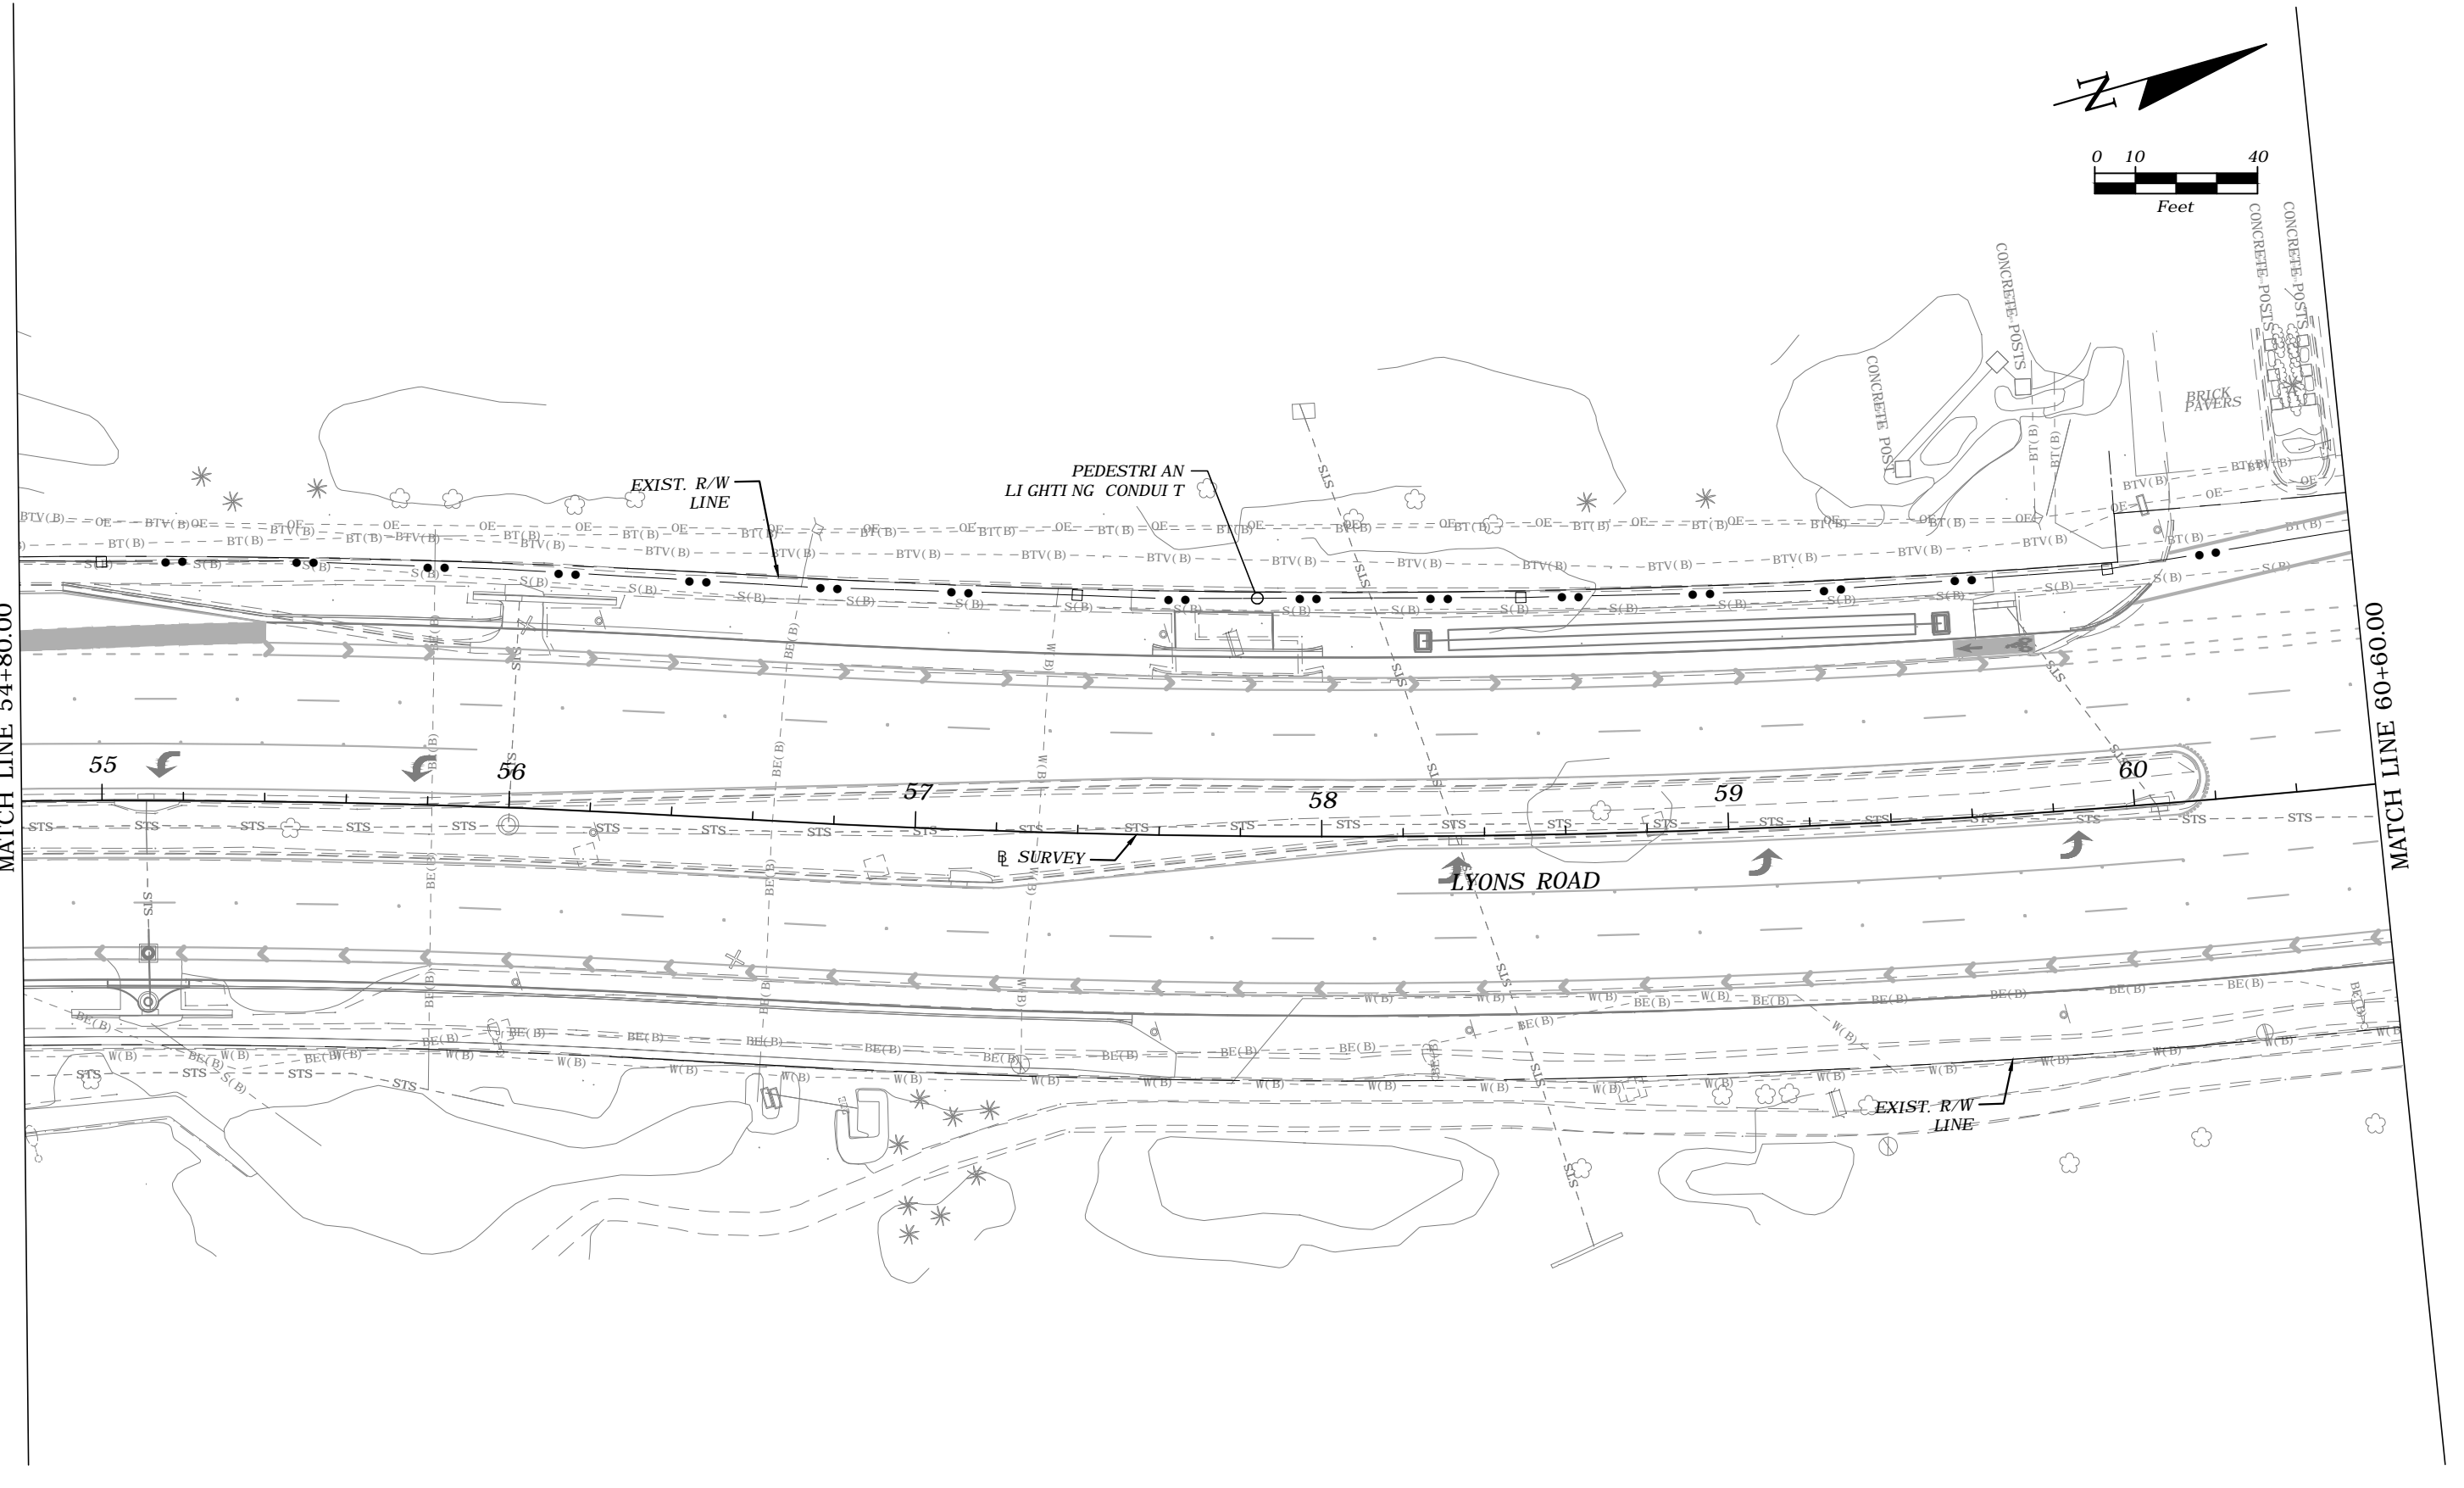

REVISIONS			
DATE	DESCRIPTION	DATE	DESCRIPTION
---	---	---	---


FREDDIE A. VARGAS, P.E.  
 P.E. LICENSE NUMBER 35941  
 CARNAHAN PROCTOR & CROSS, INC.  
 814 S. MILITARY TRAIL  
 DEERFIELD BEACH, FL 33442  
 CERTIFICATE OF AUTHORIZATION 2936

<b>STATE OF FLORIDA</b> <b>DEPARTMENT OF TRANSPORTATION</b>		
ROAD NO.	COUNTY	FINANCIAL PROJECT ID
	BROWARD	436319-1-52-03

***PEDESTRIAN LIGHTING-CONDUIT***  
***PLANS***


SHEET NO.  
**L-12**

THE OFFICIAL RECORD OF THIS SHEET IS THE ELECTRONIC FILE DIGITALLY SIGNED AND SEALED UNDER RULE 61G15-23.004, F.A.C.

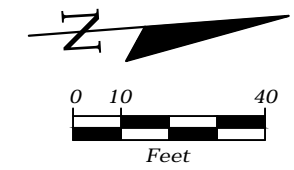

MATCH LINE 60+60.00

MATCH LINE 66+20.00

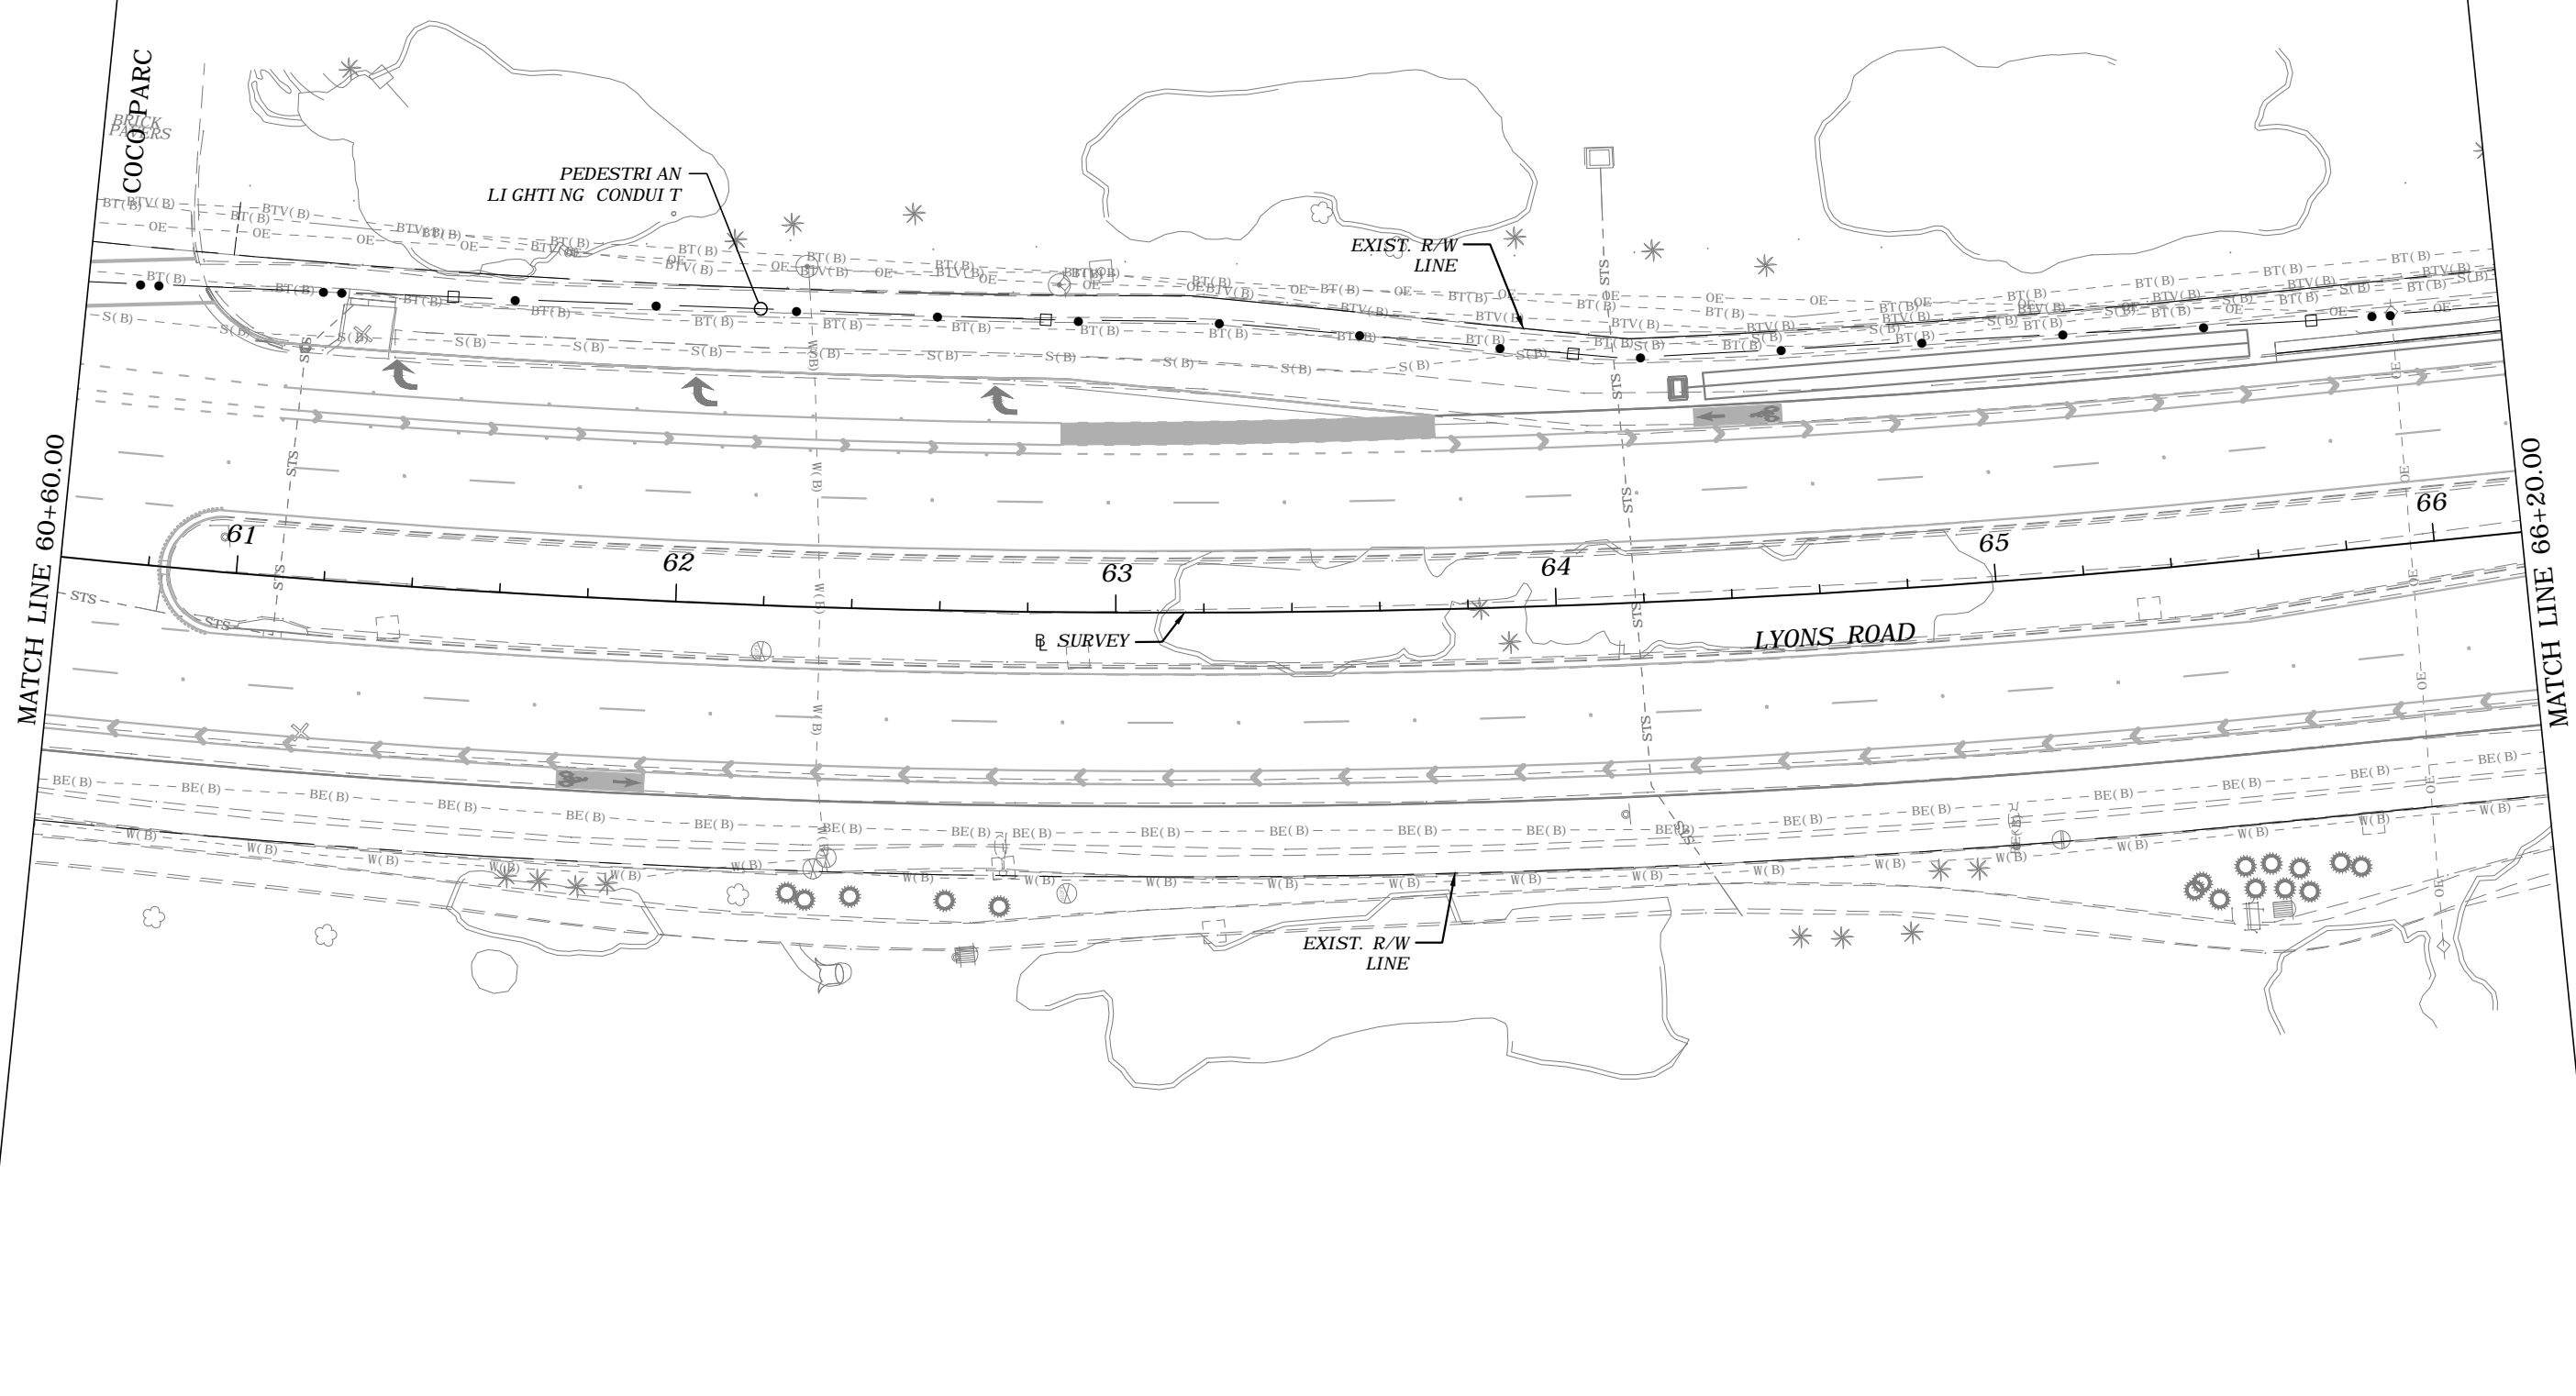

REVISIONS			
DATE	DESCRIPTION	DATE	DESCRIPTION
---	---	---	---



FREDDIE A. VARGAS, P.E.  
 P.E. LICENSE NUMBER 35941  
 CARNAHAN PROCTOR & CROSS, INC.  
 814 S. MILITARY TRAIL  
 DEERFIELD BEACH, FL 33442  
 CERTIFICATE OF AUTHORIZATION 2936

<b>STATE OF FLORIDA</b> <b>DEPARTMENT OF TRANSPORTATION</b>		
ROAD NO.	COUNTY	FINANCIAL PROJECT ID
	BROWARD	436319-1-52-03

*PEDESTRIAN LIGHTING-CONDUIT*  
*PLANS*

SHEET NO.  
**L-13**

THE OFFICIAL RECORD OF THIS SHEET IS THE ELECTRONIC FILE DIGITALLY SIGNED AND SEALED UNDER RULE 61G15-23.004, F.A.C.

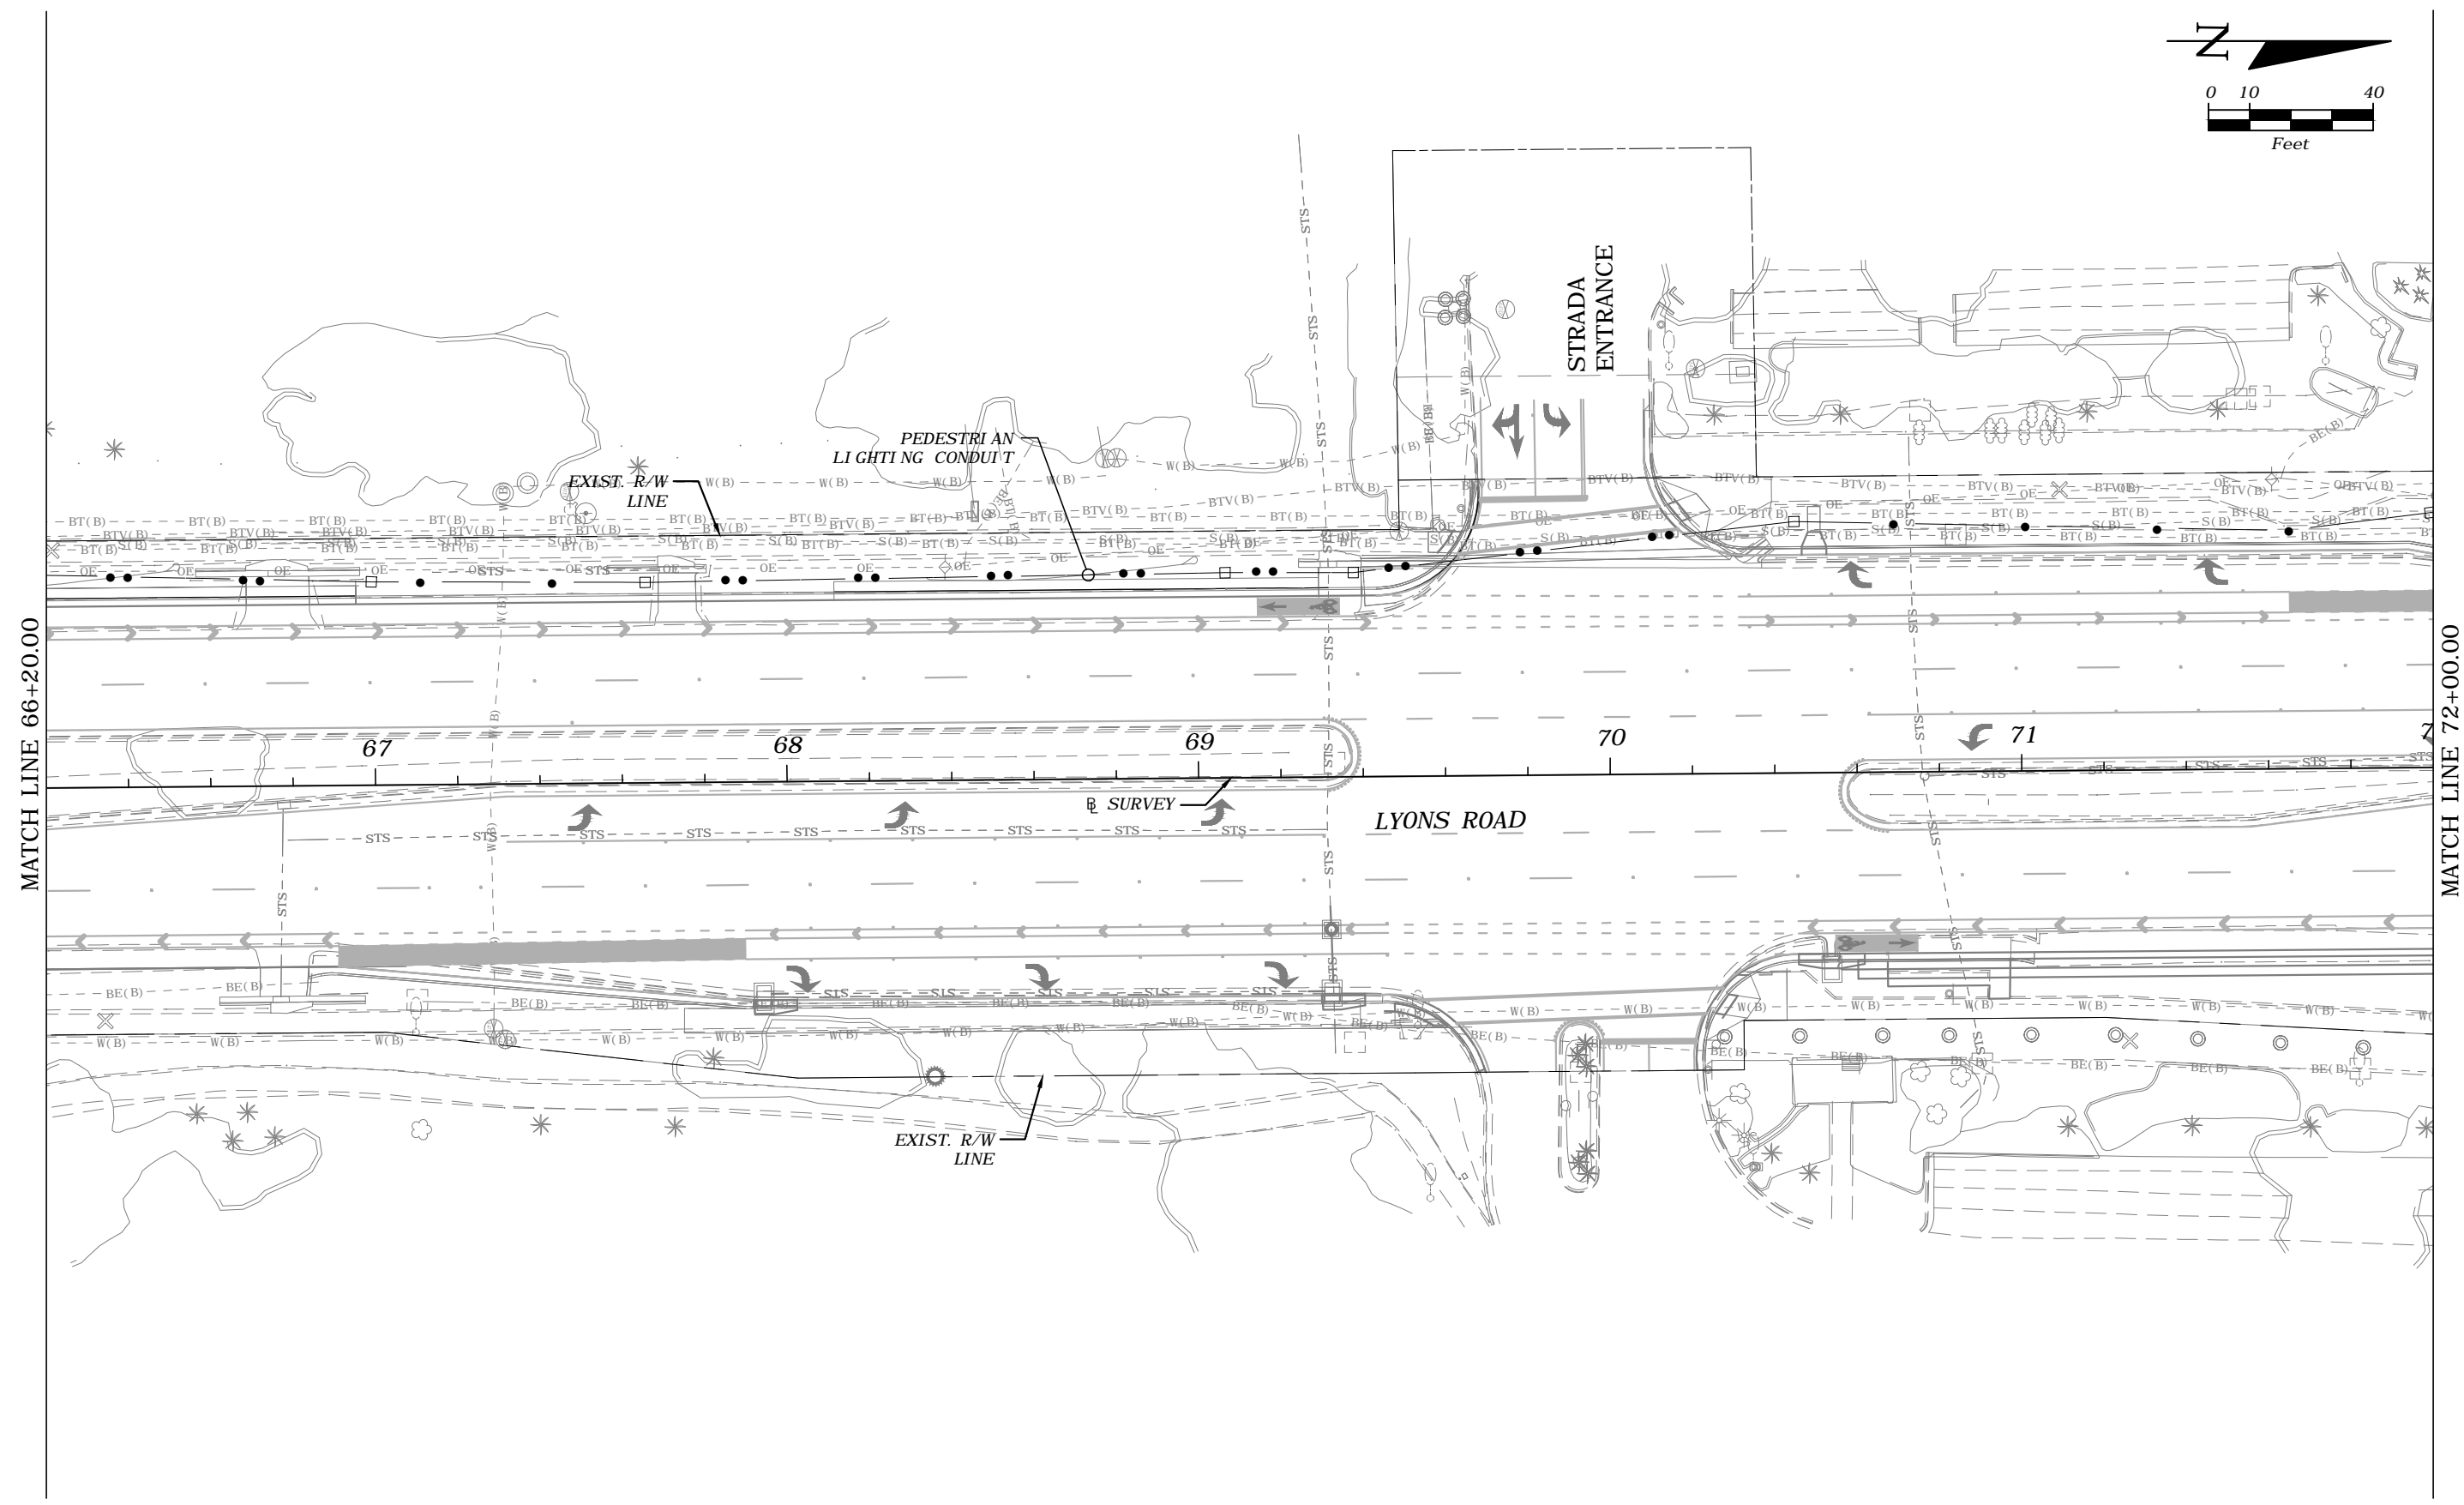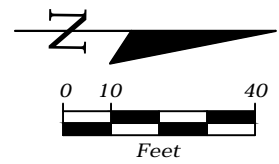

MATCH LINE 66+20.00

MATCH LINE 72+00.00



REVISIONS				FREDDIE A. VARGAS, P.E. P.E. LICENSE NUMBER 35941 CARNAHAN PROCTOR & CROSS, INC. 814 S. MILITARY TRAIL DEERFIELD BEACH, FL 33442 CERTIFICATE OF AUTHORIZATION 2936	STATE OF FLORIDA DEPARTMENT OF TRANSPORTATION			<i>PEDESTRIAN LIGHTING-CONDUIT          PLANS</i>	SHEET NO.
DATE	DESCRIPTION	DATE	DESCRIPTION		ROAD NO.	COUNTY	FINANCIAL PROJECT ID		L-14
---	---	---	---						

Terence Castillo

6/4/2019 11:21:31 AM

P:\projects\181201 - Pedestrian Light Features\43631915201\PLANL101.dwg

THE OFFICIAL RECORD OF THIS SHEET IS THE ELECTRONIC FILE DIGITALLY SIGNED AND SEALED UNDER RULE 61G15-23.004, F.A.C.

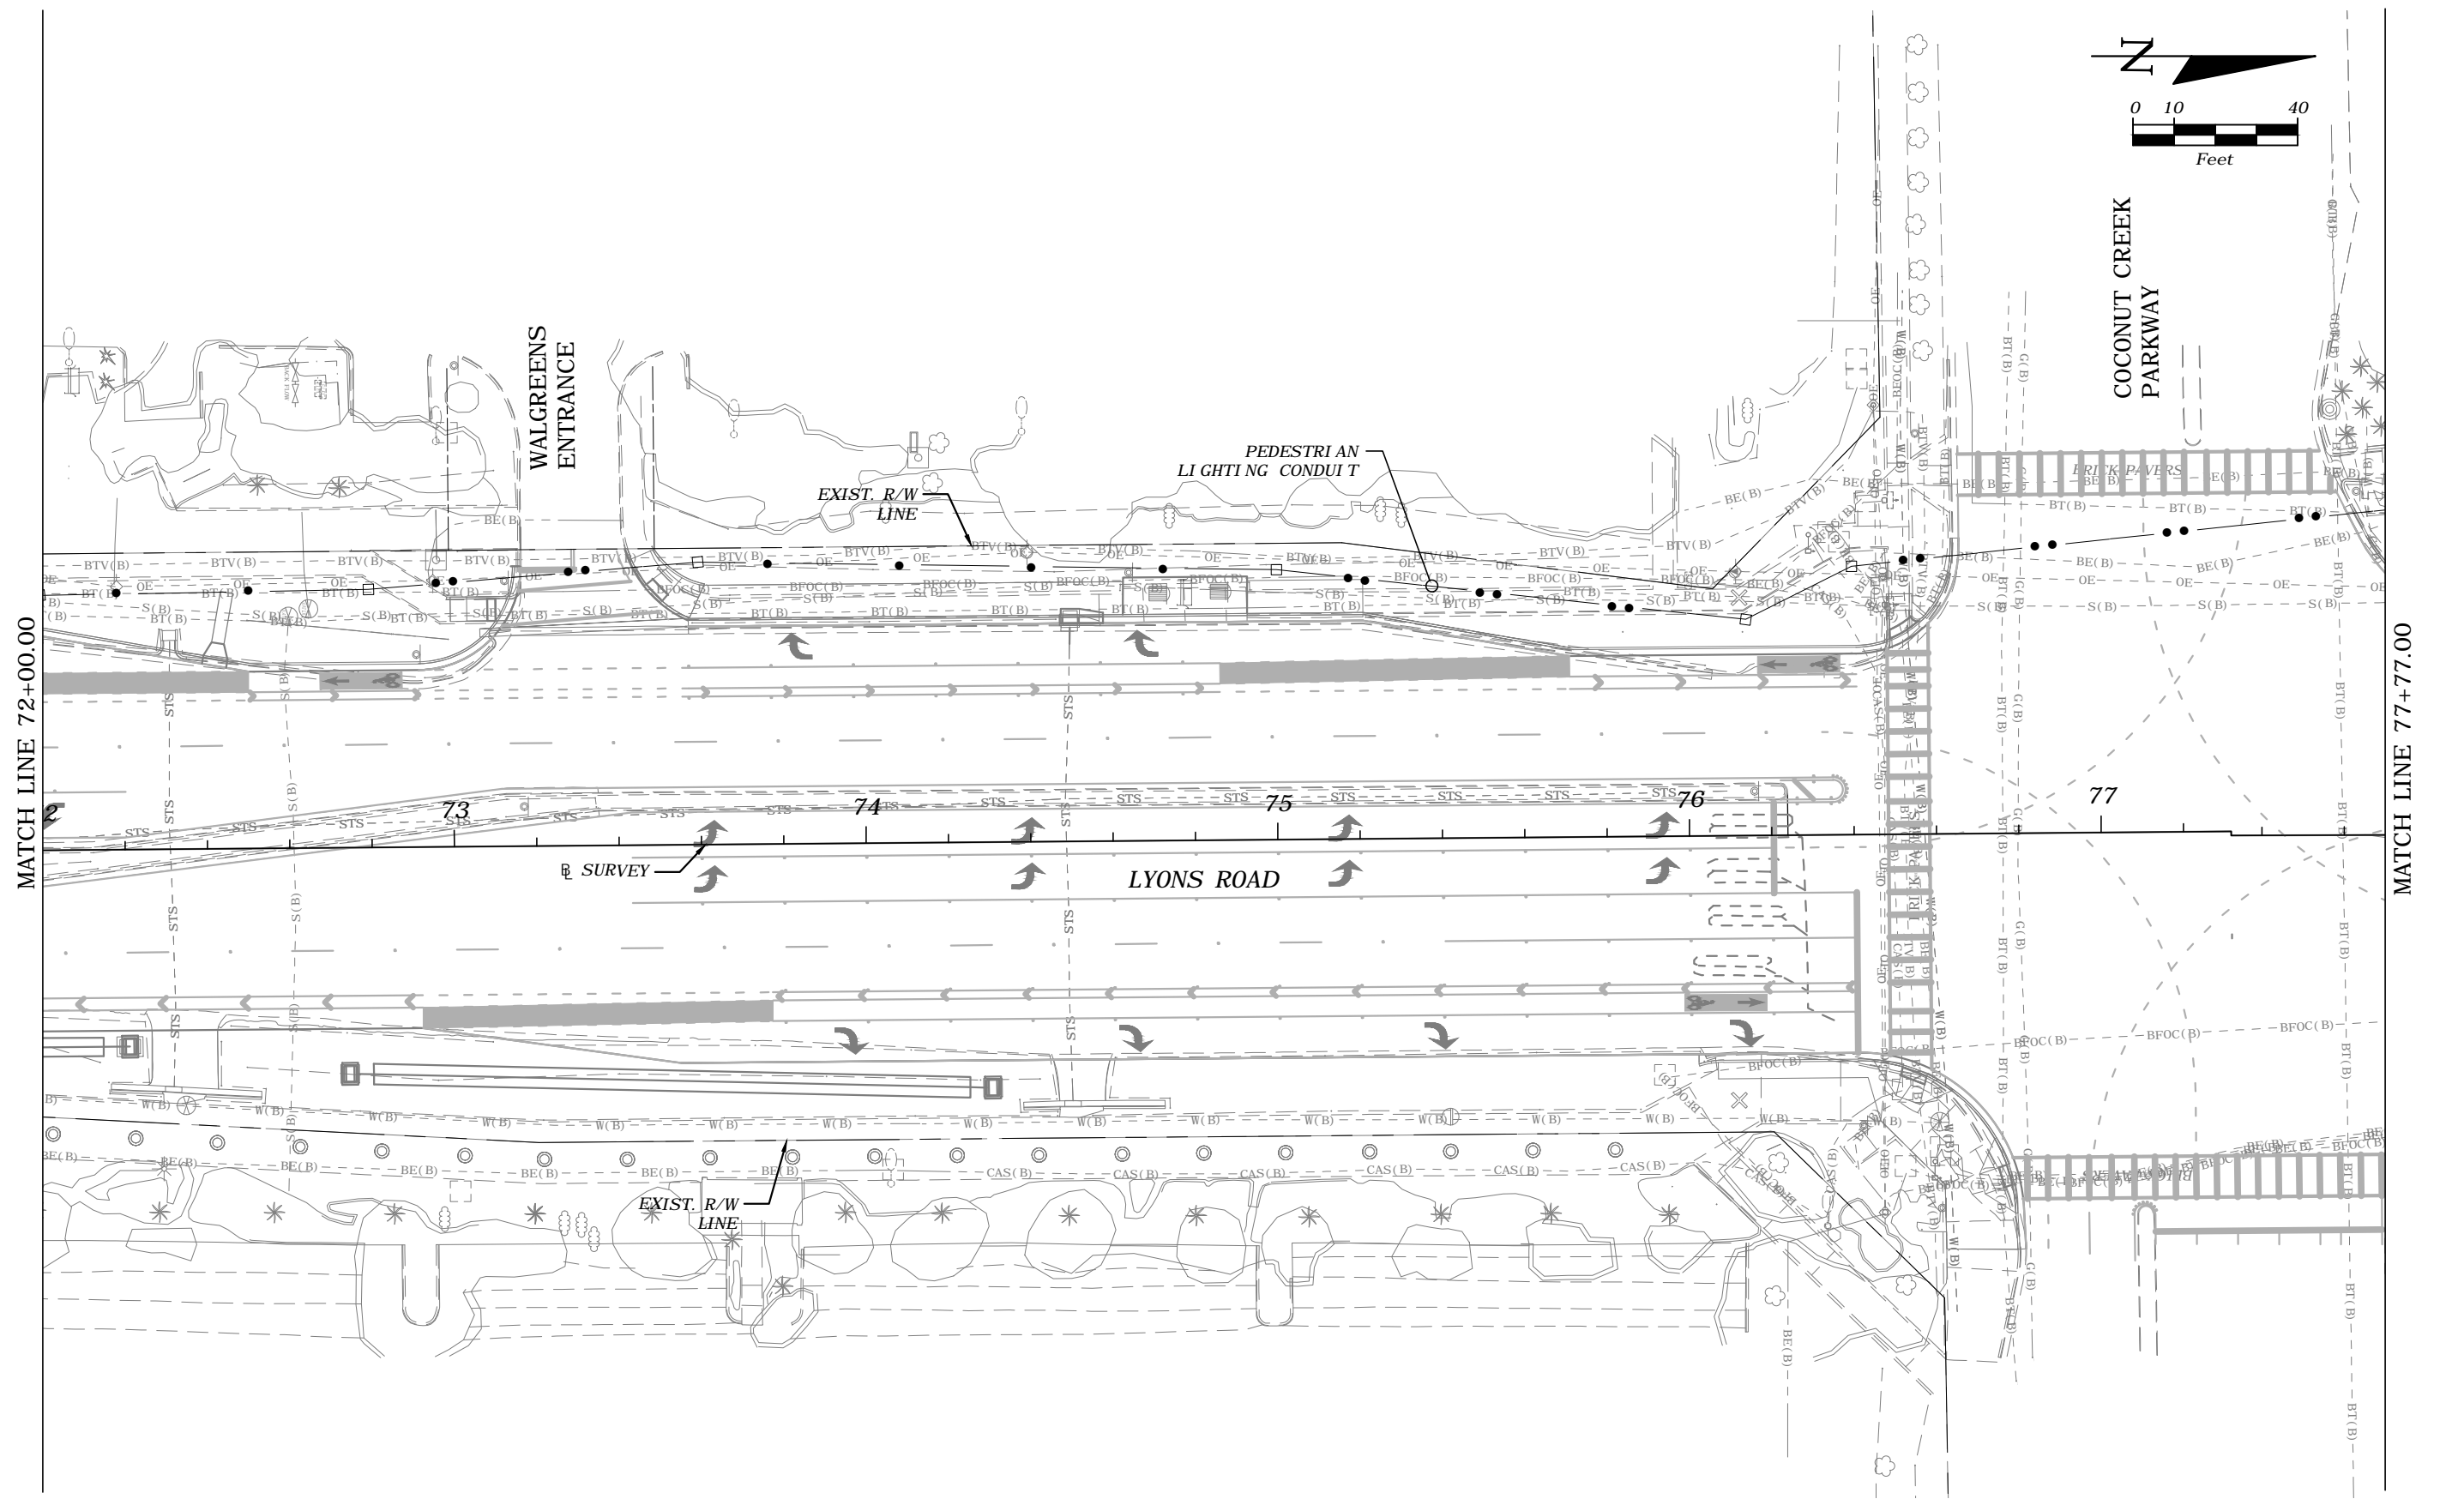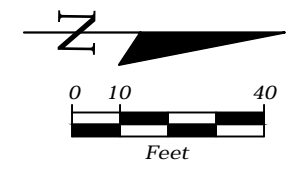

MATCH LINE 72+00.00

MATCH LINE 77+77.00

REVISIONS			
DATE	DESCRIPTION	DATE	DESCRIPTION
---	---	---	---



FREDDIE A. VARGAS, P.E.  
 P.E. LICENSE NUMBER 35941  
 CARNAHAN PROCTOR & CROSS, INC.  
 814 S. MILITARY TRAIL  
 DEERFIELD BEACH, FL 33442  
 CERTIFICATE OF AUTHORIZATION 2936

<b>STATE OF FLORIDA</b> <b>DEPARTMENT OF TRANSPORTATION</b>		
ROAD NO.	COUNTY	FINANCIAL PROJECT ID
	BROWARD	436319-1-52-03

***PEDESTRIAN LIGHTING-CONDUIT***  
***PLANS***

SHEET NO.  
 L-15

THE OFFICIAL RECORD OF THIS SHEET IS THE ELECTRONIC FILE DIGITALLY SIGNED AND SEALED UNDER RULE 61G15-23.004, F.A.C.

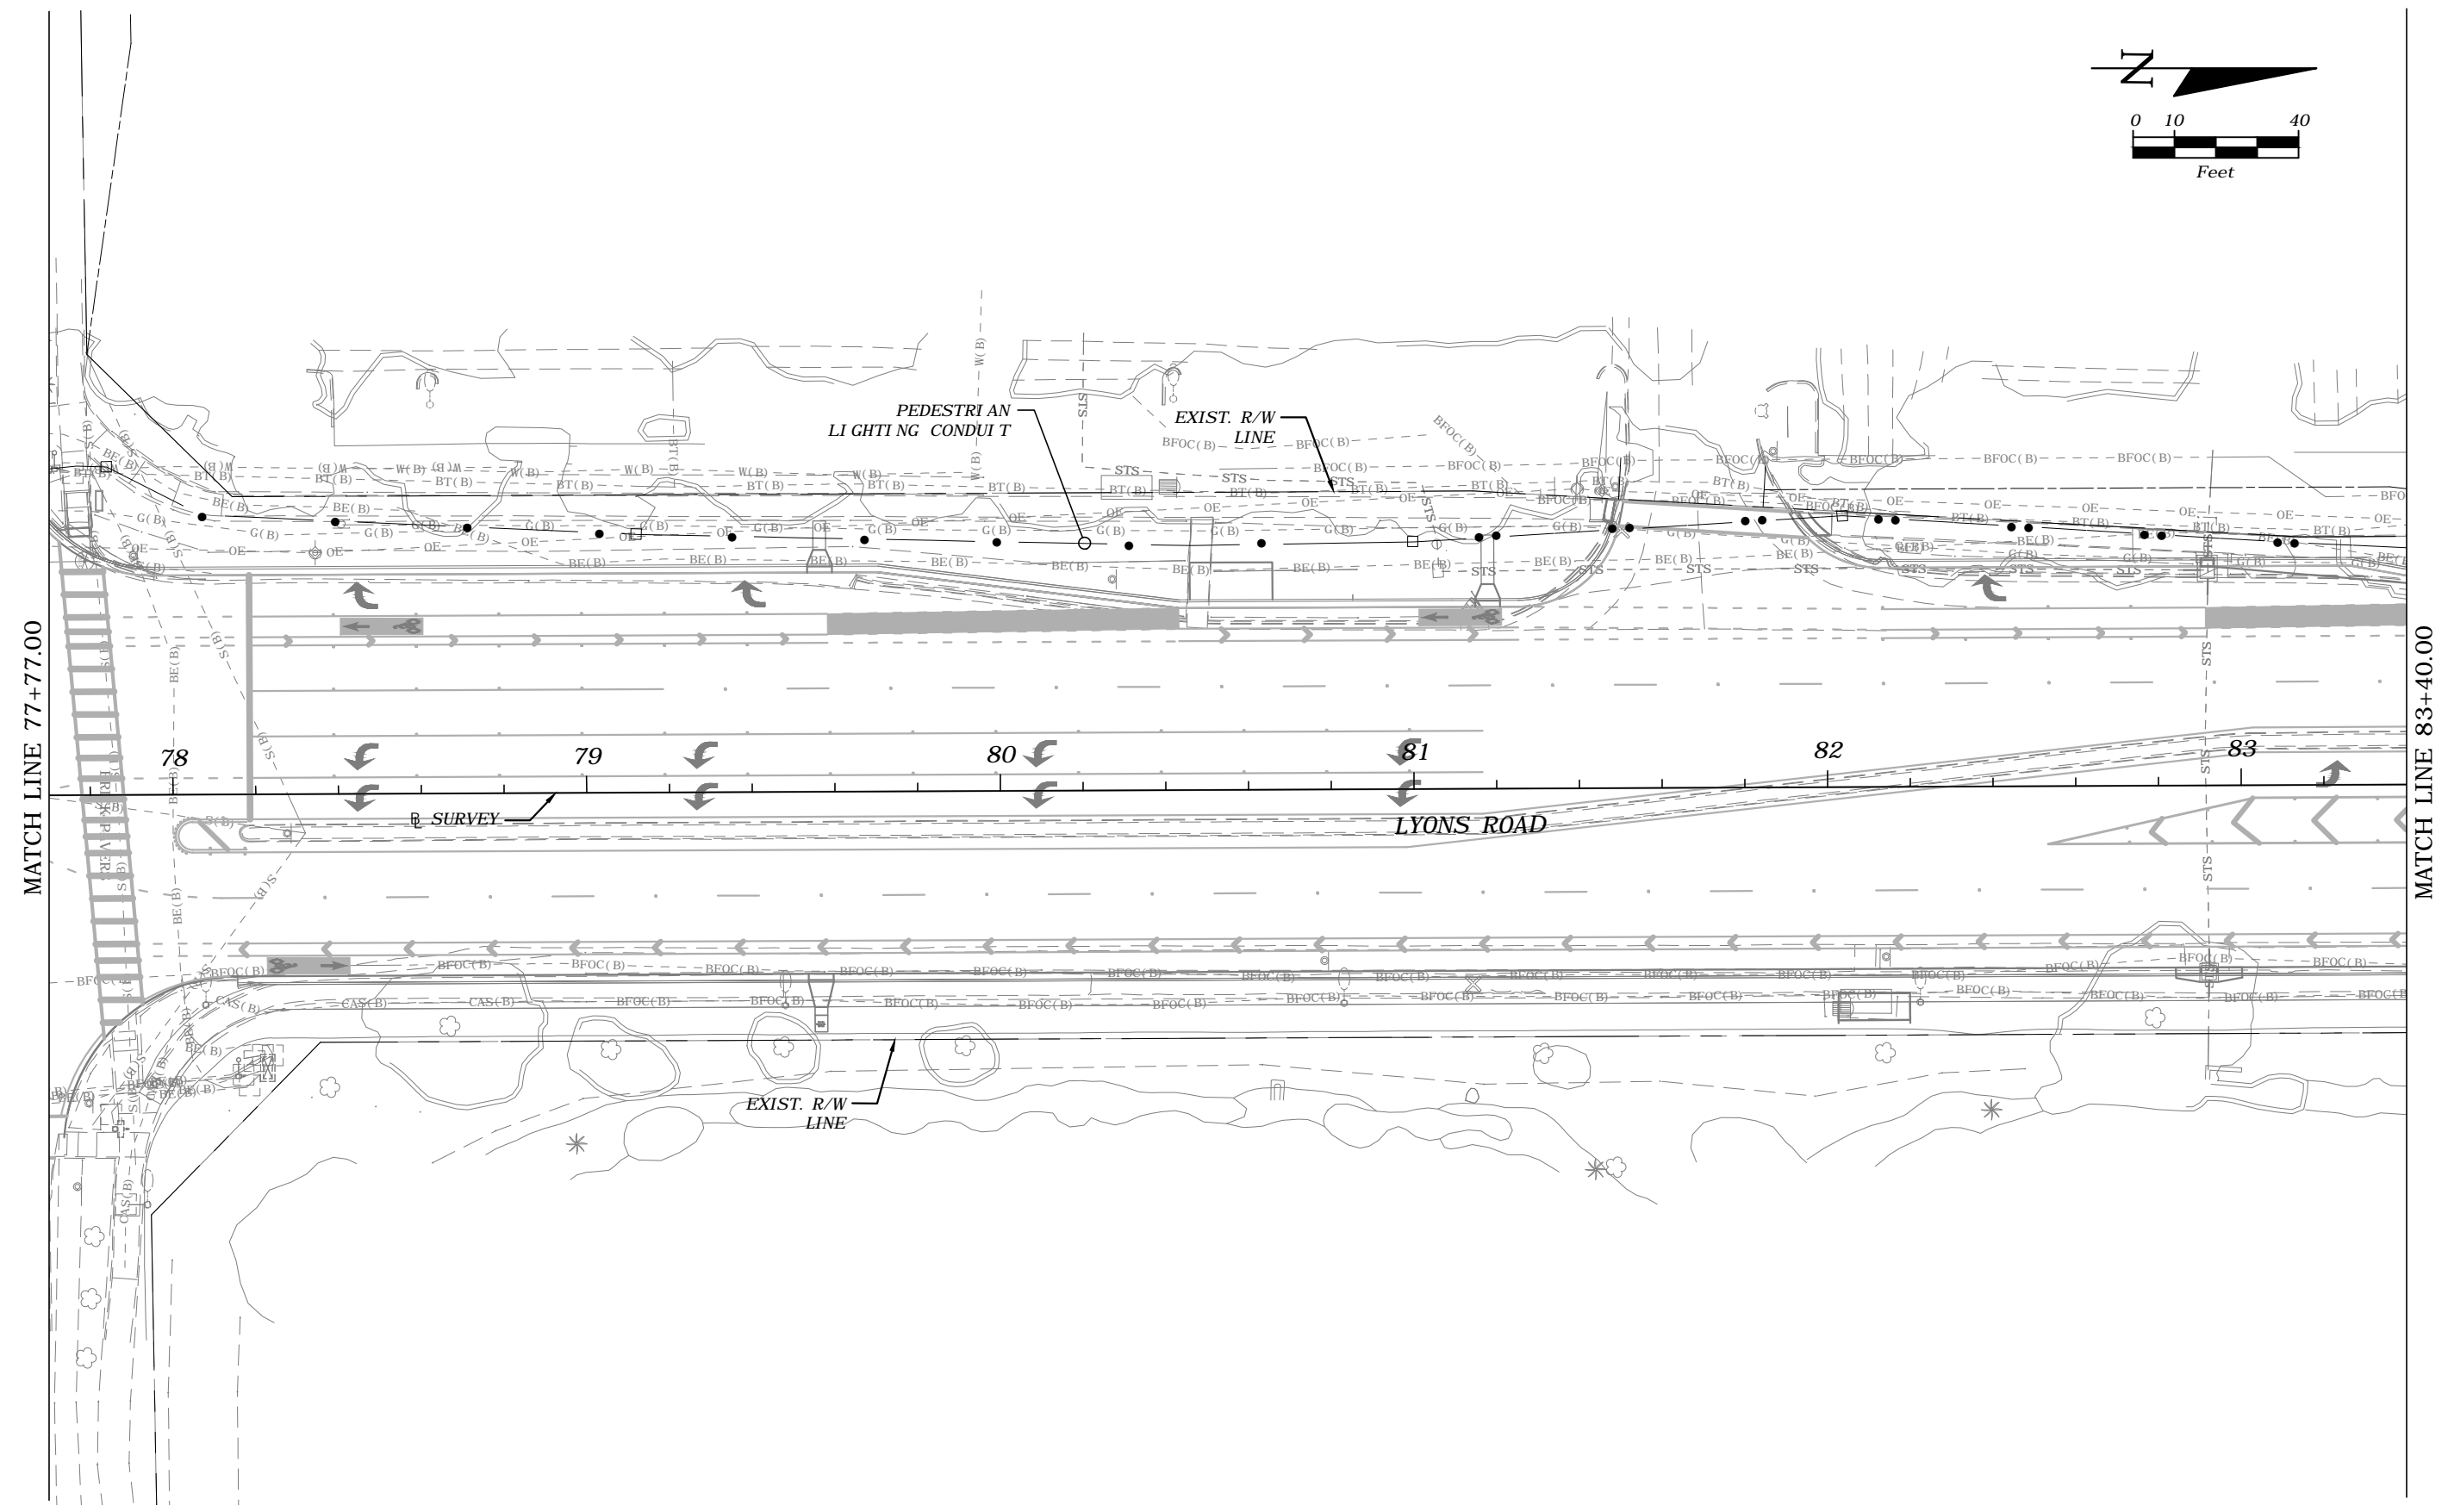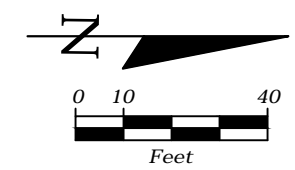

MATCH LINE 77+77.00

MATCH LINE 83+40.00

REVISIONS			
DATE	DESCRIPTION	DATE	DESCRIPTION
---	---	---	---

FREDDIE A. VARGAS, P.E.  
 P.E. LICENSE NUMBER 35941  
 CARNAHAN PROCTOR & CROSS, INC.  
 814 S. MILITARY TRAIL  
 DEERFIELD BEACH, FL 33442  
 CERTIFICATE OF AUTHORIZATION 2936



<b>STATE OF FLORIDA</b> <b>DEPARTMENT OF TRANSPORTATION</b>		
ROAD NO.	COUNTY	FINANCIAL PROJECT ID
	BROWARD	436319-1-52-03

***PEDESTRIAN LIGHTING-CONDUIT***  
***PLANS***

SHEET NO.  
**L-16**

THE OFFICIAL RECORD OF THIS SHEET IS THE ELECTRONIC FILE DIGITALLY SIGNED AND SEALED UNDER RULE 61G15-23.004, F.A.C.



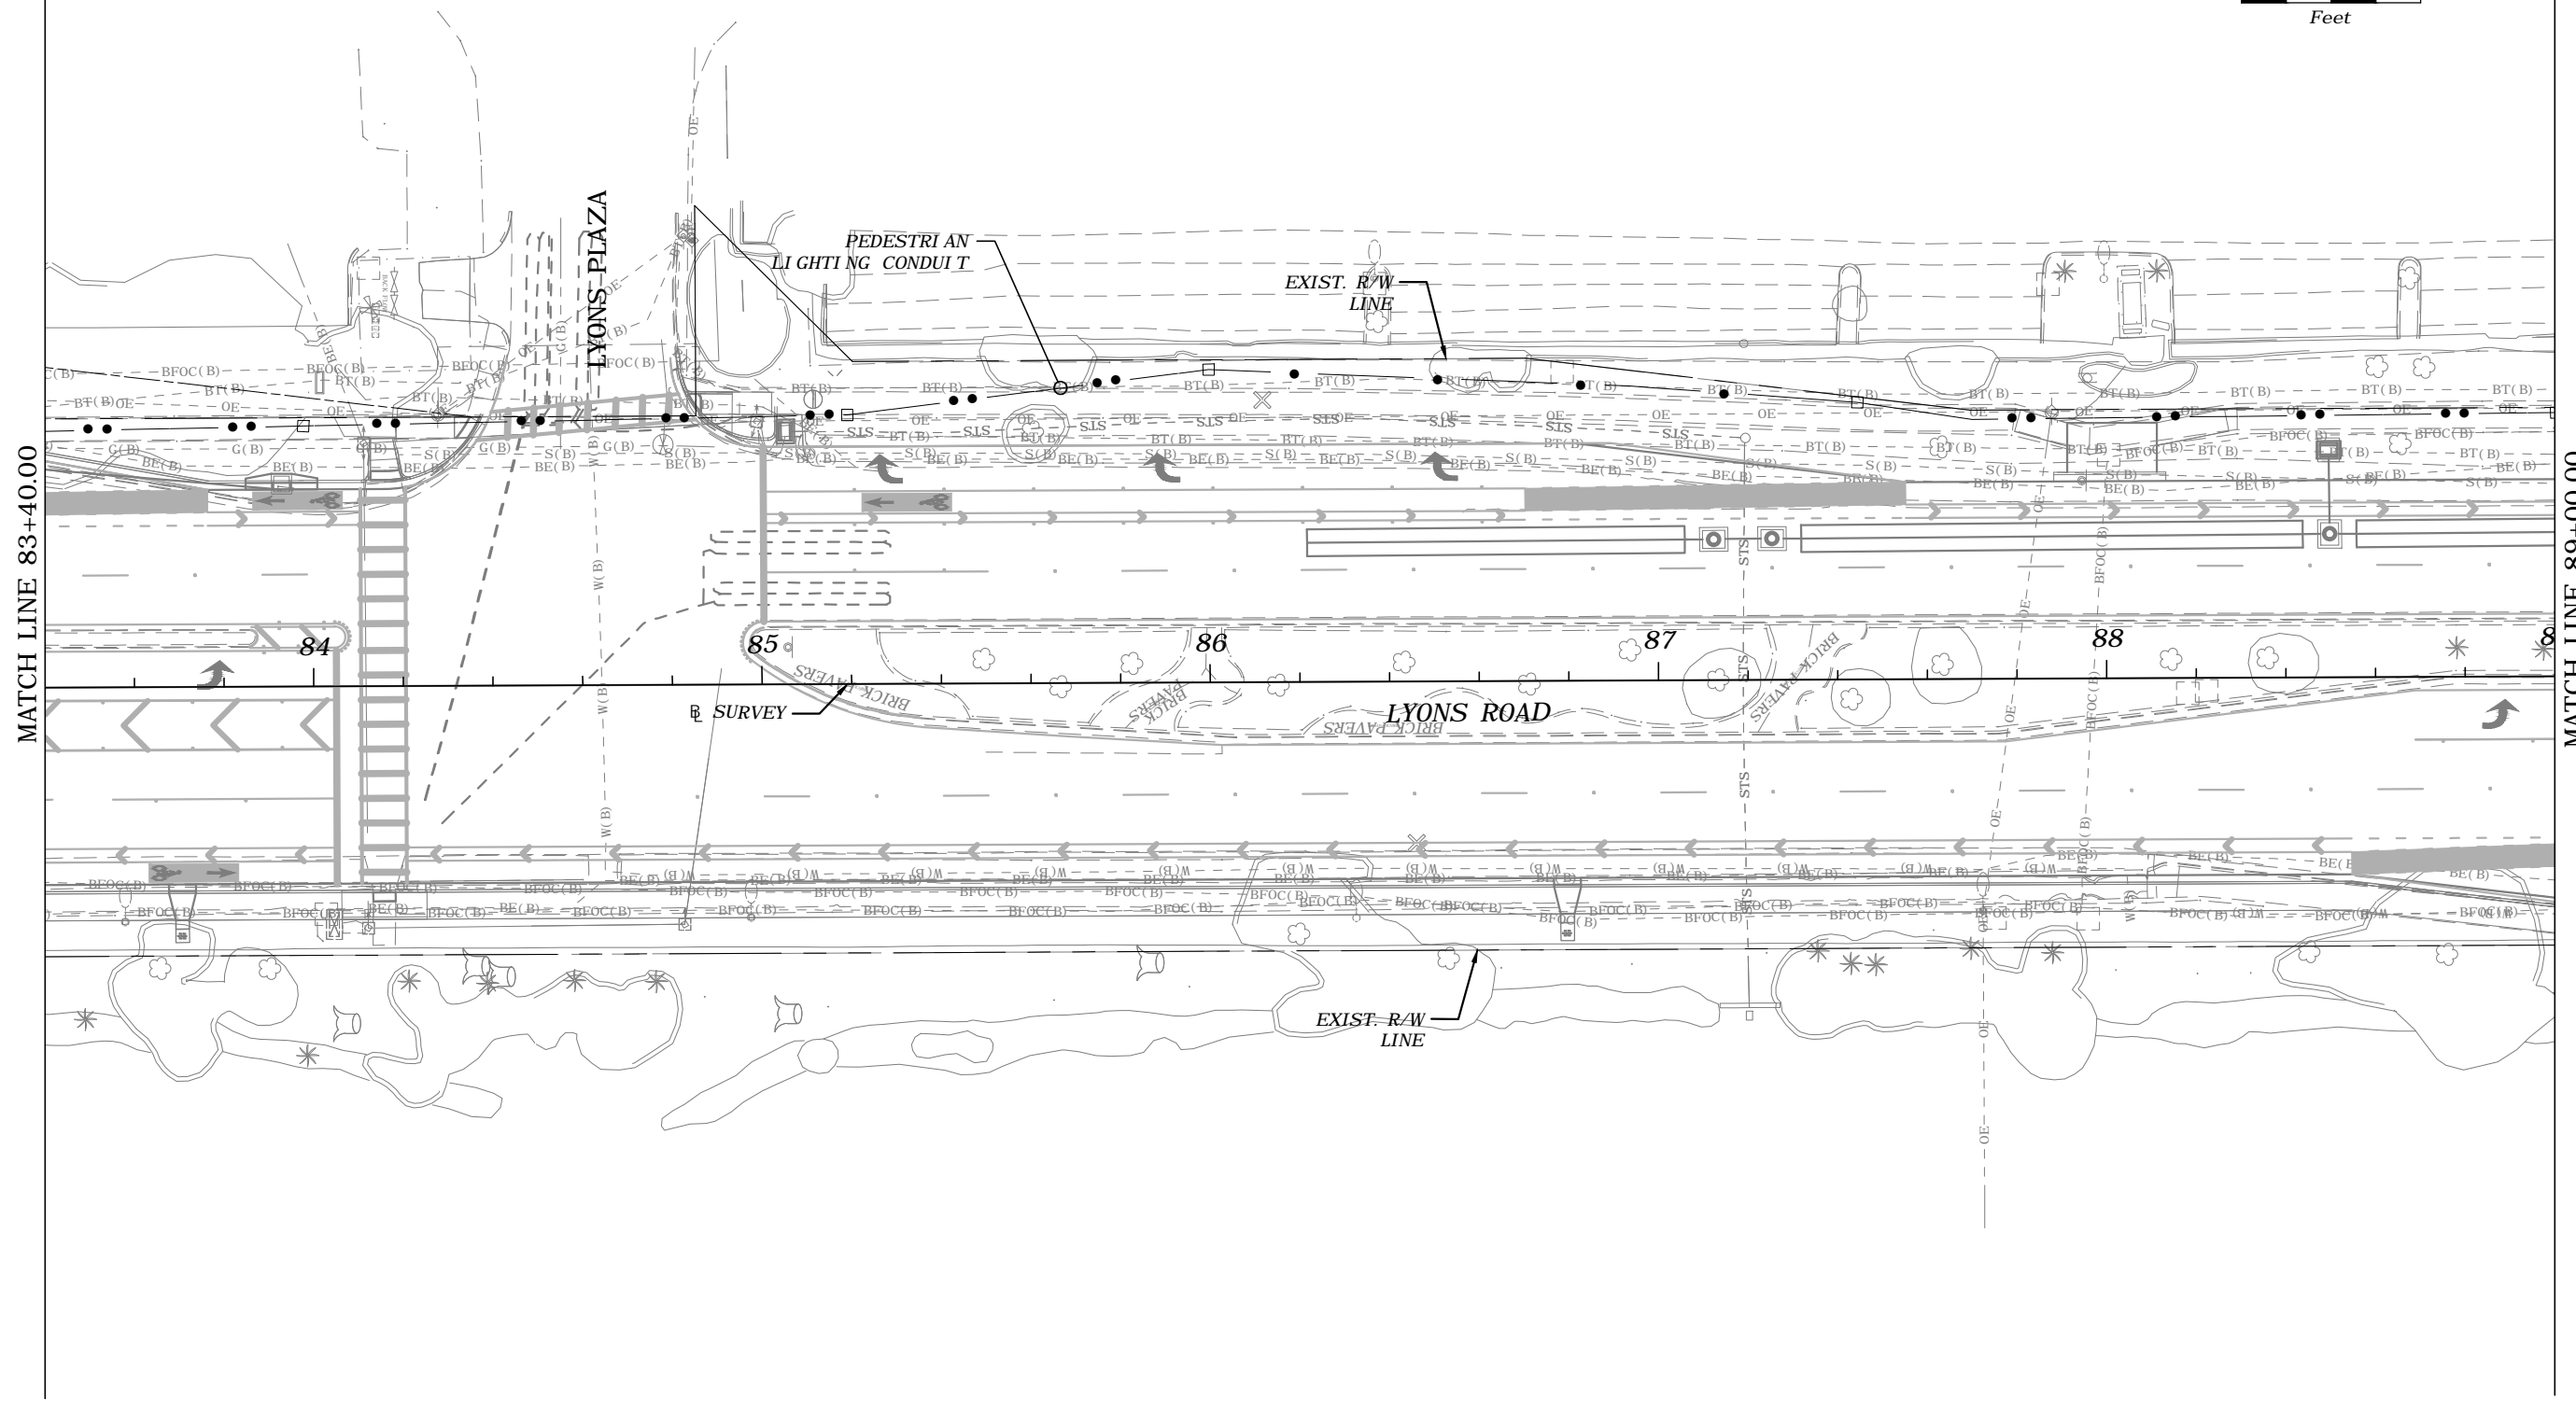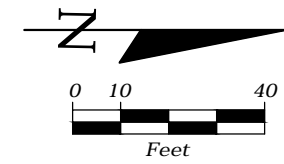

MATCH LINE 83+40.00

MATCH LINE 89+00.00



REVISIONS				FREDDIE A. VARGAS, P.E. P.E. LICENSE NUMBER 35941 CARNAHAN PROCTOR & CROSS, INC. 814 S. MILITARY TRAIL DEERFIELD BEACH, FL 33442 CERTIFICATE OF AUTHORIZATION 2936	STATE OF FLORIDA DEPARTMENT OF TRANSPORTATION			<i>PEDESTRIAN LIGHTING-CONDUIT          PLANS</i>	SHEET NO.  L-17
DATE	DESCRIPTION	DATE	DESCRIPTION		ROAD NO.	COUNTY	FINANCIAL PROJECT ID		
---	---	---	---		BROWARD	436319-1-52-03			

Terence Castillo

6/4/2019 11:22:21 AM

P:\projects\181201 - Pedestrian Light Features\43631915201\PLANL101.dwg

THE OFFICIAL RECORD OF THIS SHEET IS THE ELECTRONIC FILE DIGITALLY SIGNED AND SEALED UNDER RULE 61G15-23.004, F.A.C.

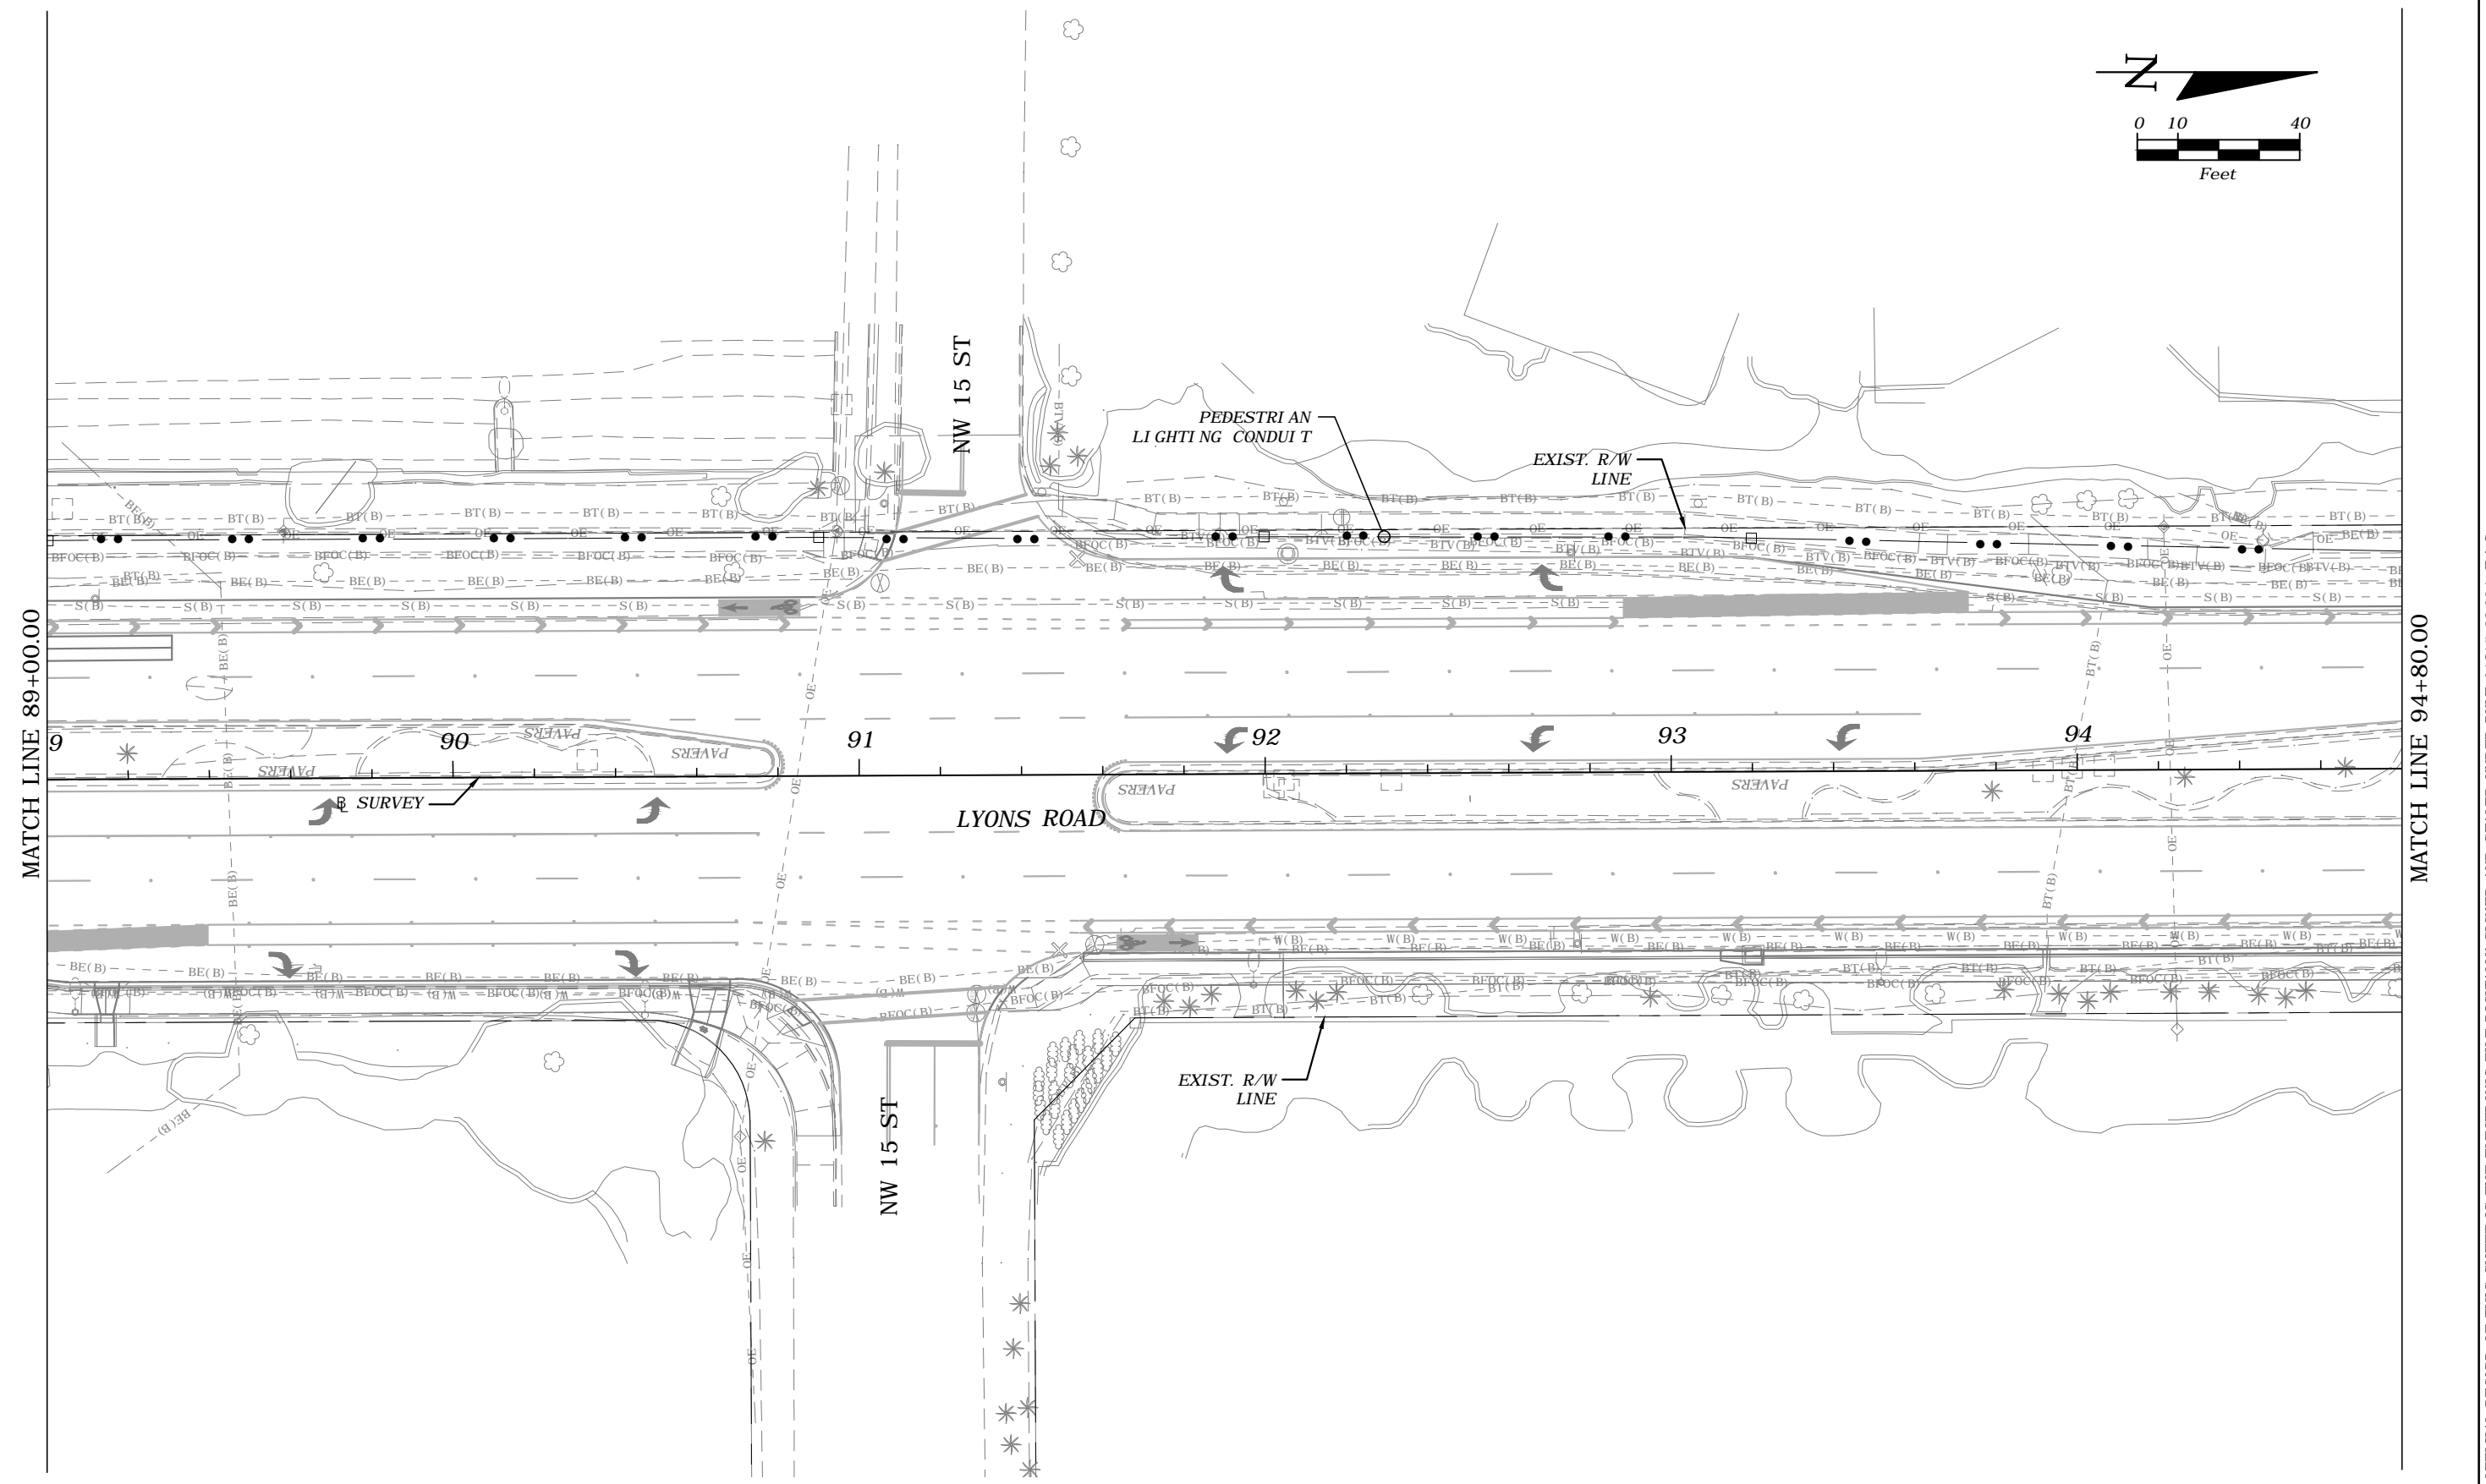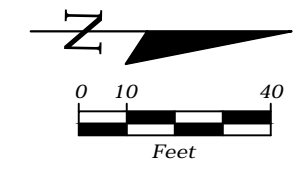

REVISIONS			
DATE	DESCRIPTION	DATE	DESCRIPTION
---	---	---	---



FREDDIE A. VARGAS, P.E.  
 P.E. LICENSE NUMBER 35941  
 CARNAHAN PROCTOR & CROSS, INC.  
 814 S. MILITARY TRAIL  
 DEERFIELD BEACH, FL 33442  
 CERTIFICATE OF AUTHORIZATION 2936

STATE OF FLORIDA DEPARTMENT OF TRANSPORTATION		
ROAD NO.	COUNTY	FINANCIAL PROJECT ID
	BROWARD	436319-1-52-03

*PEDESTRIAN LIGHTING-CONDUIT  
 PLANS*

SHEET NO.  
 L-18



THE OFFICIAL RECORD OF THIS SHEET IS THE ELECTRONIC FILE DIGITALLY SIGNED AND SEALED UNDER RULE 61G15-23.004, F.A.C.

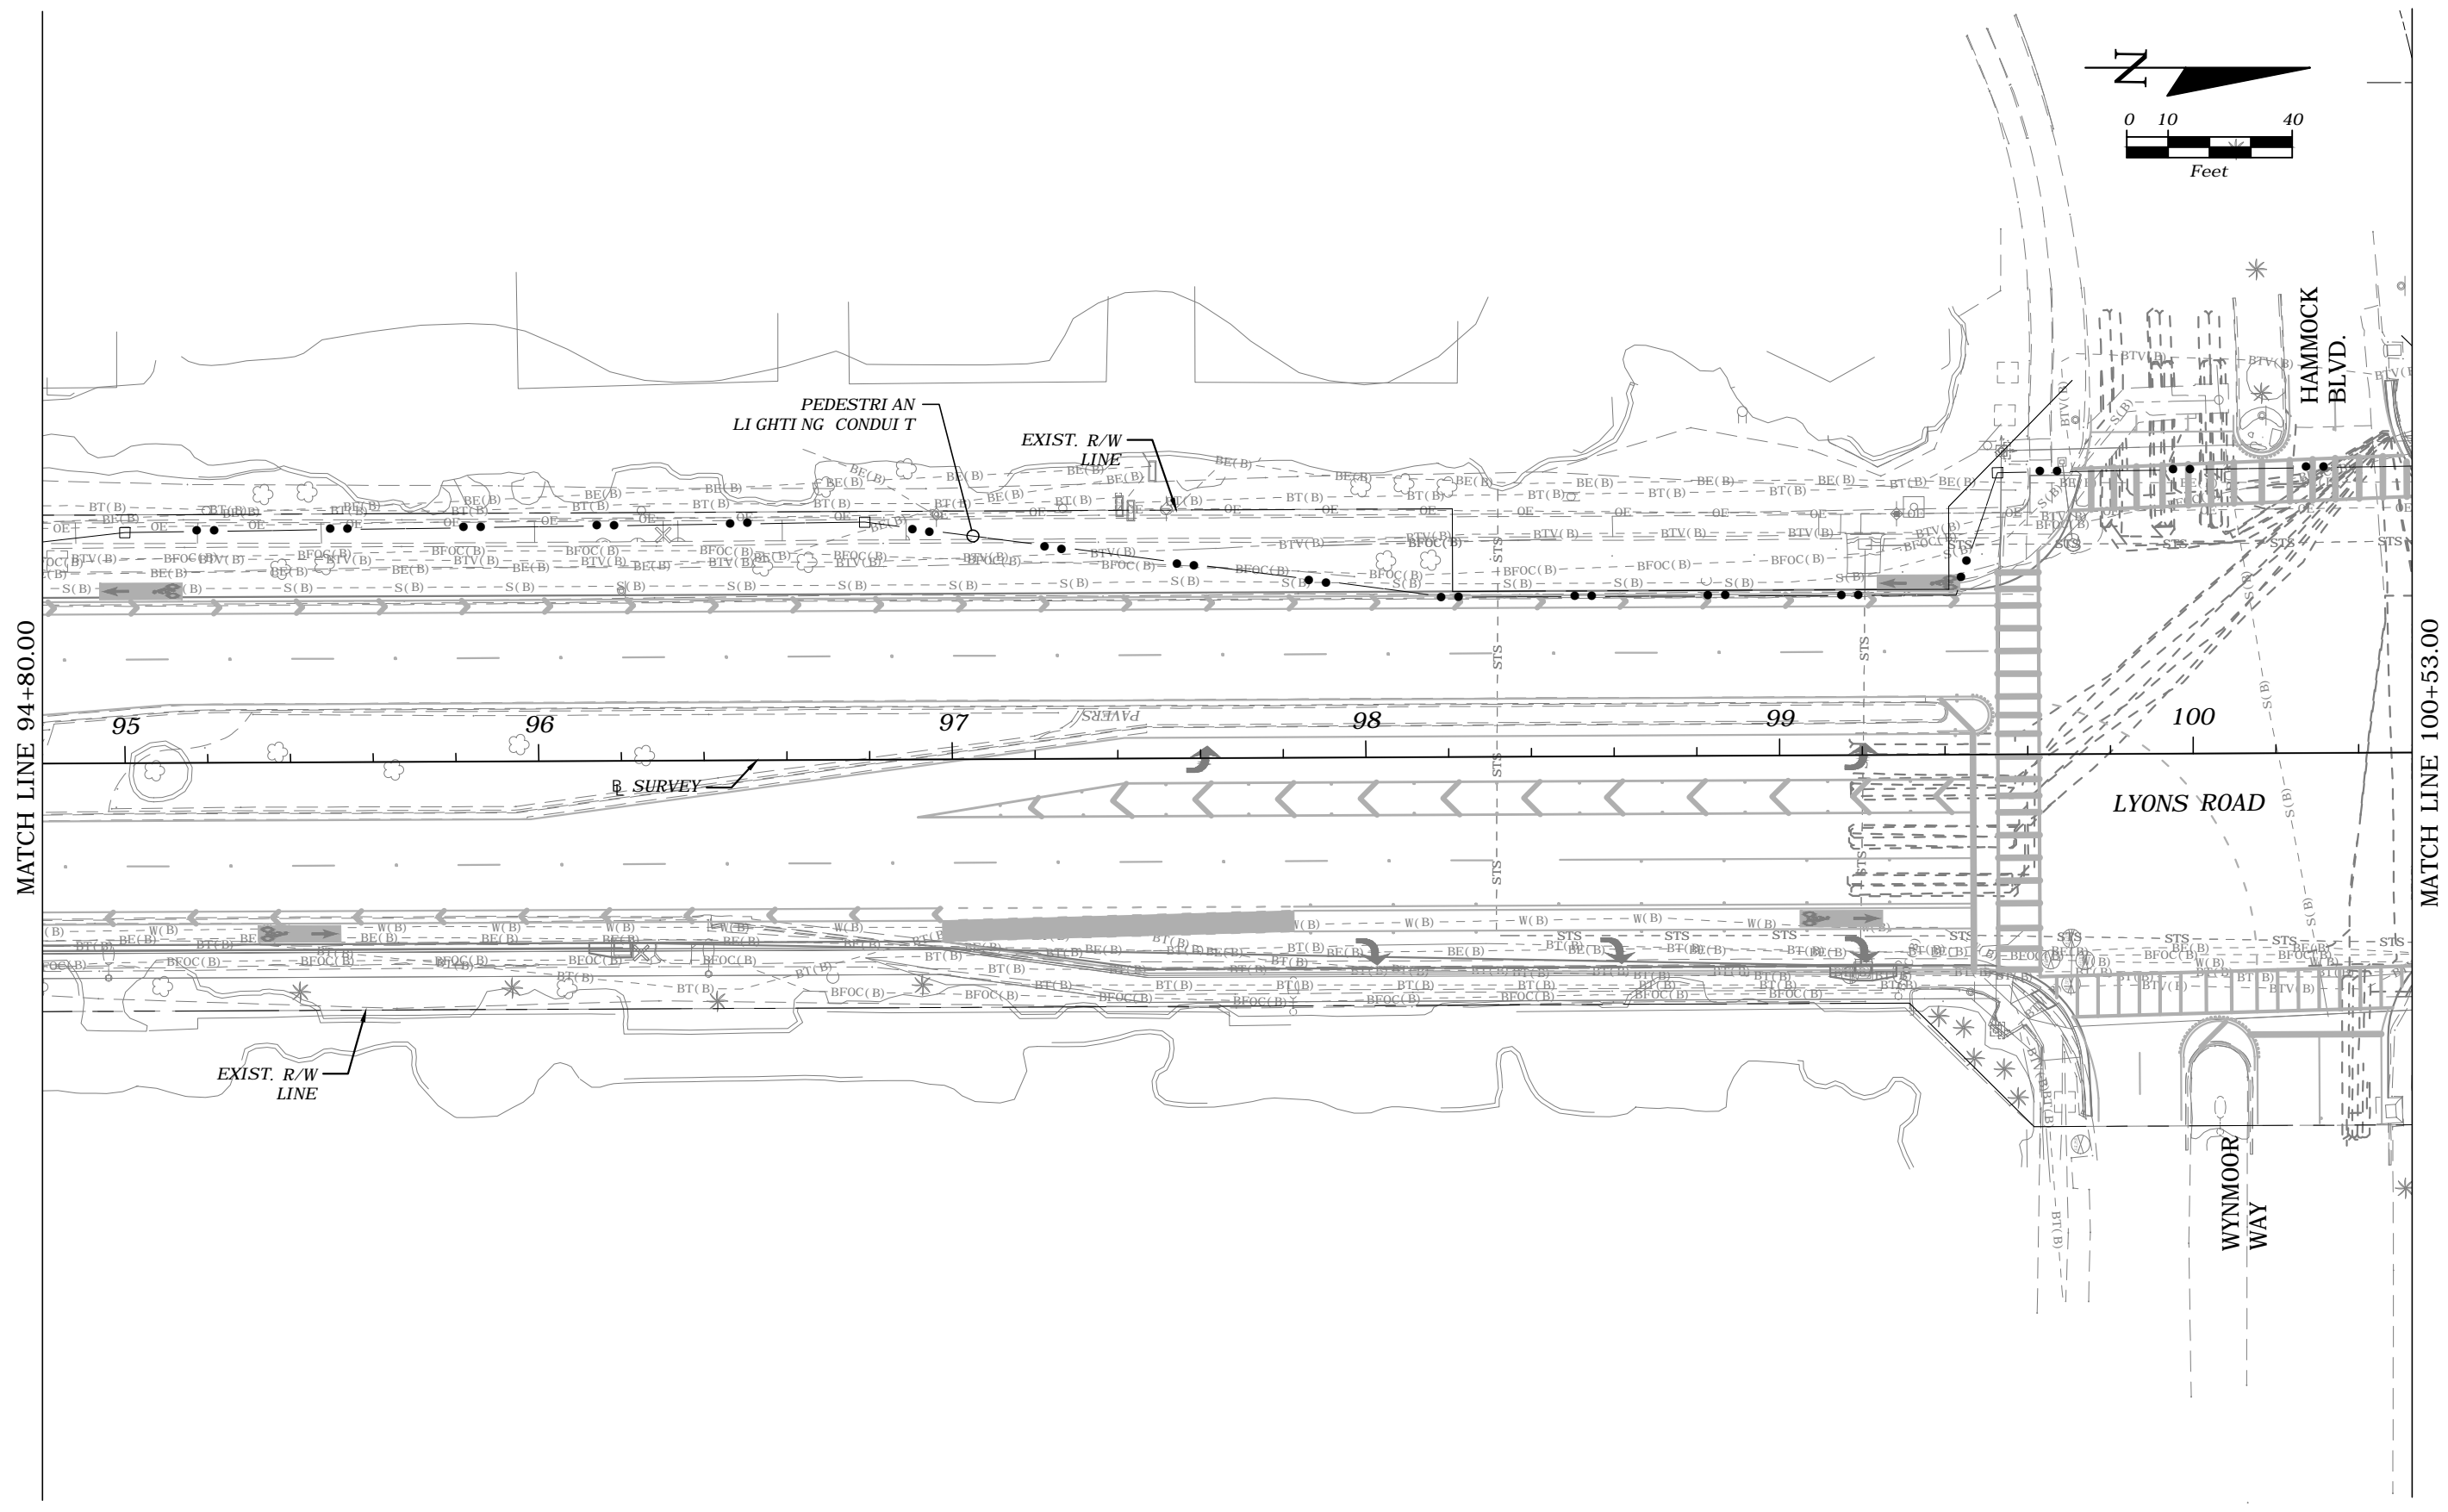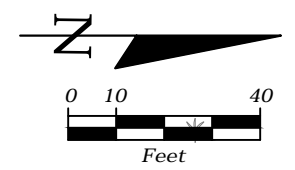

MATCH LINE 94+80.00

MATCH LINE 100+53.00

REVISIONS				FREDDIE A. VARGAS, P.E. P.E. LICENSE NUMBER 35941 CARNAHAN PROCTOR & CROSS, INC. 814 S. MILITARY TRAIL DEERFIELD BEACH, FL 33442 CERTIFICATE OF AUTHORIZATION 2936	STATE OF FLORIDA DEPARTMENT OF TRANSPORTATION			<i>PEDESTRIAN LIGHTING-CONDUIT          PLANS</i>	SHEET NO.  L-19
DATE	DESCRIPTION	DATE	DESCRIPTION		ROAD NO.	COUNTY	FINANCIAL PROJECT ID		
---	---	---	---		BROWARD	436319-1-52-03			

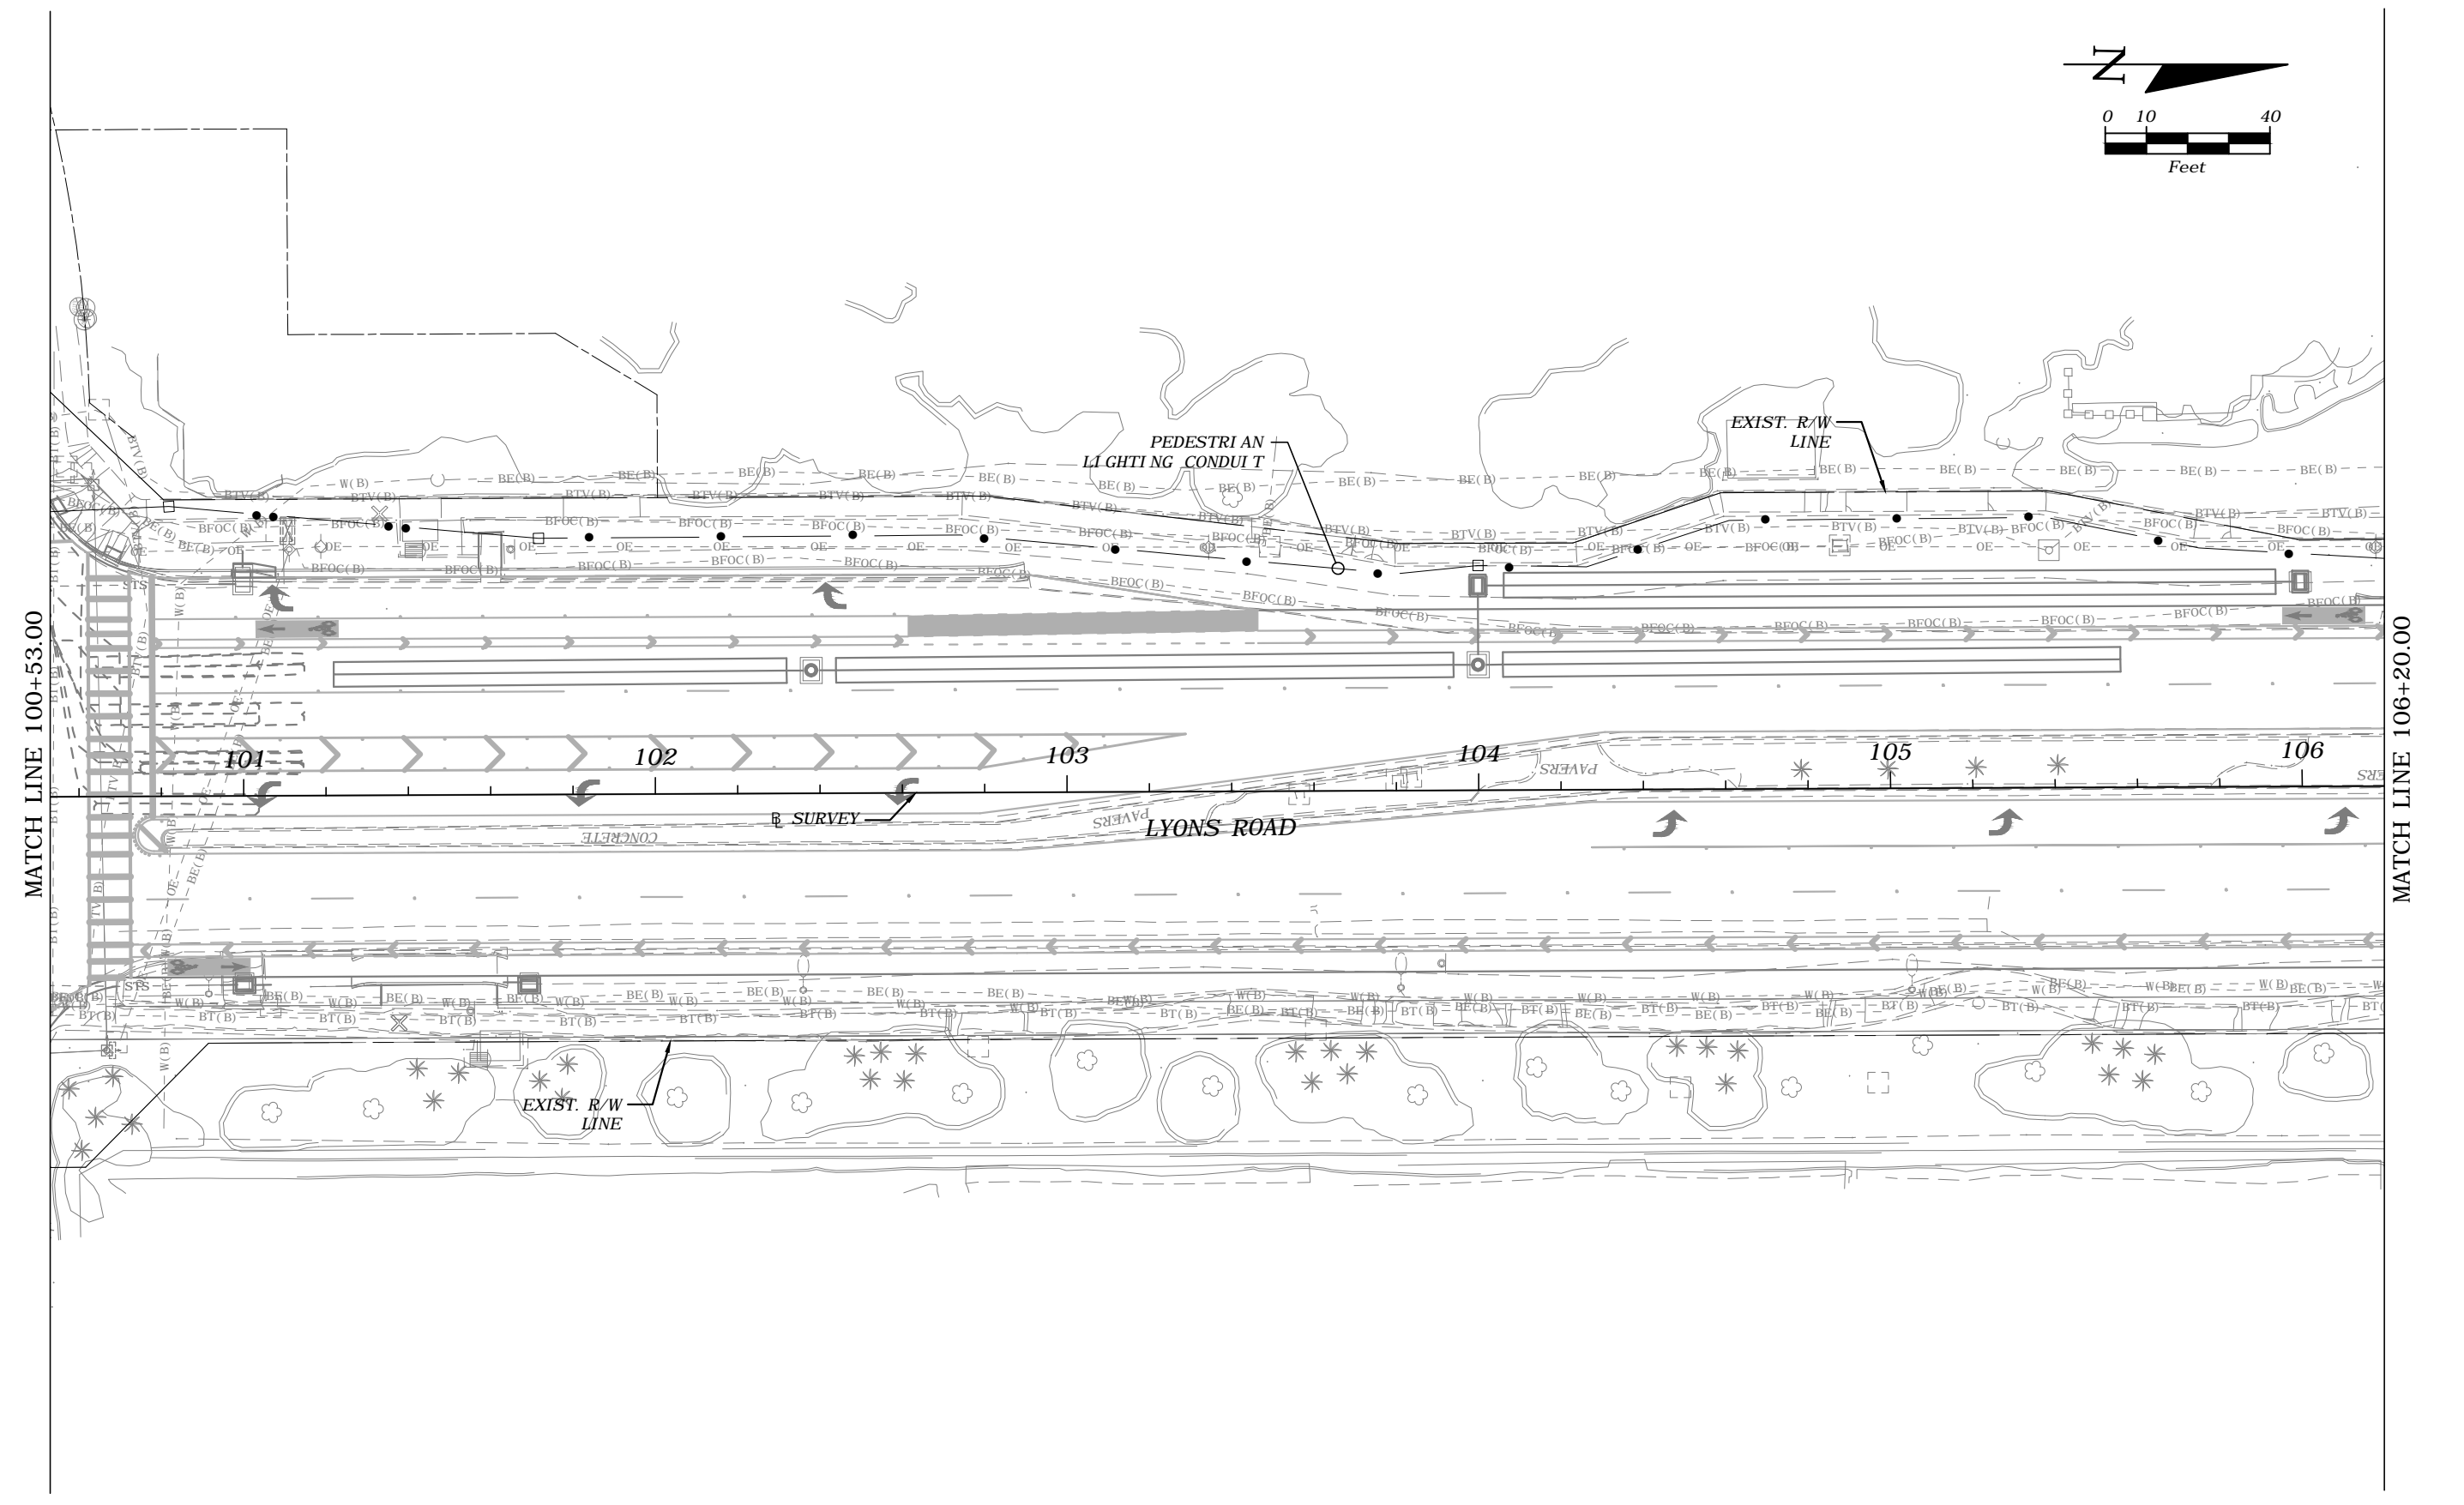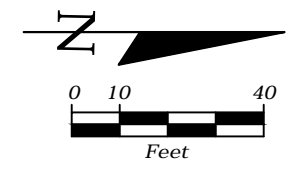

MATCH LINE 100+53.00

MATCH LINE 106+20.00

REVISIONS			
DATE	DESCRIPTION	DATE	DESCRIPTION
---	---	---	---



FREDDIE A. VARGAS, P.E.  
 P.E. LICENSE NUMBER 35941  
 CARNAHAN PROCTOR & CROSS, INC.  
 814 S. MILITARY TRAIL  
 DEERFIELD BEACH, FL 33442  
 CERTIFICATE OF AUTHORIZATION 2936

<b>STATE OF FLORIDA</b> <b>DEPARTMENT OF TRANSPORTATION</b>		
ROAD NO.	COUNTY	FINANCIAL PROJECT ID
	BROWARD	436319-1-52-03

***PEDESTRIAN LIGHTING-CONDUIT***  
***PLANS***

SHEET NO.  
**L-20**

THE OFFICIAL RECORD OF THIS SHEET IS THE ELECTRONIC FILE DIGITALLY SIGNED AND SEALED UNDER RULE 61G15-23.004, F.A.C.

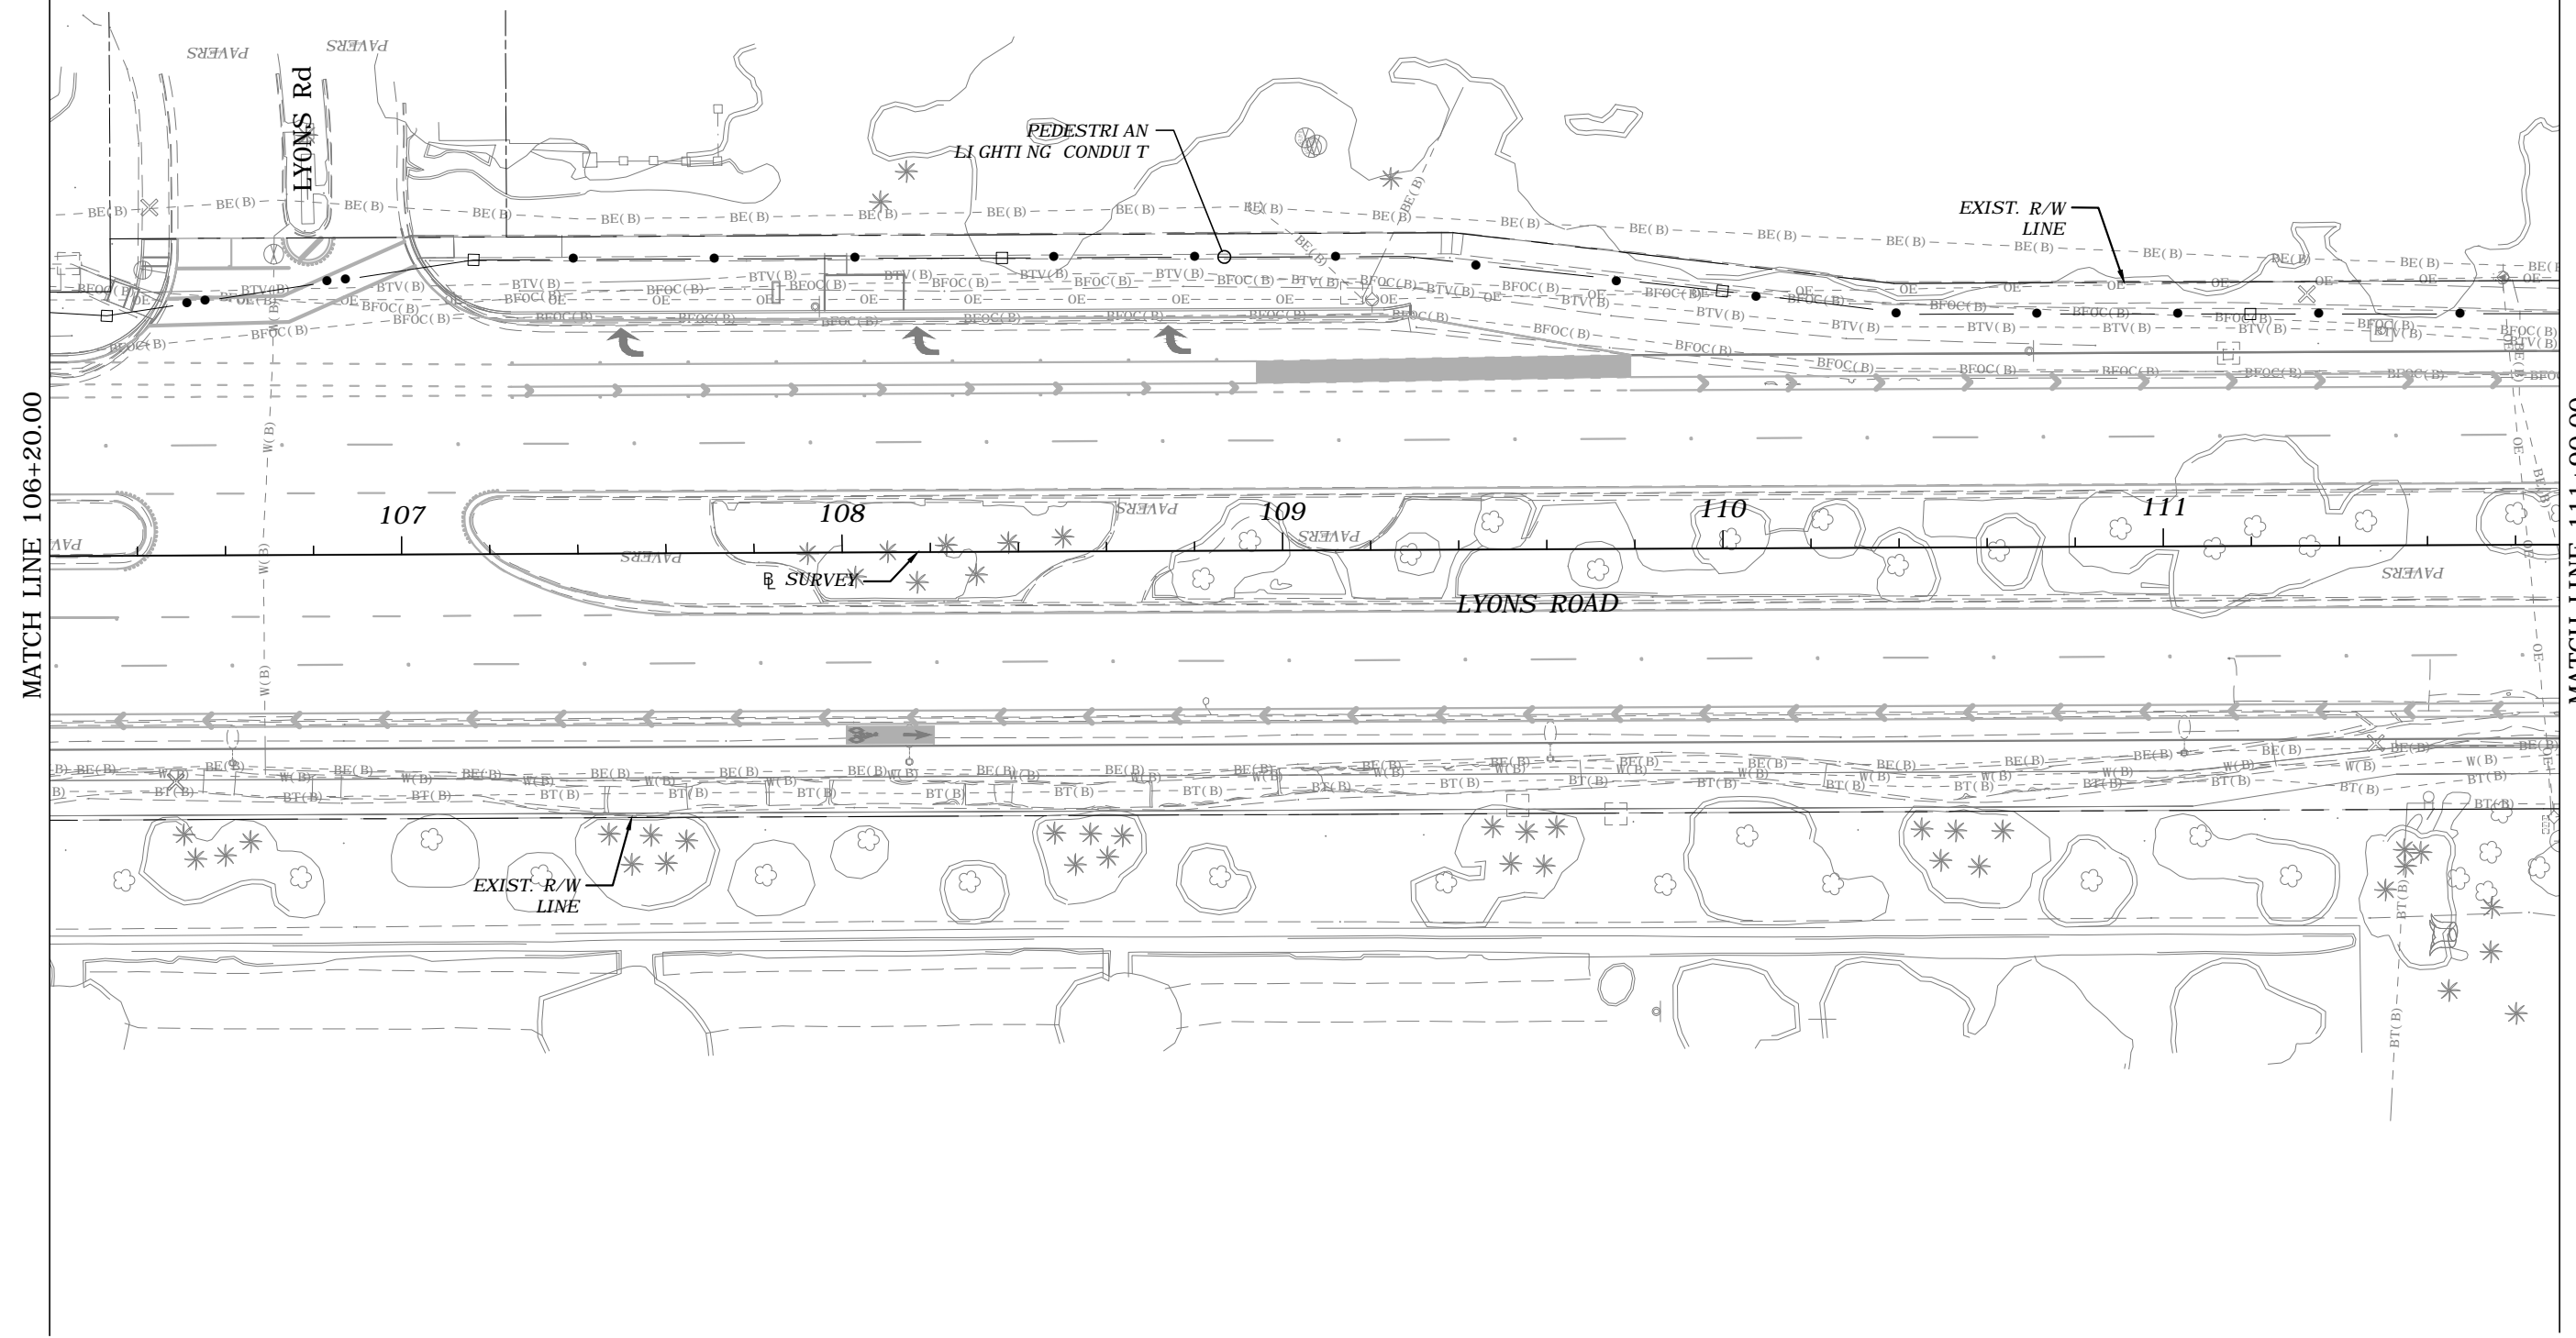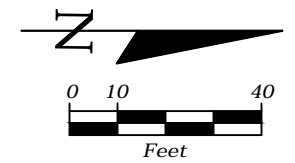



REVISIONS				FREDDIE A. VARGAS, P.E. P.E. LICENSE NUMBER 35941 CARNAHAN PROCTOR & CROSS, INC. 814 S. MILITARY TRAIL DEERFIELD BEACH, FL 33442 CERTIFICATE OF AUTHORIZATION 2936	STATE OF FLORIDA DEPARTMENT OF TRANSPORTATION		<i>PEDESTRIAN LIGHTING-CONDUIT PLANS</i>	SHEET NO.  L-21
DATE	DESCRIPTION	DATE	DESCRIPTION		ROAD NO.	COUNTY		
---	---				BROWARD	436319-1-52-03		

Terence Castillo

6/4/2019 11:23:21 AM

P:\projects\181201 - Pedestrian Light Features\43631915201\PLANL01.dwg

THE OFFICIAL RECORD OF THIS SHEET IS THE ELECTRONIC FILE DIGITALLY SIGNED AND SEALED UNDER RULE 61G15-23.004, F.A.C.

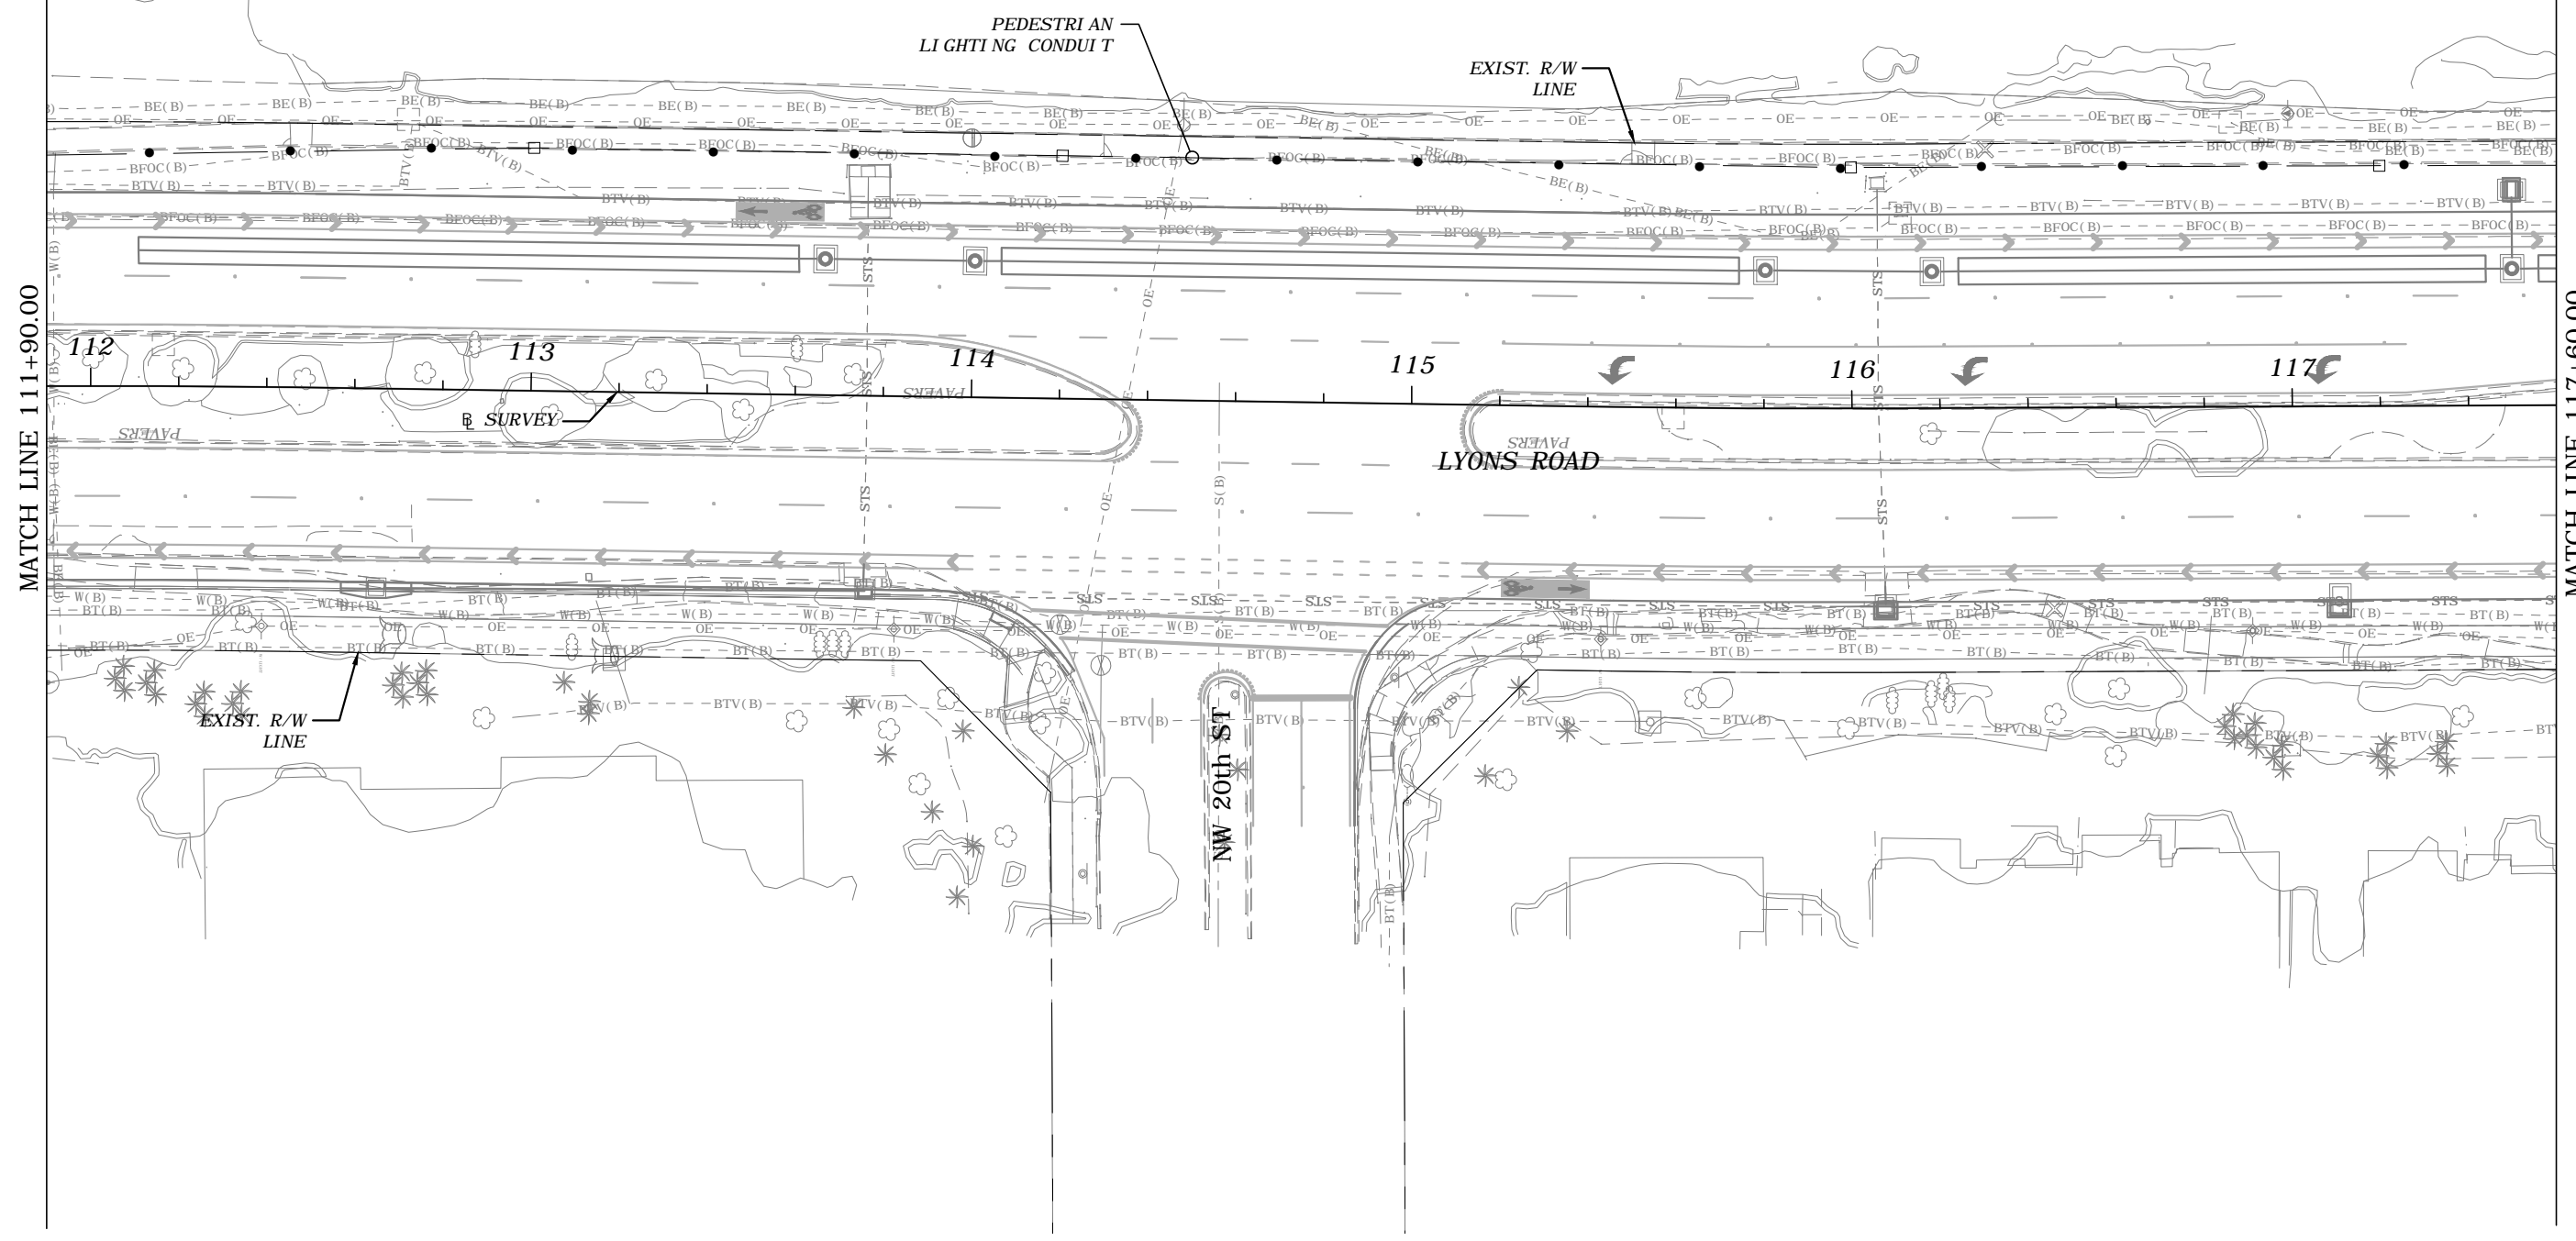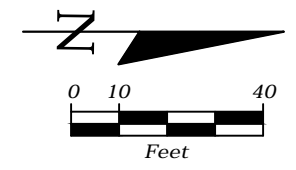

MATCH LINE 111+90.00

MATCH LINE 117+60.00

REVISIONS			
DATE	DESCRIPTION	DATE	DESCRIPTION
---	---	---	---



FREDDIE A. VARGAS, P.E.  
 P.E. LICENSE NUMBER 35941  
 CARNAHAN PROCTOR & CROSS, INC.  
 814 S. MILITARY TRAIL  
 DEERFIELD BEACH, FL 33442  
 CERTIFICATE OF AUTHORIZATION 2936

STATE OF FLORIDA DEPARTMENT OF TRANSPORTATION		
ROAD NO.	COUNTY	FINANCIAL PROJECT ID
	BROWARD	436319-1-52-03

*PEDESTRIAN LIGHTING-CONDUIT  
 PLANS*

SHEET NO.  
L-22



THE OFFICIAL RECORD OF THIS SHEET IS THE ELECTRONIC FILE DIGITALLY SIGNED AND SEALED UNDER RULE 61G15-23.004, F.A.C.

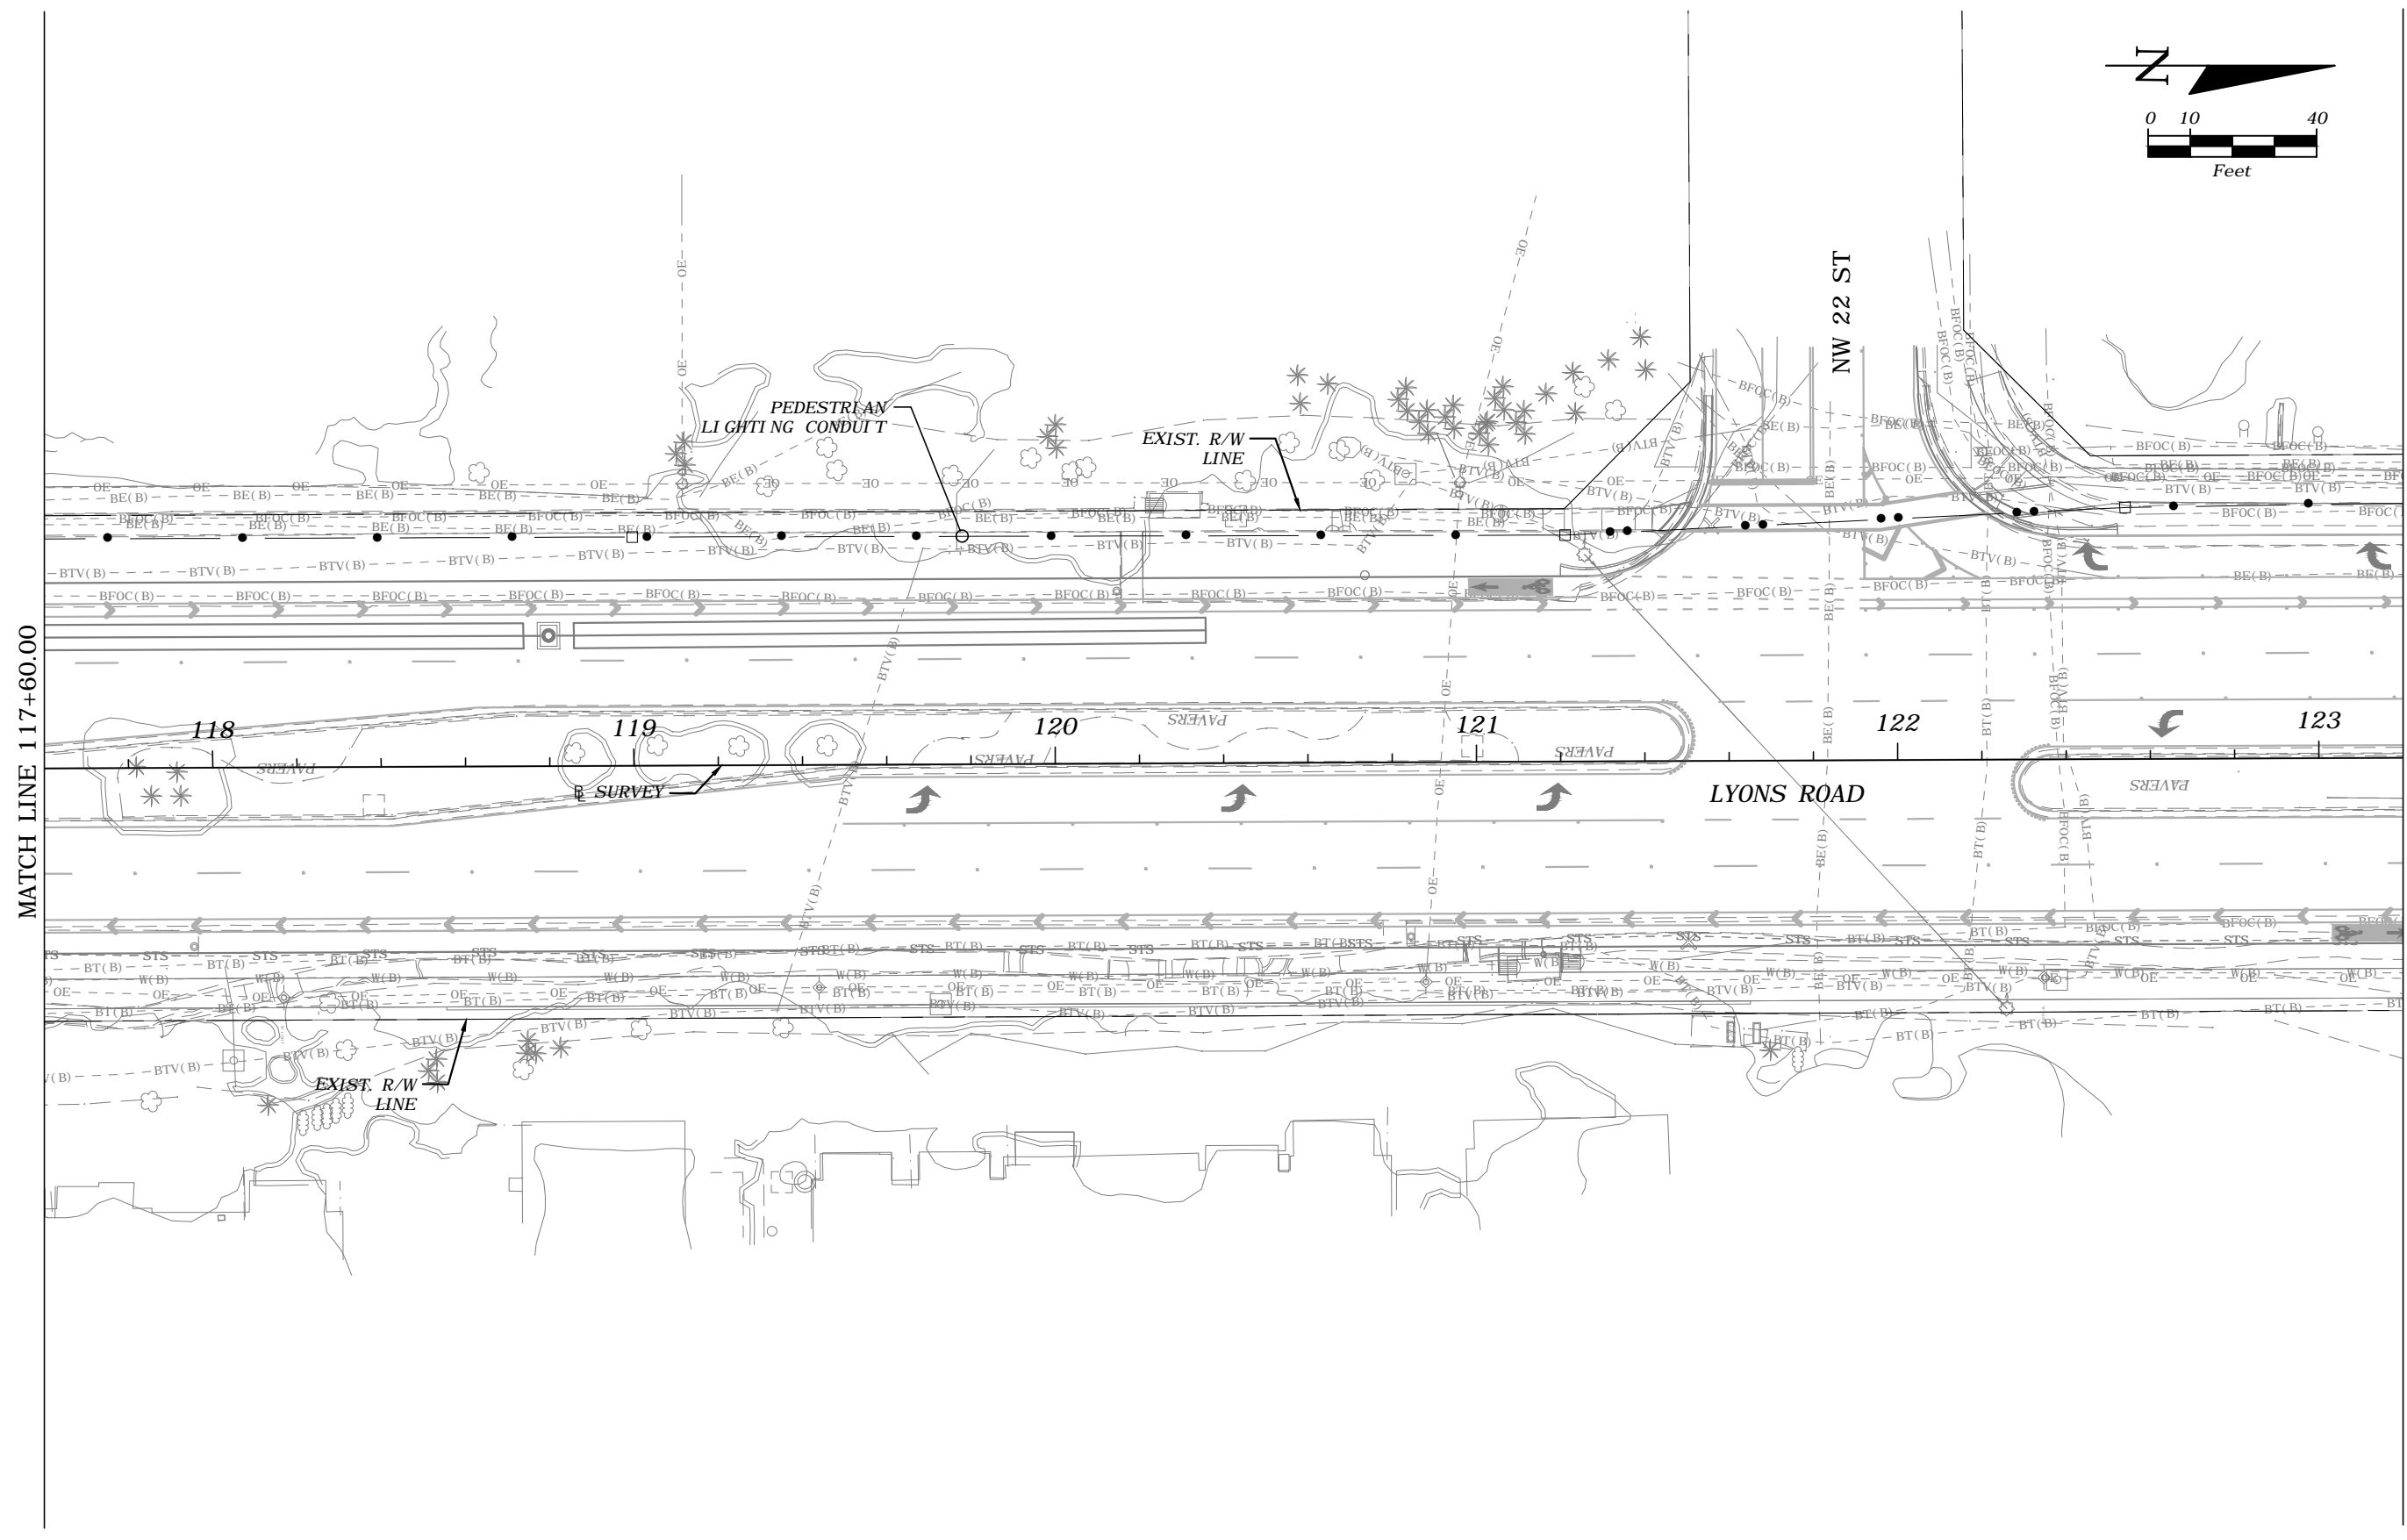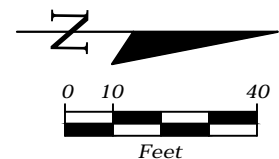

MATCH LINE 117+60.00

MATCH LINE 123+20.00

REVISIONS				FREDDIE A. VARGAS, P.E. P.E. LICENSE NUMBER 35941 CARNAHAN PROCTOR & CROSS, INC. 814 S. MILITARY TRAIL DEERFIELD BEACH, FL 33442 CERTIFICATE OF AUTHORIZATION 2936	STATE OF FLORIDA DEPARTMENT OF TRANSPORTATION		<i>PEDESTRIAN LIGHTING-CONDUIT PLANS</i>	SHEET NO.
DATE	DESCRIPTION	DATE	DESCRIPTION		ROAD NO.	COUNTY		FINANCIAL PROJECT ID
---	---	---	---		BROWARD	436319-1-52-03		

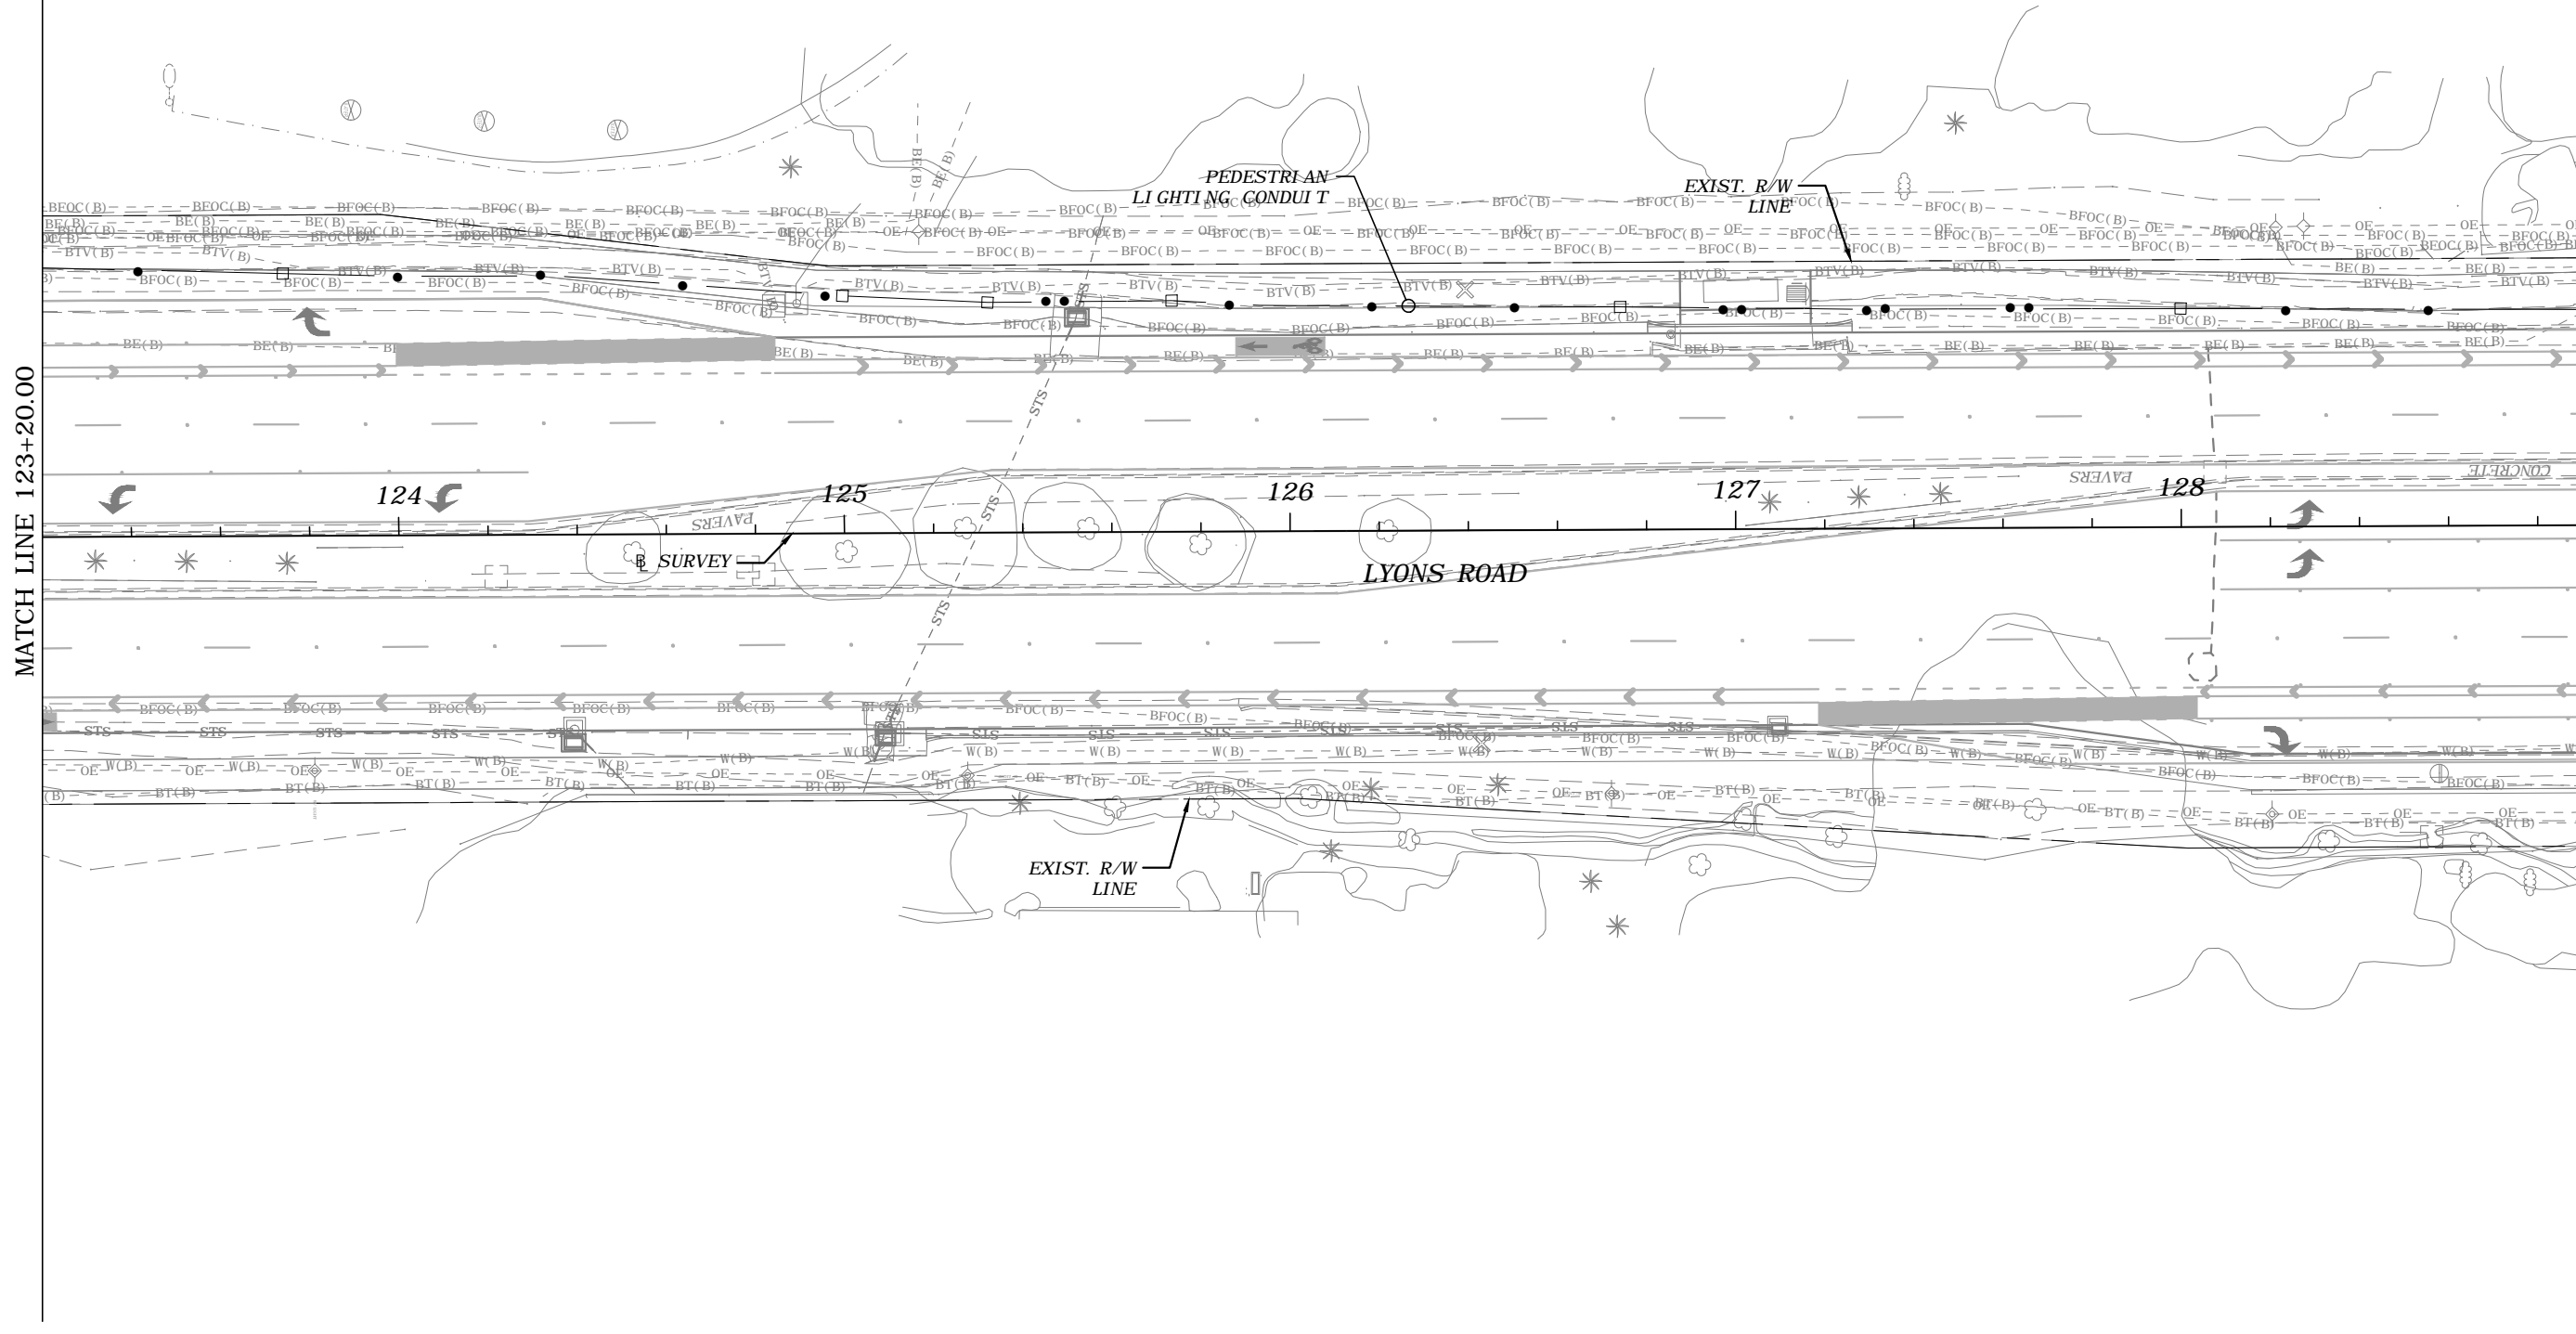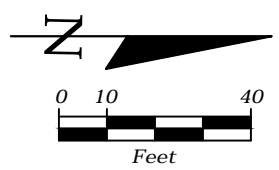

REVISIONS			
DATE	DESCRIPTION	DATE	DESCRIPTION
---	---	---	---

FREDDIE A. VARGAS, P.E.  
 P.E. LICENSE NUMBER 35941  
 CARNAHAN PROCTOR & CROSS, INC.  
 814 S. MILITARY TRAIL  
 DEERFIELD BEACH, FL 33442  
 CERTIFICATE OF AUTHORIZATION 2936



STATE OF FLORIDA DEPARTMENT OF TRANSPORTATION		
ROAD NO.	COUNTY	FINANCIAL PROJECT ID
	BROWARD	436319-1-52-03

*PEDESTRIAN LIGHTING-CONDUIT  
 PLANS*

SHEET NO.  
L-24

THE OFFICIAL RECORD OF THIS SHEET IS THE ELECTRONIC FILE DIGITALLY SIGNED AND SEALED UNDER RULE 61G15-23.004, F.A.C.



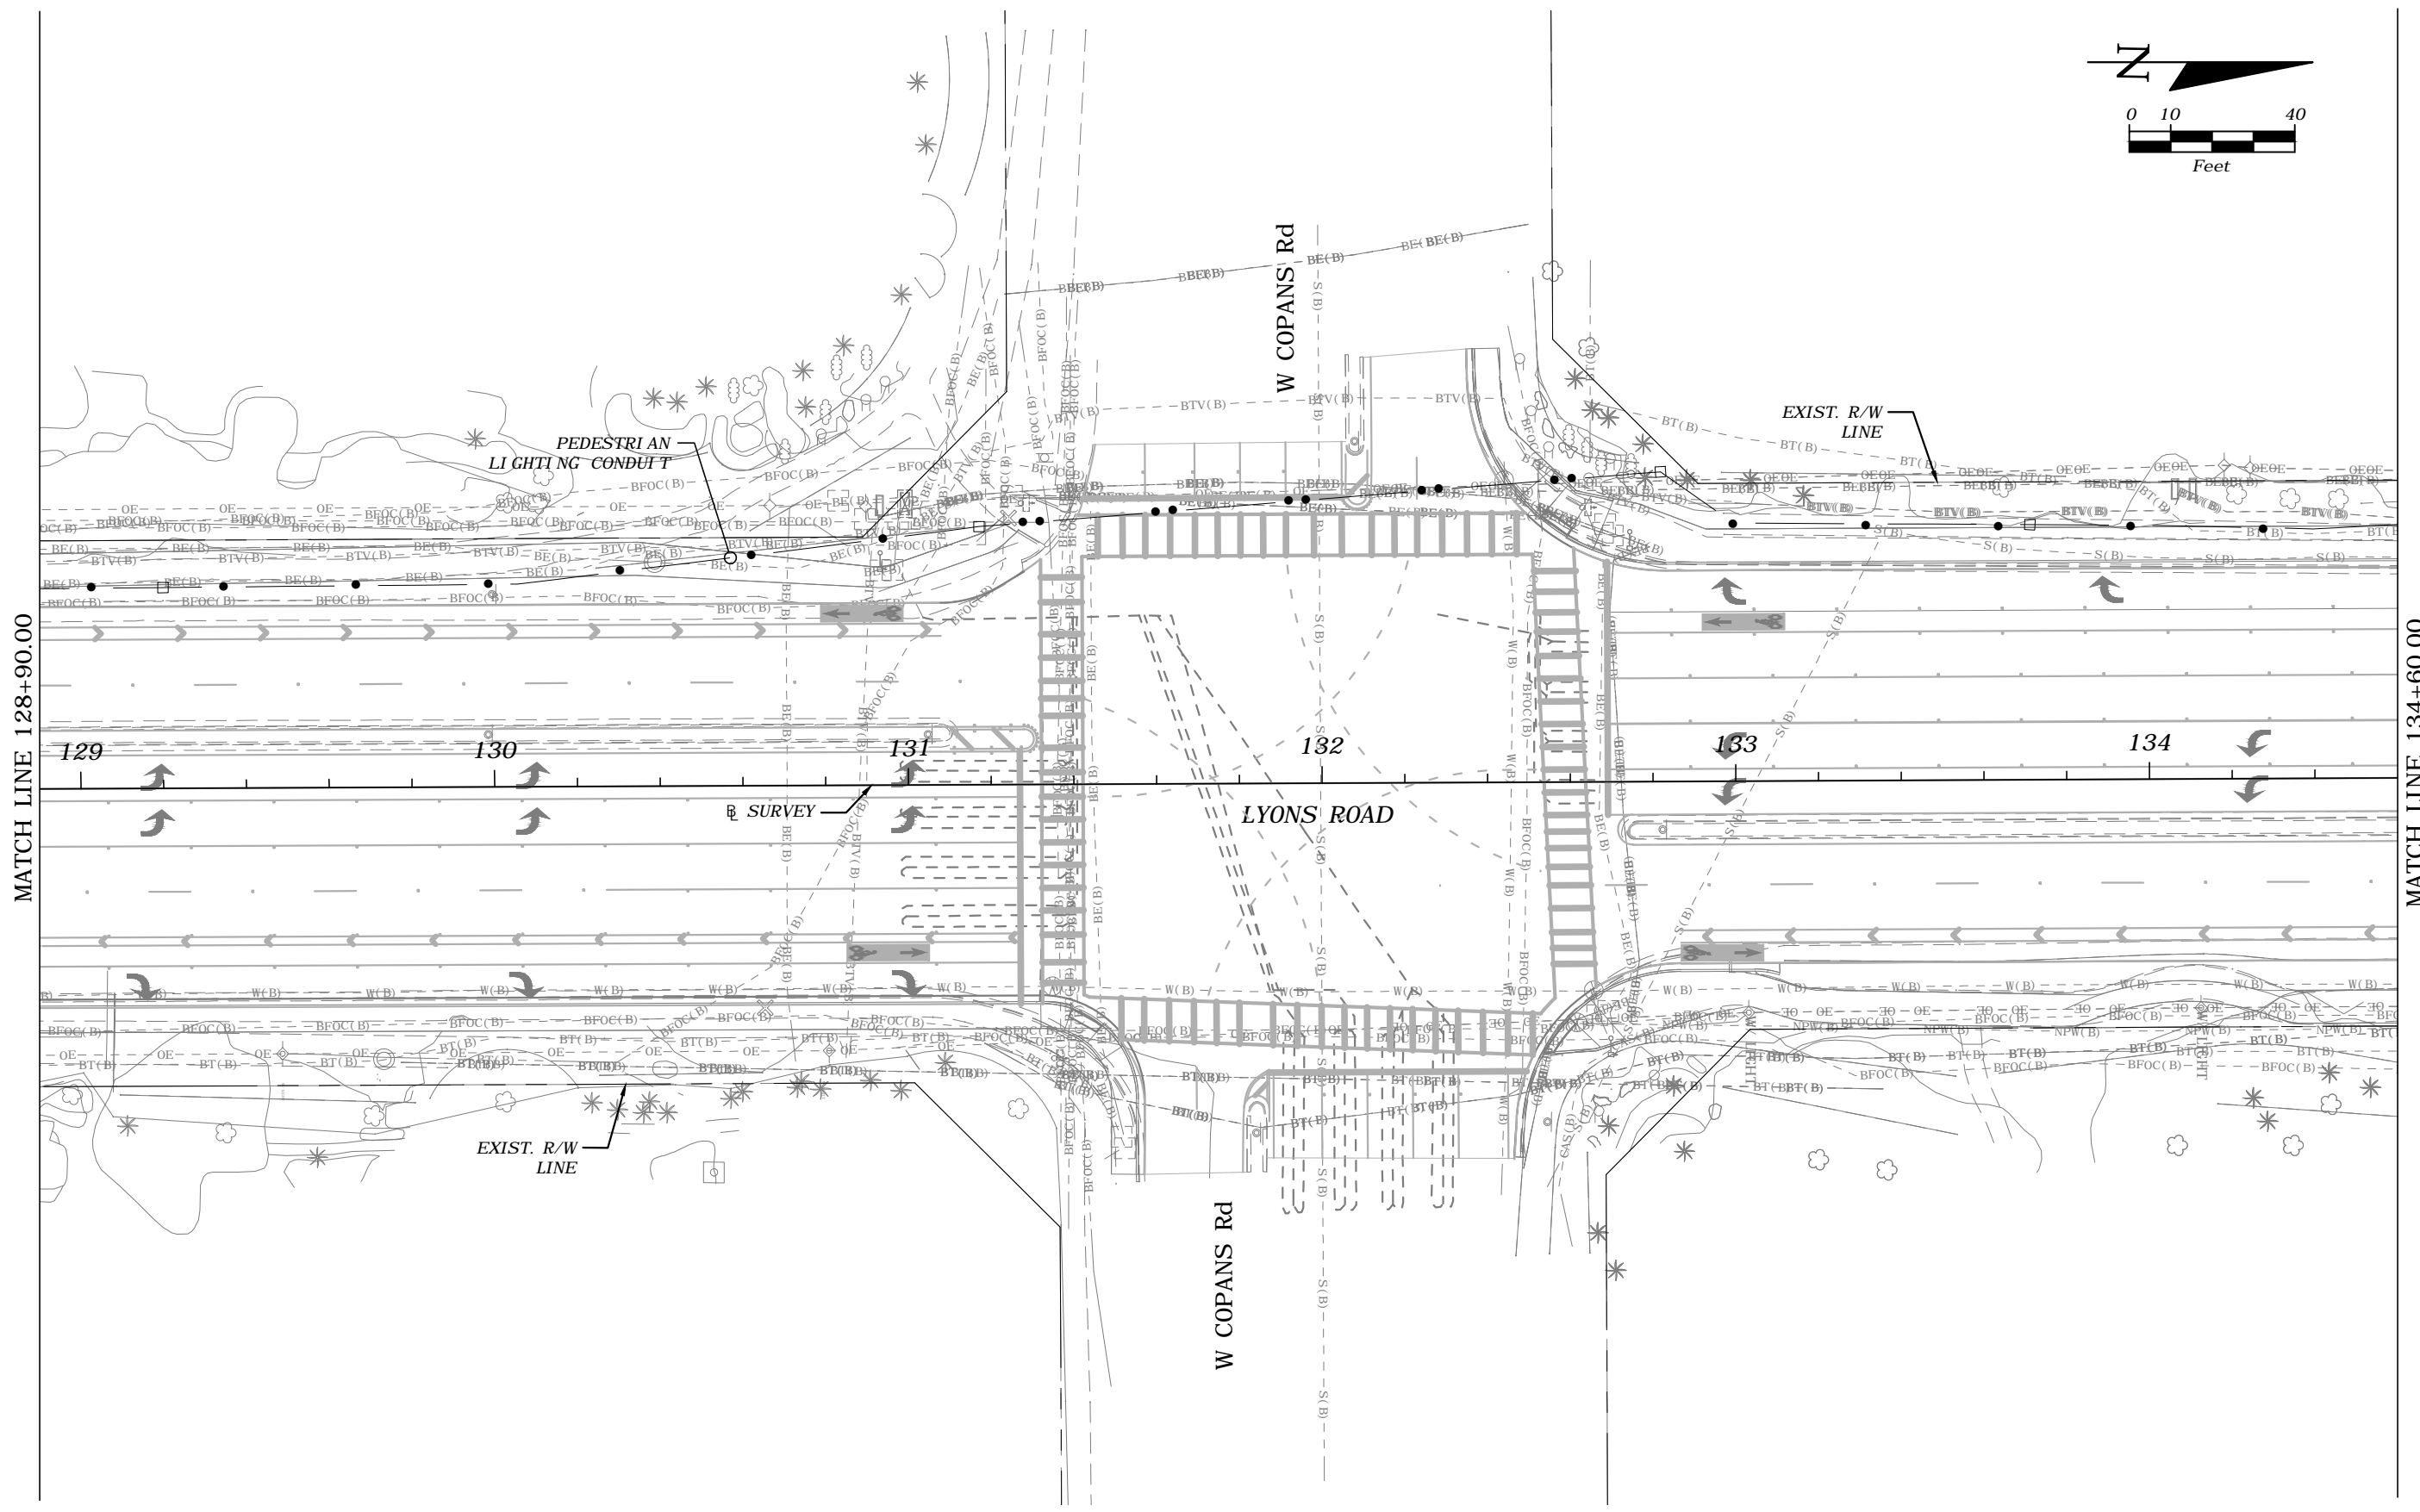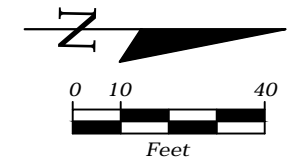



REVISIONS				FREDDIE A. VARGAS, P.E. P.E. LICENSE NUMBER 35941 CARNAHAN PROCTOR & CROSS, INC. 814 S. MILITARY TRAIL DEERFIELD BEACH, FL 33442 CERTIFICATE OF AUTHORIZATION 2936	STATE OF FLORIDA DEPARTMENT OF TRANSPORTATION		<i>PEDESTRIAN LIGHTING-CONDUIT PLANS</i>	SHEET NO.
DATE	DESCRIPTION	DATE	DESCRIPTION		ROAD NO.	COUNTY		FINANCIAL PROJECT ID
---	---	---	---		BROWARD	436319-1-52-03		

Terence Castillo

6/4/2019 11:24:42 AM

P:\projects\181201 - Pedestrian Light Features\43631915201\PLANL101.dwg

THE OFFICIAL RECORD OF THIS SHEET IS THE ELECTRONIC FILE DIGITALLY SIGNED AND SEALED UNDER RULE 61G15-23.004, F.A.C.

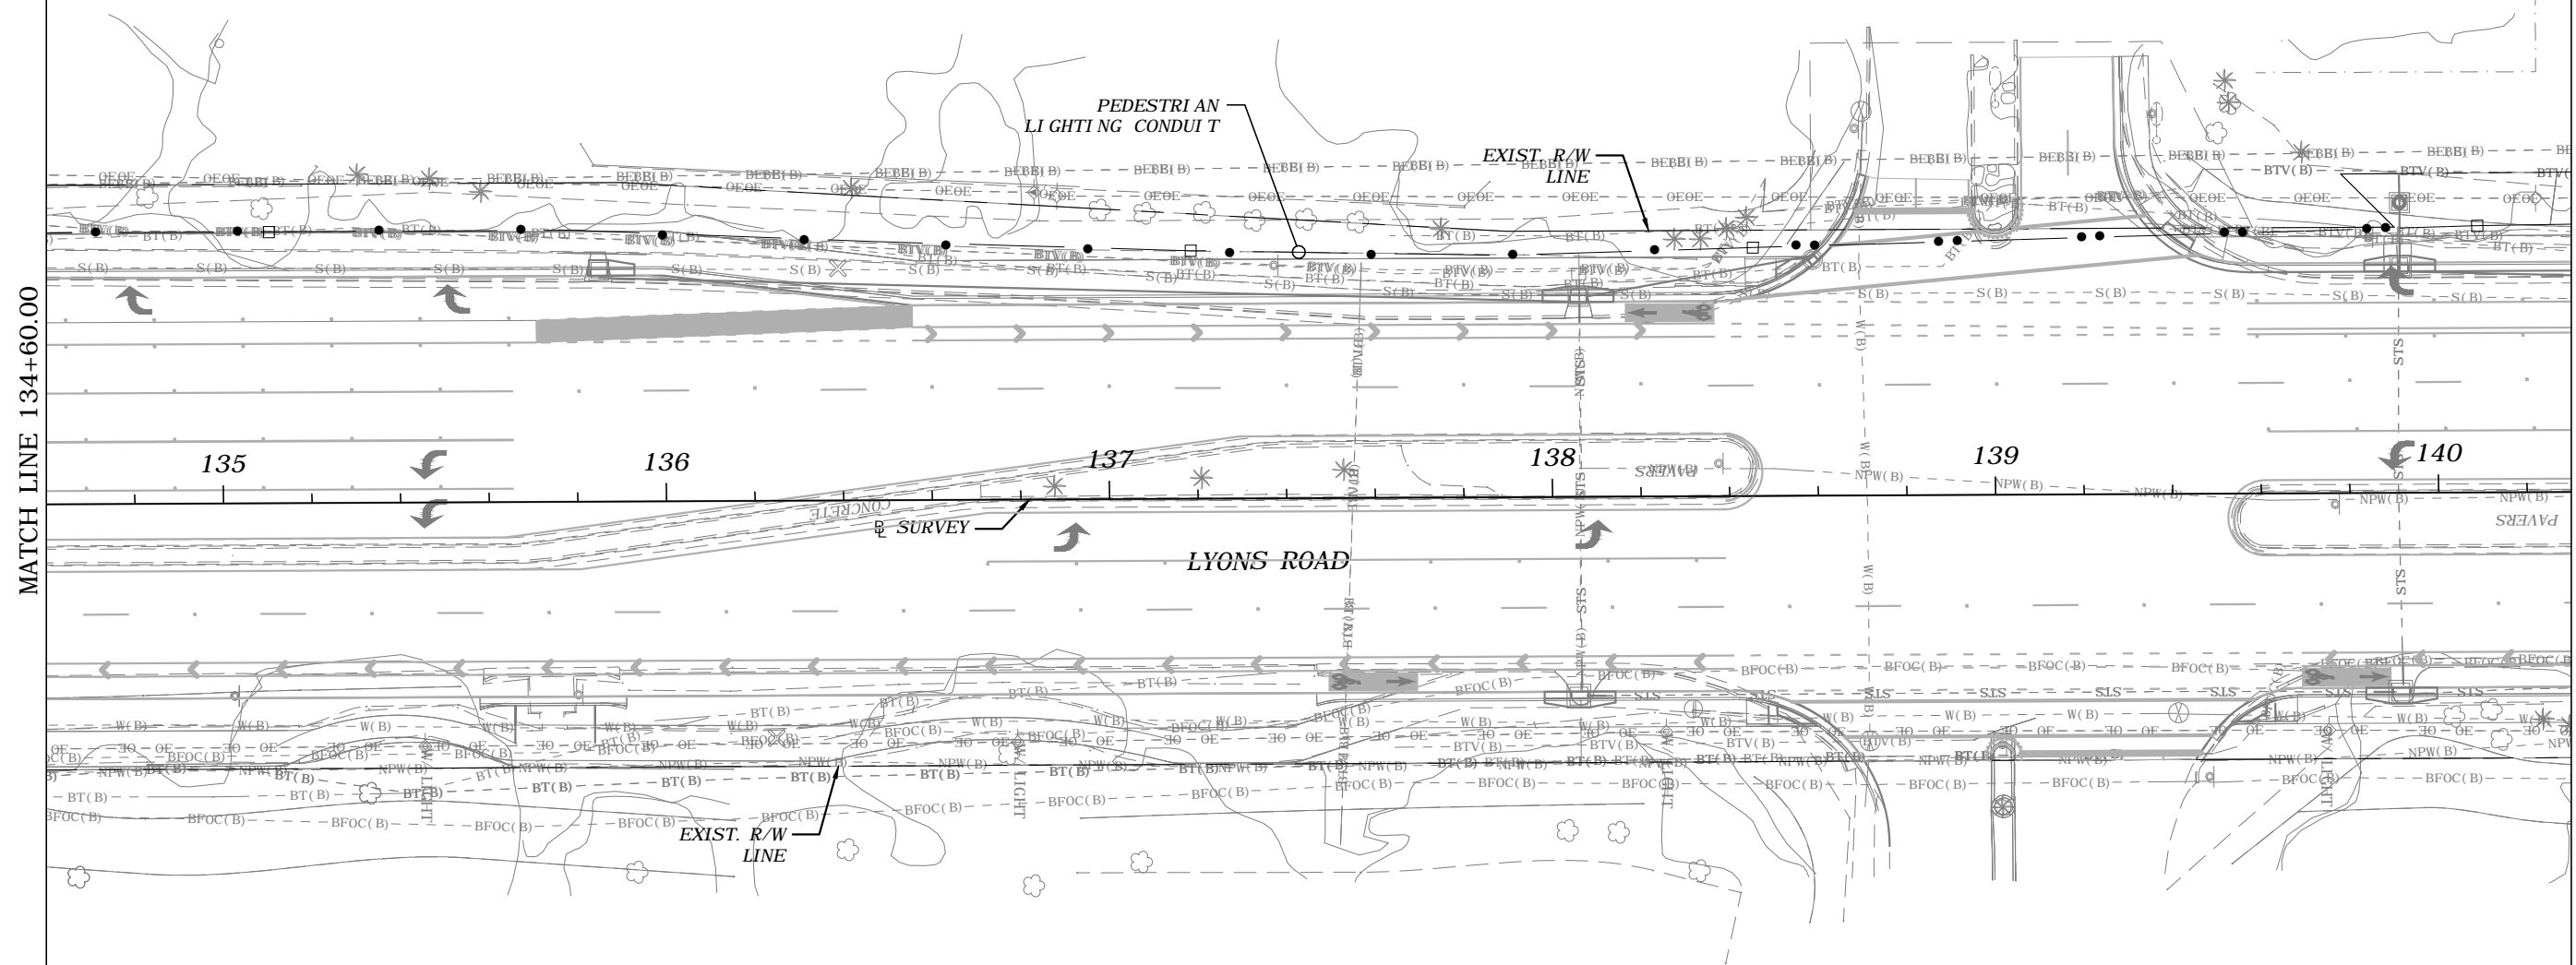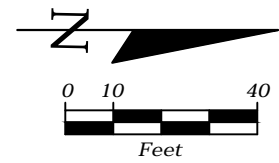

MATCH LINE 134+60.00

MATCH LINE 140+30.00



REVISIONS			
DATE	DESCRIPTION	DATE	DESCRIPTION
---	---	---	---

FREDDIE A. VARGAS, P.E.  
 P.E. LICENSE NUMBER 35941  
 CARNAHAN PROCTOR & CROSS, INC.  
 814 S. MILITARY TRAIL  
 DEERFIELD BEACH, FL 33442  
 CERTIFICATE OF AUTHORIZATION 2936

<b>STATE OF FLORIDA</b> <b>DEPARTMENT OF TRANSPORTATION</b>		
ROAD NO.	COUNTY	FINANCIAL PROJECT ID
	BROWARD	436319-1-52-03

***PEDESTRIAN LIGHTING-CONDUIT***  
***PLANS***



SHEET NO.  
**L-26**

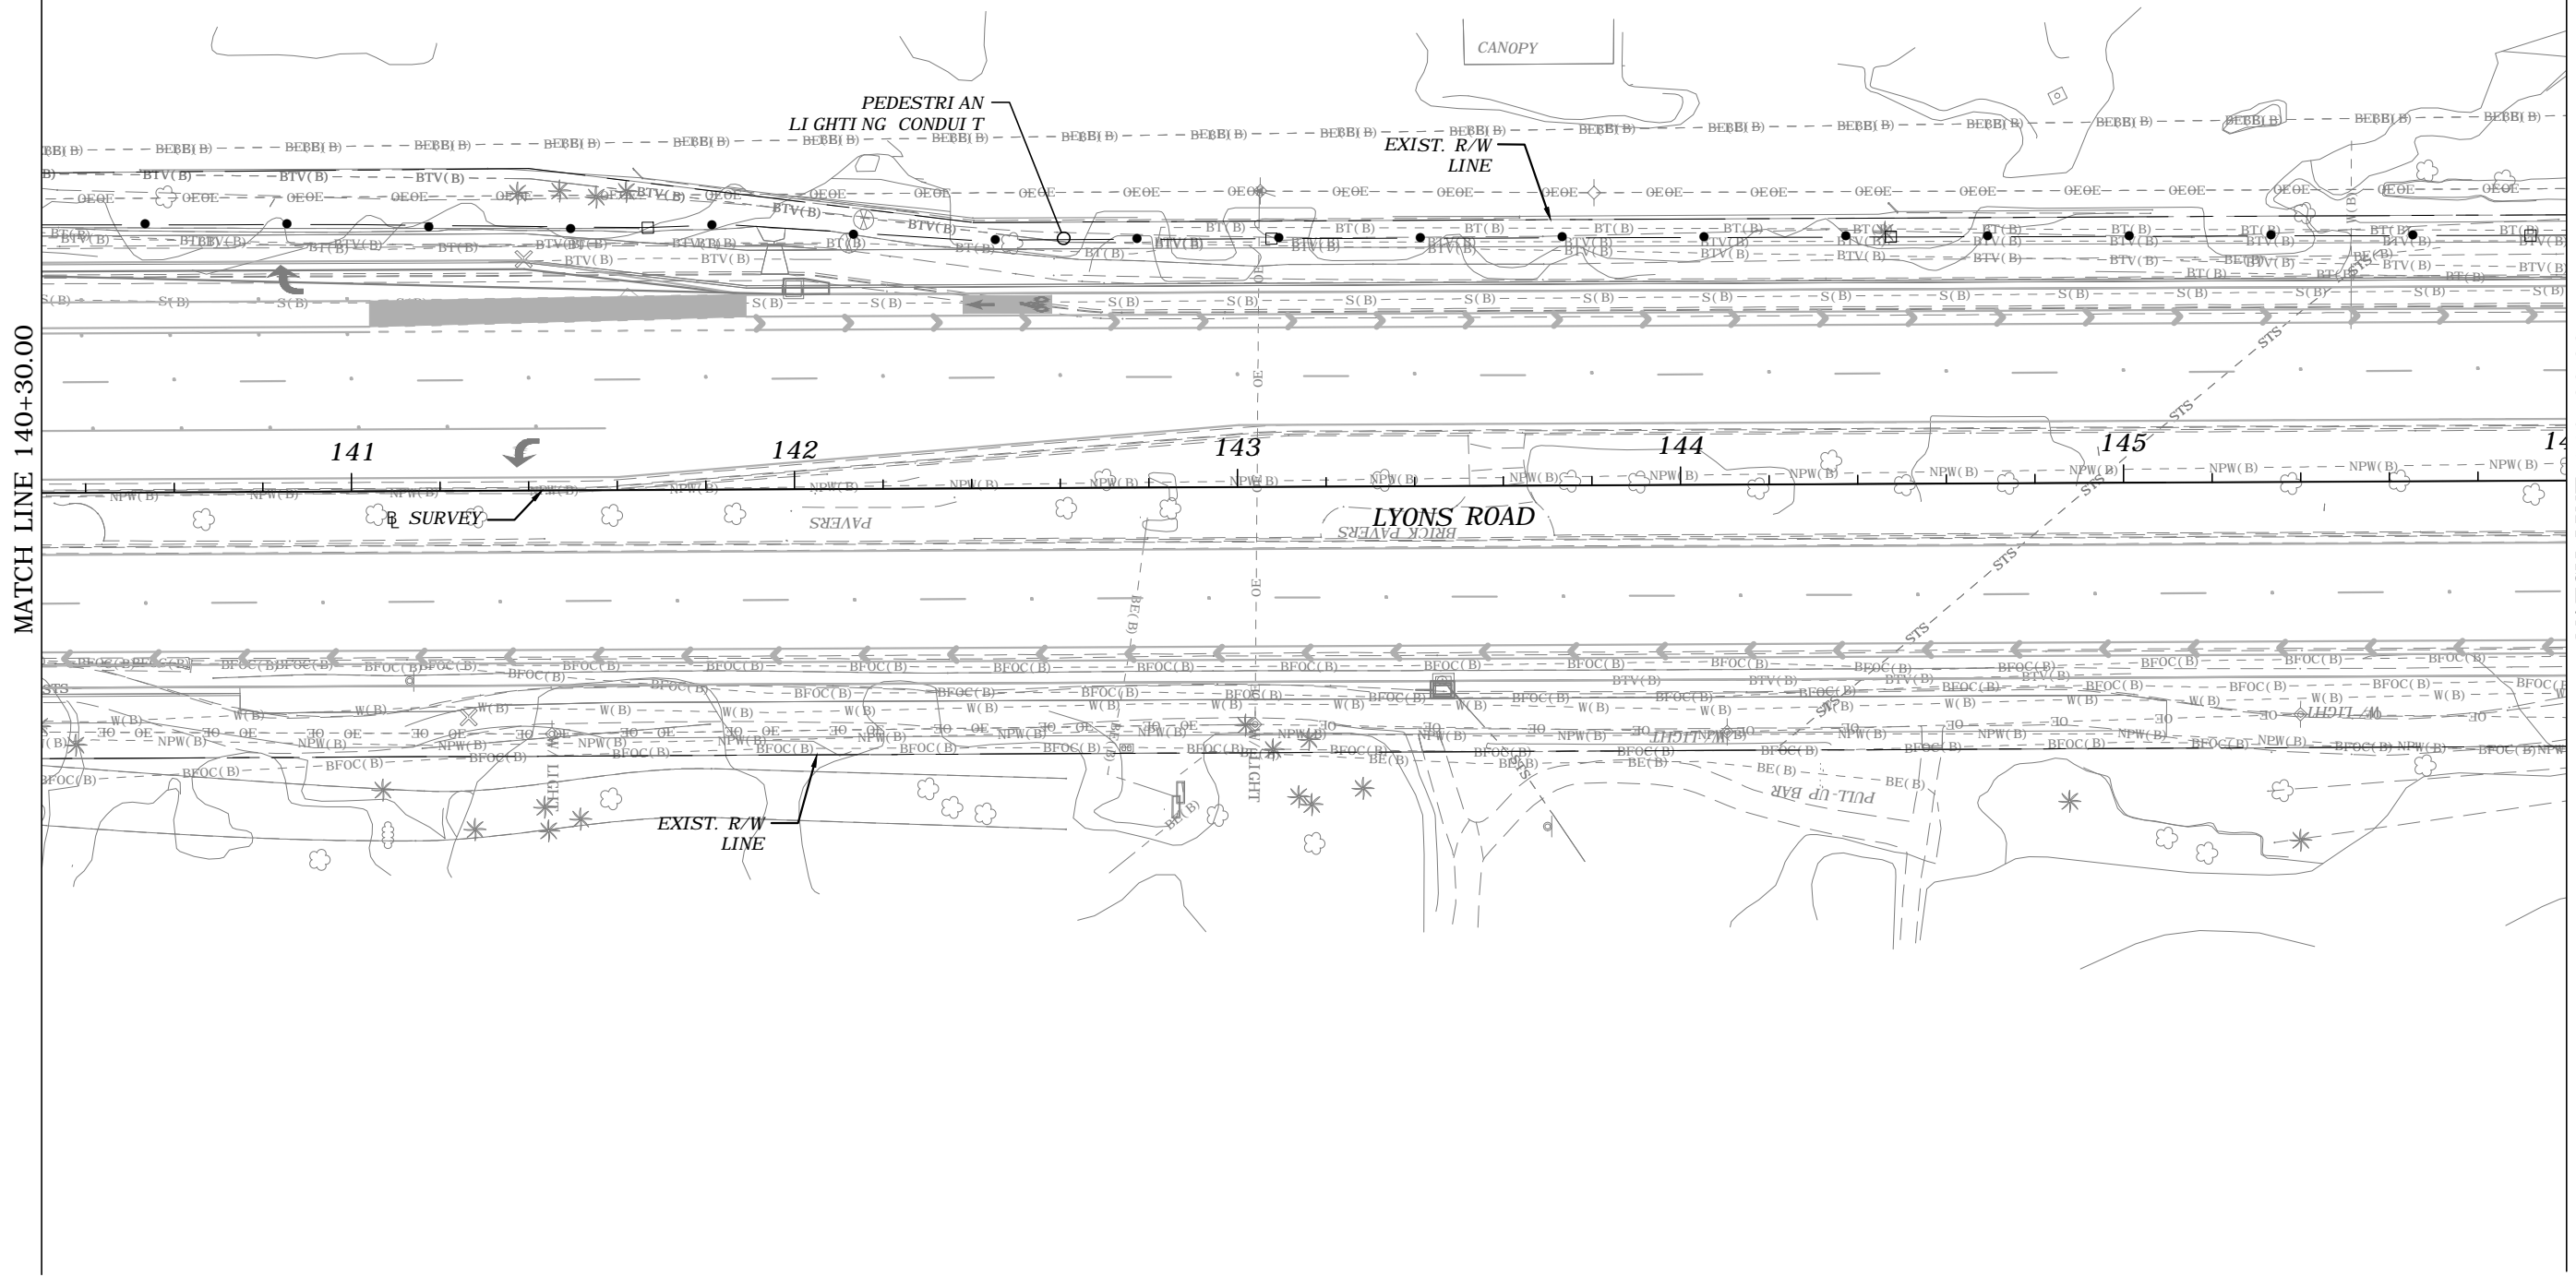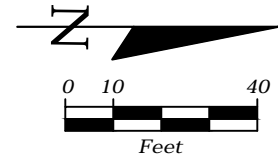

MATCH LINE 140+30.00

MATCH LINE 146+00.00



REVISIONS				FREDDIE A. VARGAS, P.E. P.E. LICENSE NUMBER 35941 CARNAHAN PROCTOR & CROSS, INC. 814 S. MILITARY TRAIL DEERFIELD BEACH, FL 33442 CERTIFICATE OF AUTHORIZATION 2936	STATE OF FLORIDA DEPARTMENT OF TRANSPORTATION			<i>PEDESTRIAN LIGHTING-CONDUIT          PLANS</i>	SHEET NO.
DATE	DESCRIPTION	DATE	DESCRIPTION		ROAD NO.	COUNTY	FINANCIAL PROJECT ID		L-27
---	---	---	---						

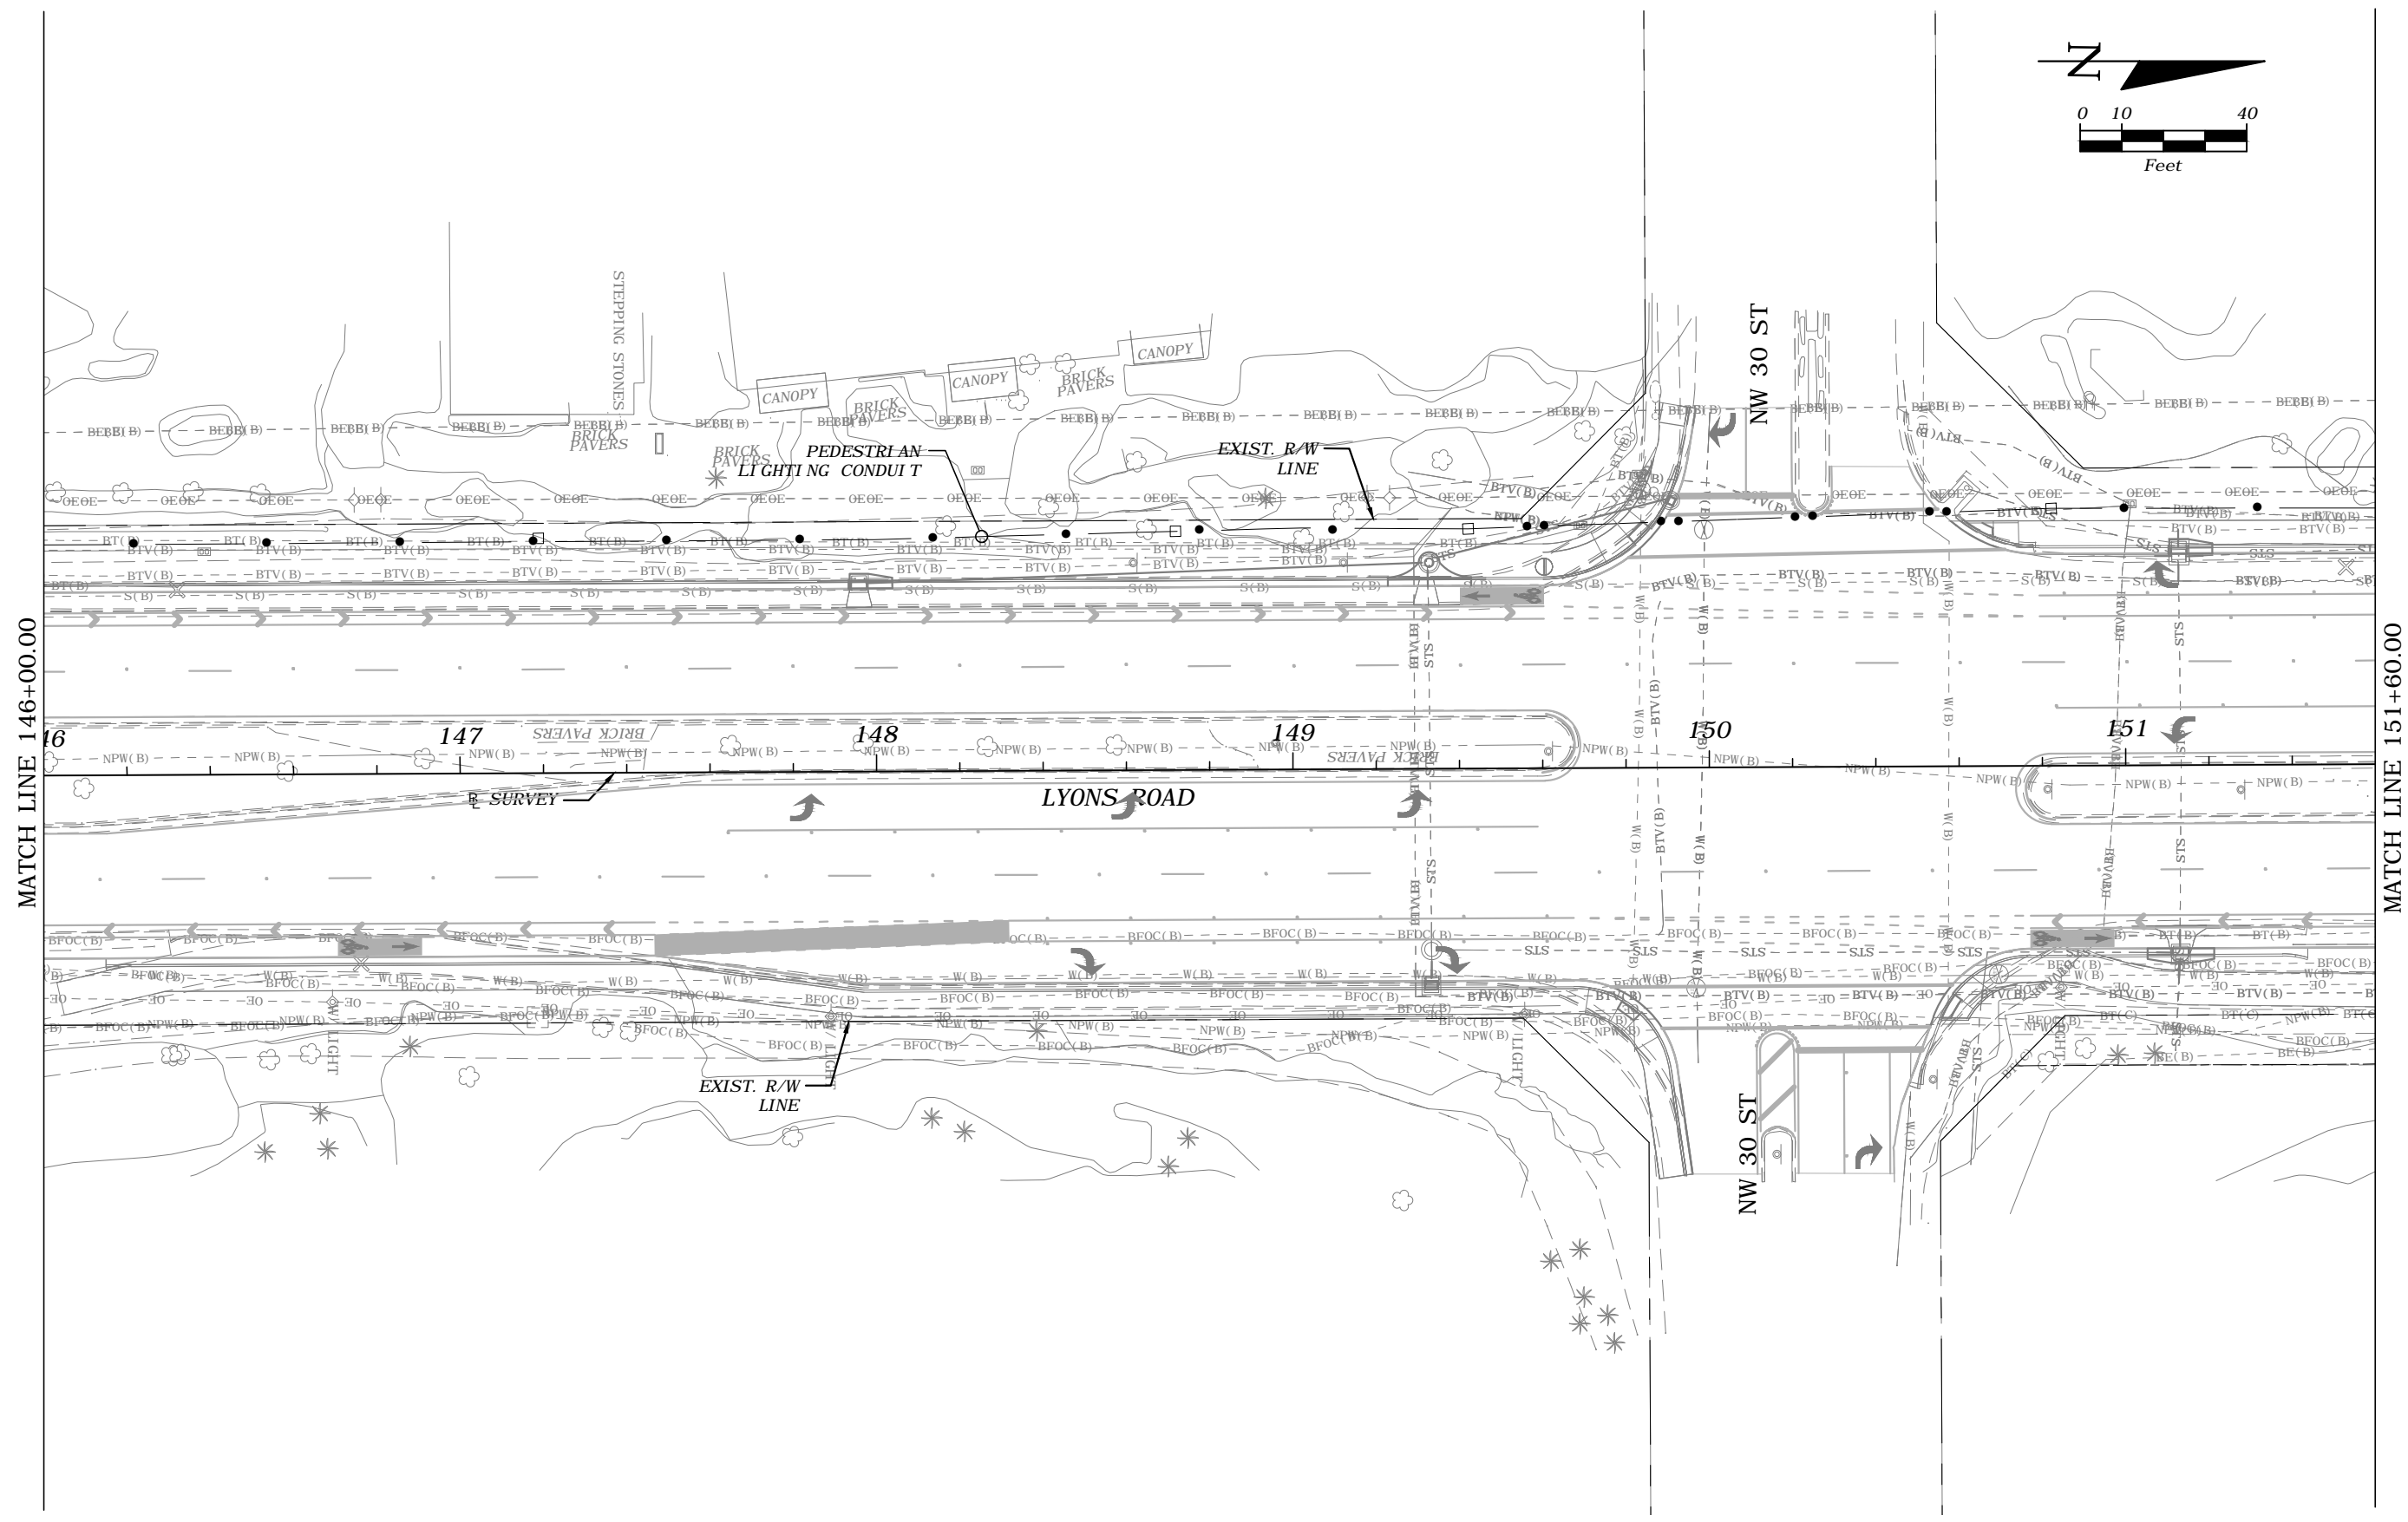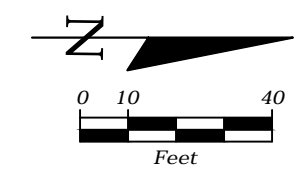

MATCH LINE 146+00.00

MATCH LINE 151+60.00



REVISIONS				FREDDIE A. VARGAS, P.E. P.E. LICENSE NUMBER 35941 CARNAHAN PROCTOR & CROSS, INC. 814 S. MILITARY TRAIL DEERFIELD BEACH, FL 33442 CERTIFICATE OF AUTHORIZATION 2936	STATE OF FLORIDA DEPARTMENT OF TRANSPORTATION			<i>PEDESTRIAN LIGHTING-CONDUIT          PLANS</i>	SHEET NO.
DATE	DESCRIPTION	DATE	DESCRIPTION		ROAD NO.	COUNTY	FINANCIAL PROJECT ID		L-28
---	---	---	---						

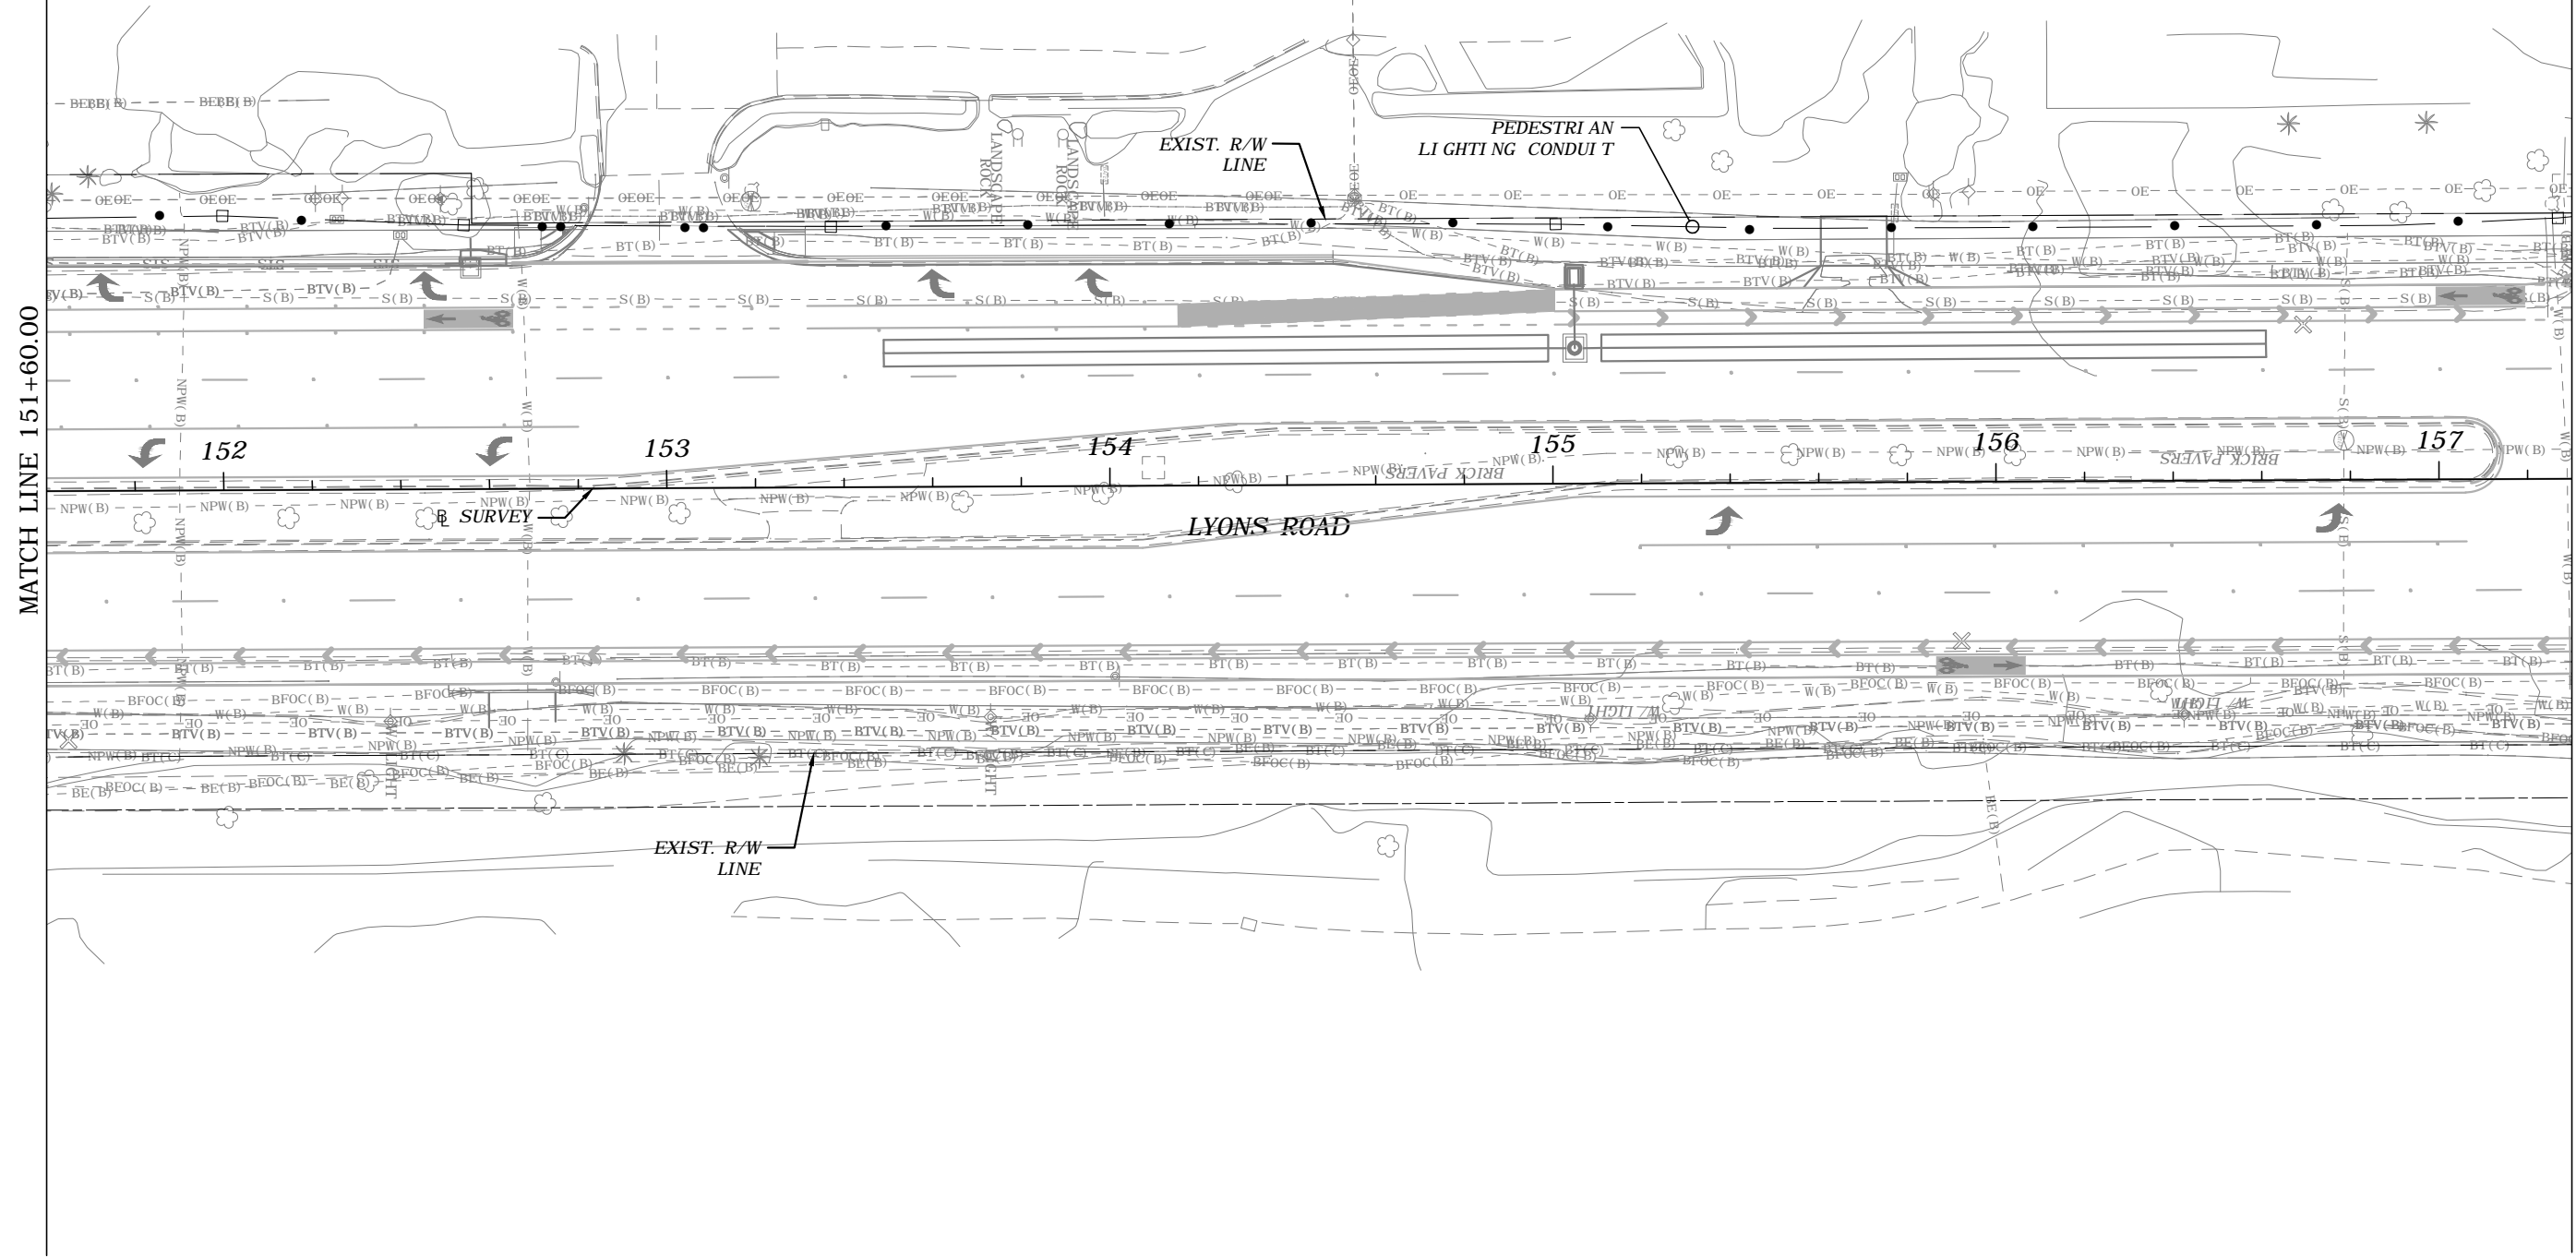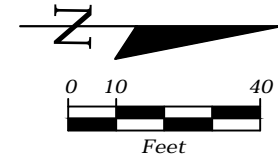

MATCH LINE 151+60.00

MATCH LINE 157+30.00



REVISIONS				FREDDIE A. VARGAS, P.E. P.E. LICENSE NUMBER 35941 CARNAHAN PROCTOR & CROSS, INC. 814 S. MILITARY TRAIL DEERFIELD BEACH, FL 33442 CERTIFICATE OF AUTHORIZATION 2936	STATE OF FLORIDA DEPARTMENT OF TRANSPORTATION			<i>PEDESTRIAN LIGHTING-CONDUIT          PLANS</i>	SHEET NO.
DATE	DESCRIPTION	DATE	DESCRIPTION		ROAD NO.	COUNTY	FINANCIAL PROJECT ID		L-29
---	---	---	---						

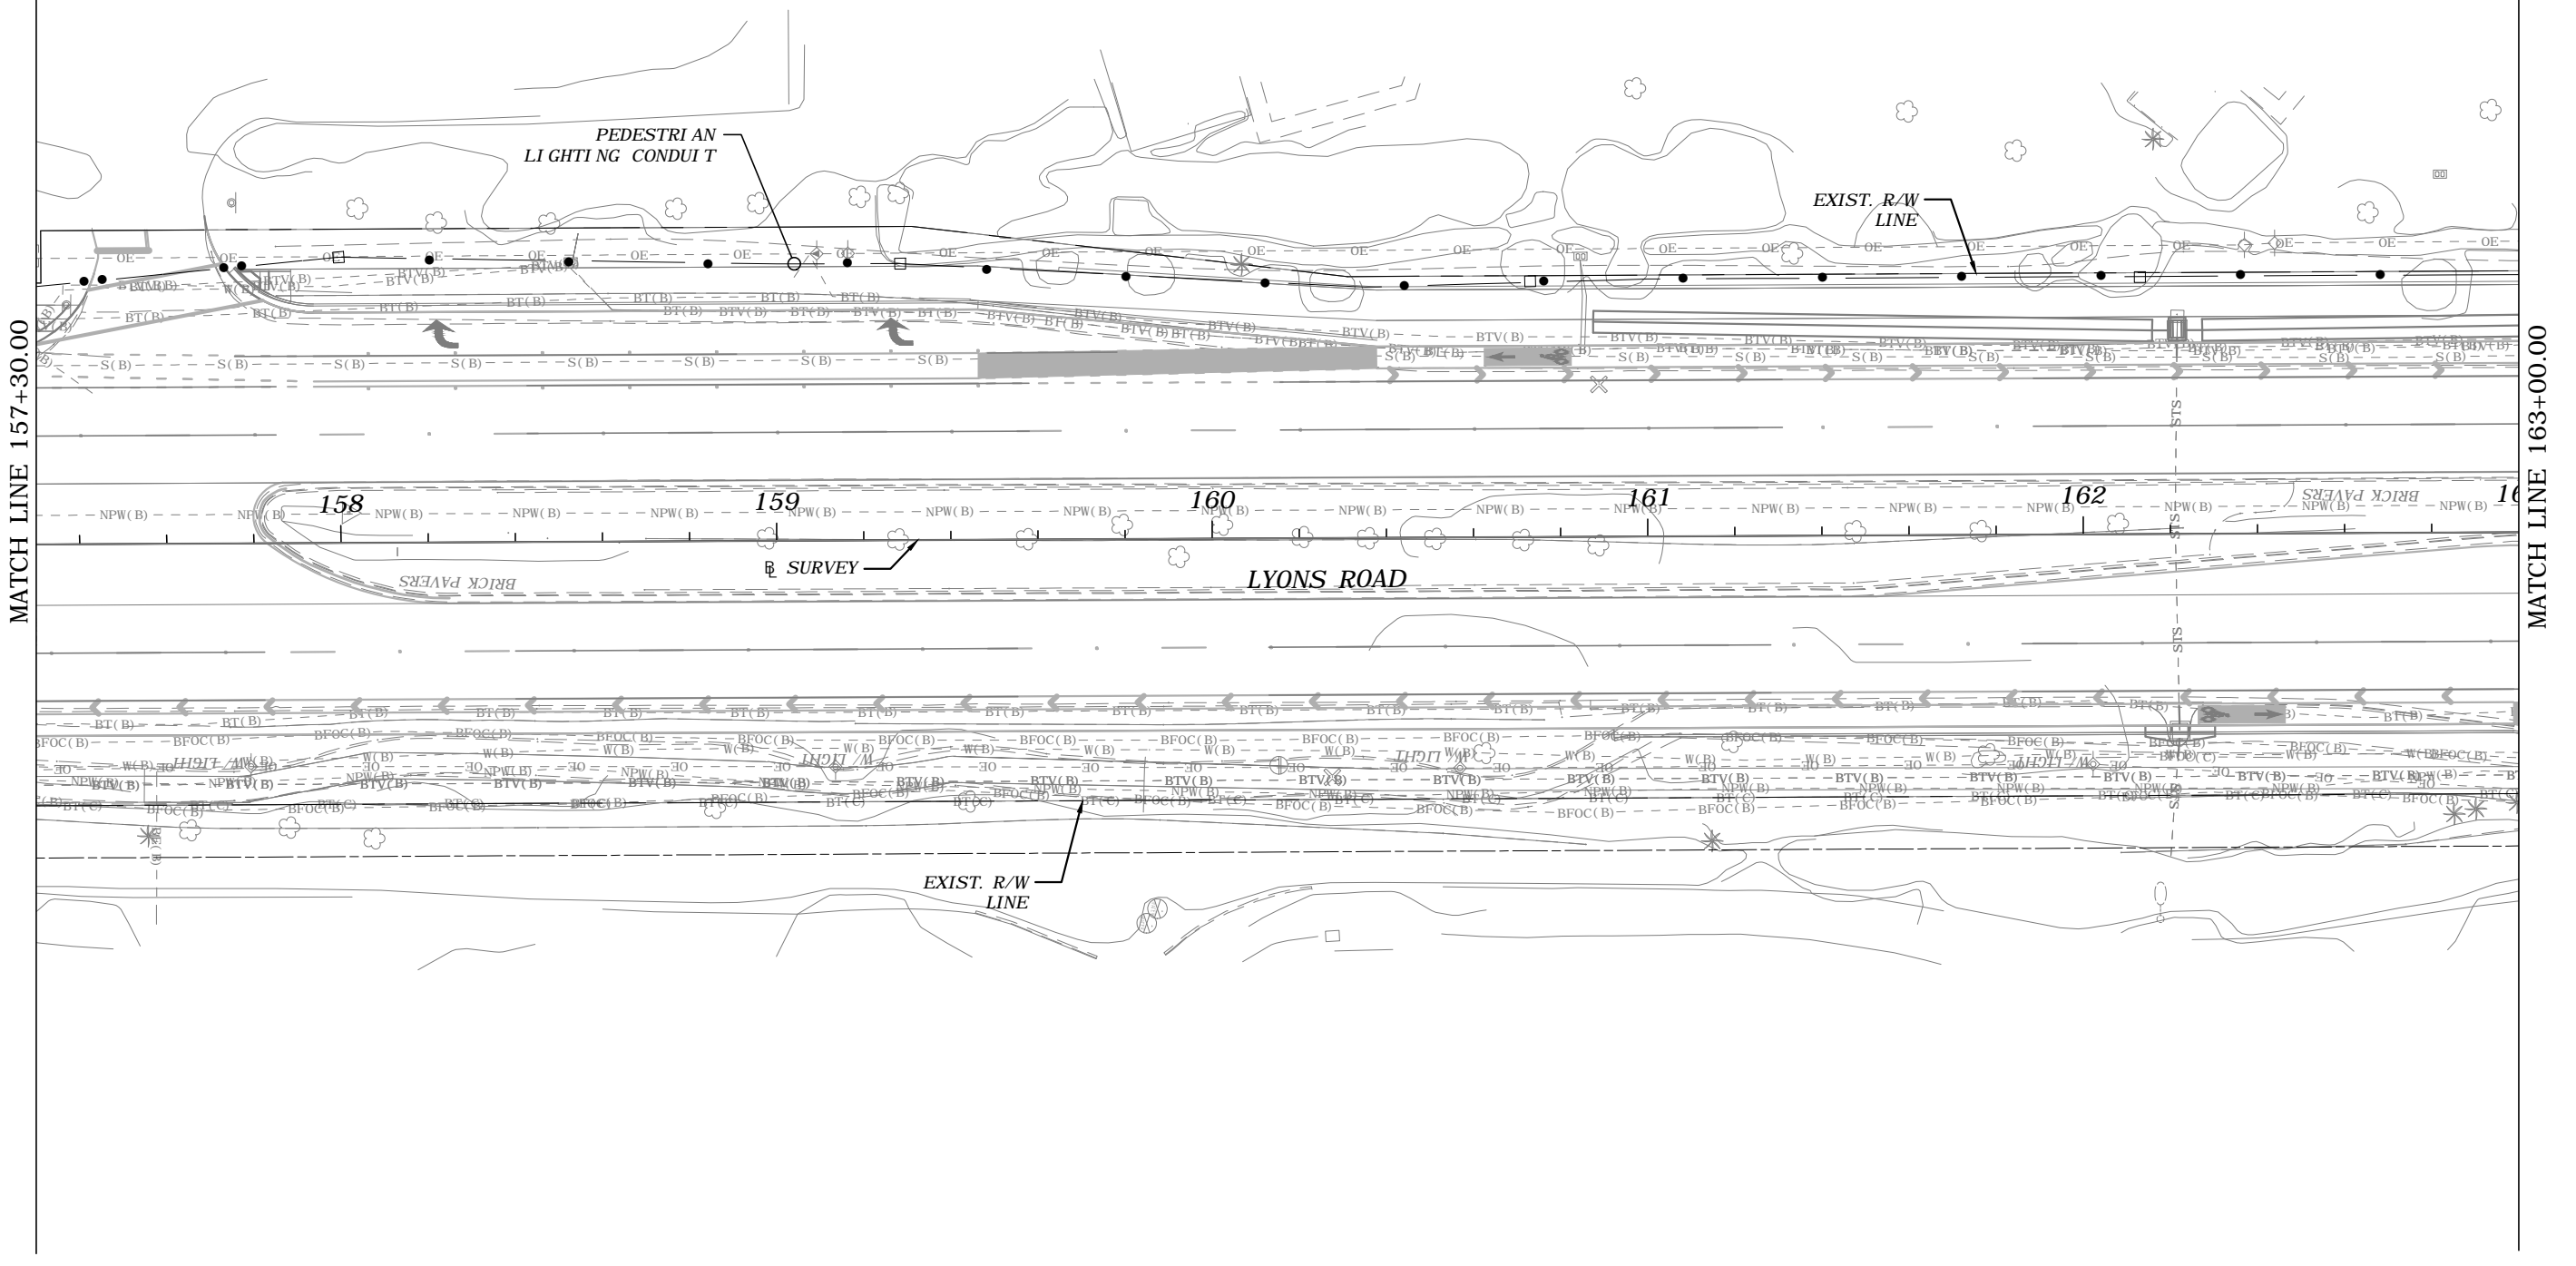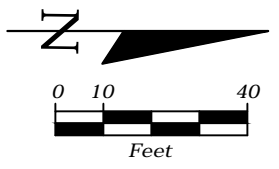

MATCH LINE 157+30.00

MATCH LINE 163+00.00

REVISIONS				FREDDIE A. VARGAS, P.E. P.E. LICENSE NUMBER 35941 CARNAHAN PROCTOR & CROSS, INC. 814 S. MILITARY TRAIL DEERFIELD BEACH, FL 33442 CERTIFICATE OF AUTHORIZATION 2936	STATE OF FLORIDA DEPARTMENT OF TRANSPORTATION			<i>PEDESTRIAN LIGHTING-CONDUIT PLANS</i>	SHEET NO.
DATE	DESCRIPTION	DATE	DESCRIPTION		ROAD NO.	COUNTY	FINANCIAL PROJECT ID		L-30
---	---	---	---						

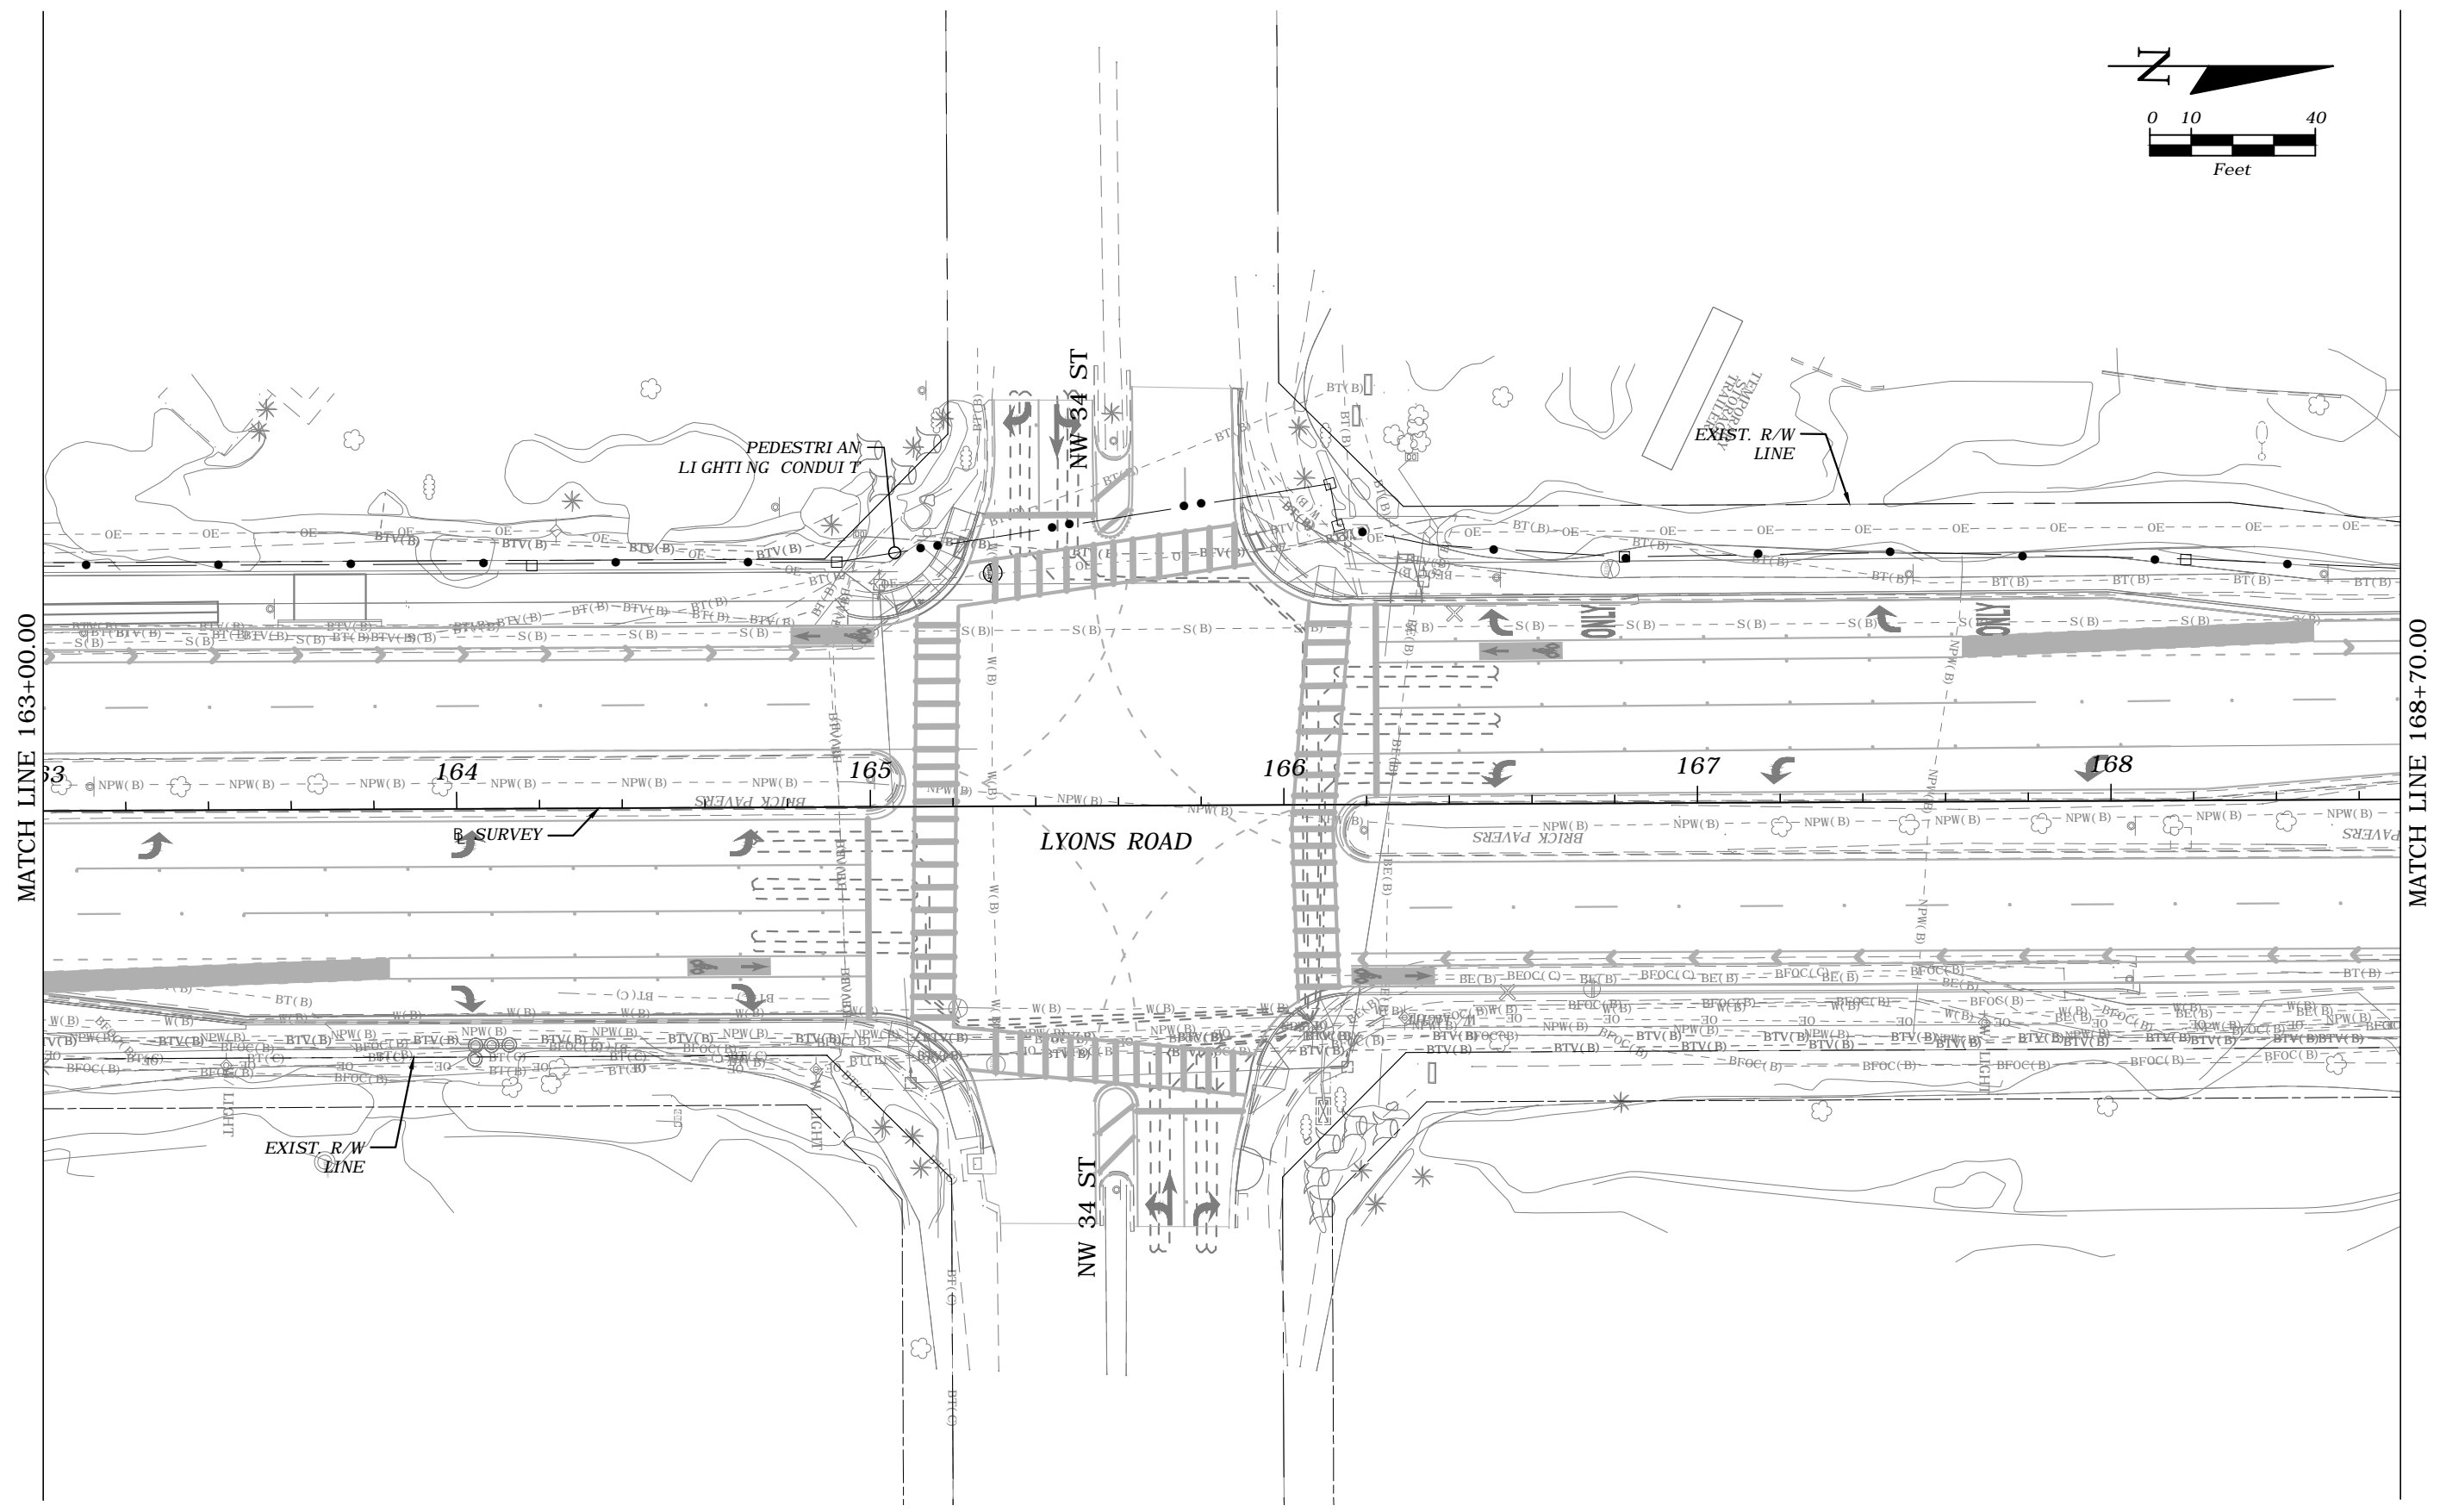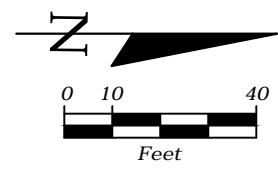

MATCH LINE 163+00.00

MATCH LINE 168+70.00



REVISIONS				FREDDIE A. VARGAS, P.E. P.E. LICENSE NUMBER 35941 CARNAHAN PROCTOR & CROSS, INC. 814 S. MILITARY TRAIL DEERFIELD BEACH, FL 33442 CERTIFICATE OF AUTHORIZATION 2936	STATE OF FLORIDA DEPARTMENT OF TRANSPORTATION			<i>PEDESTRIAN LIGHTING-CONDUIT PLANS</i>	SHEET NO.  L-31
DATE	DESCRIPTION	DATE	DESCRIPTION		ROAD NO.	COUNTY	FINANCIAL PROJECT ID		
---	---	---	---		BROWARD	436319-1-52-03			

Terence Castillo

6/4/2019 12:38:18 PM

P:\projects\181201 - Pedestrian Light Features\43631915201\PLANLT02.dwg

THE OFFICIAL RECORD OF THIS SHEET IS THE ELECTRONIC FILE DIGITALLY SIGNED AND SEALED UNDER RULE 61G15-23.004, F.A.C.

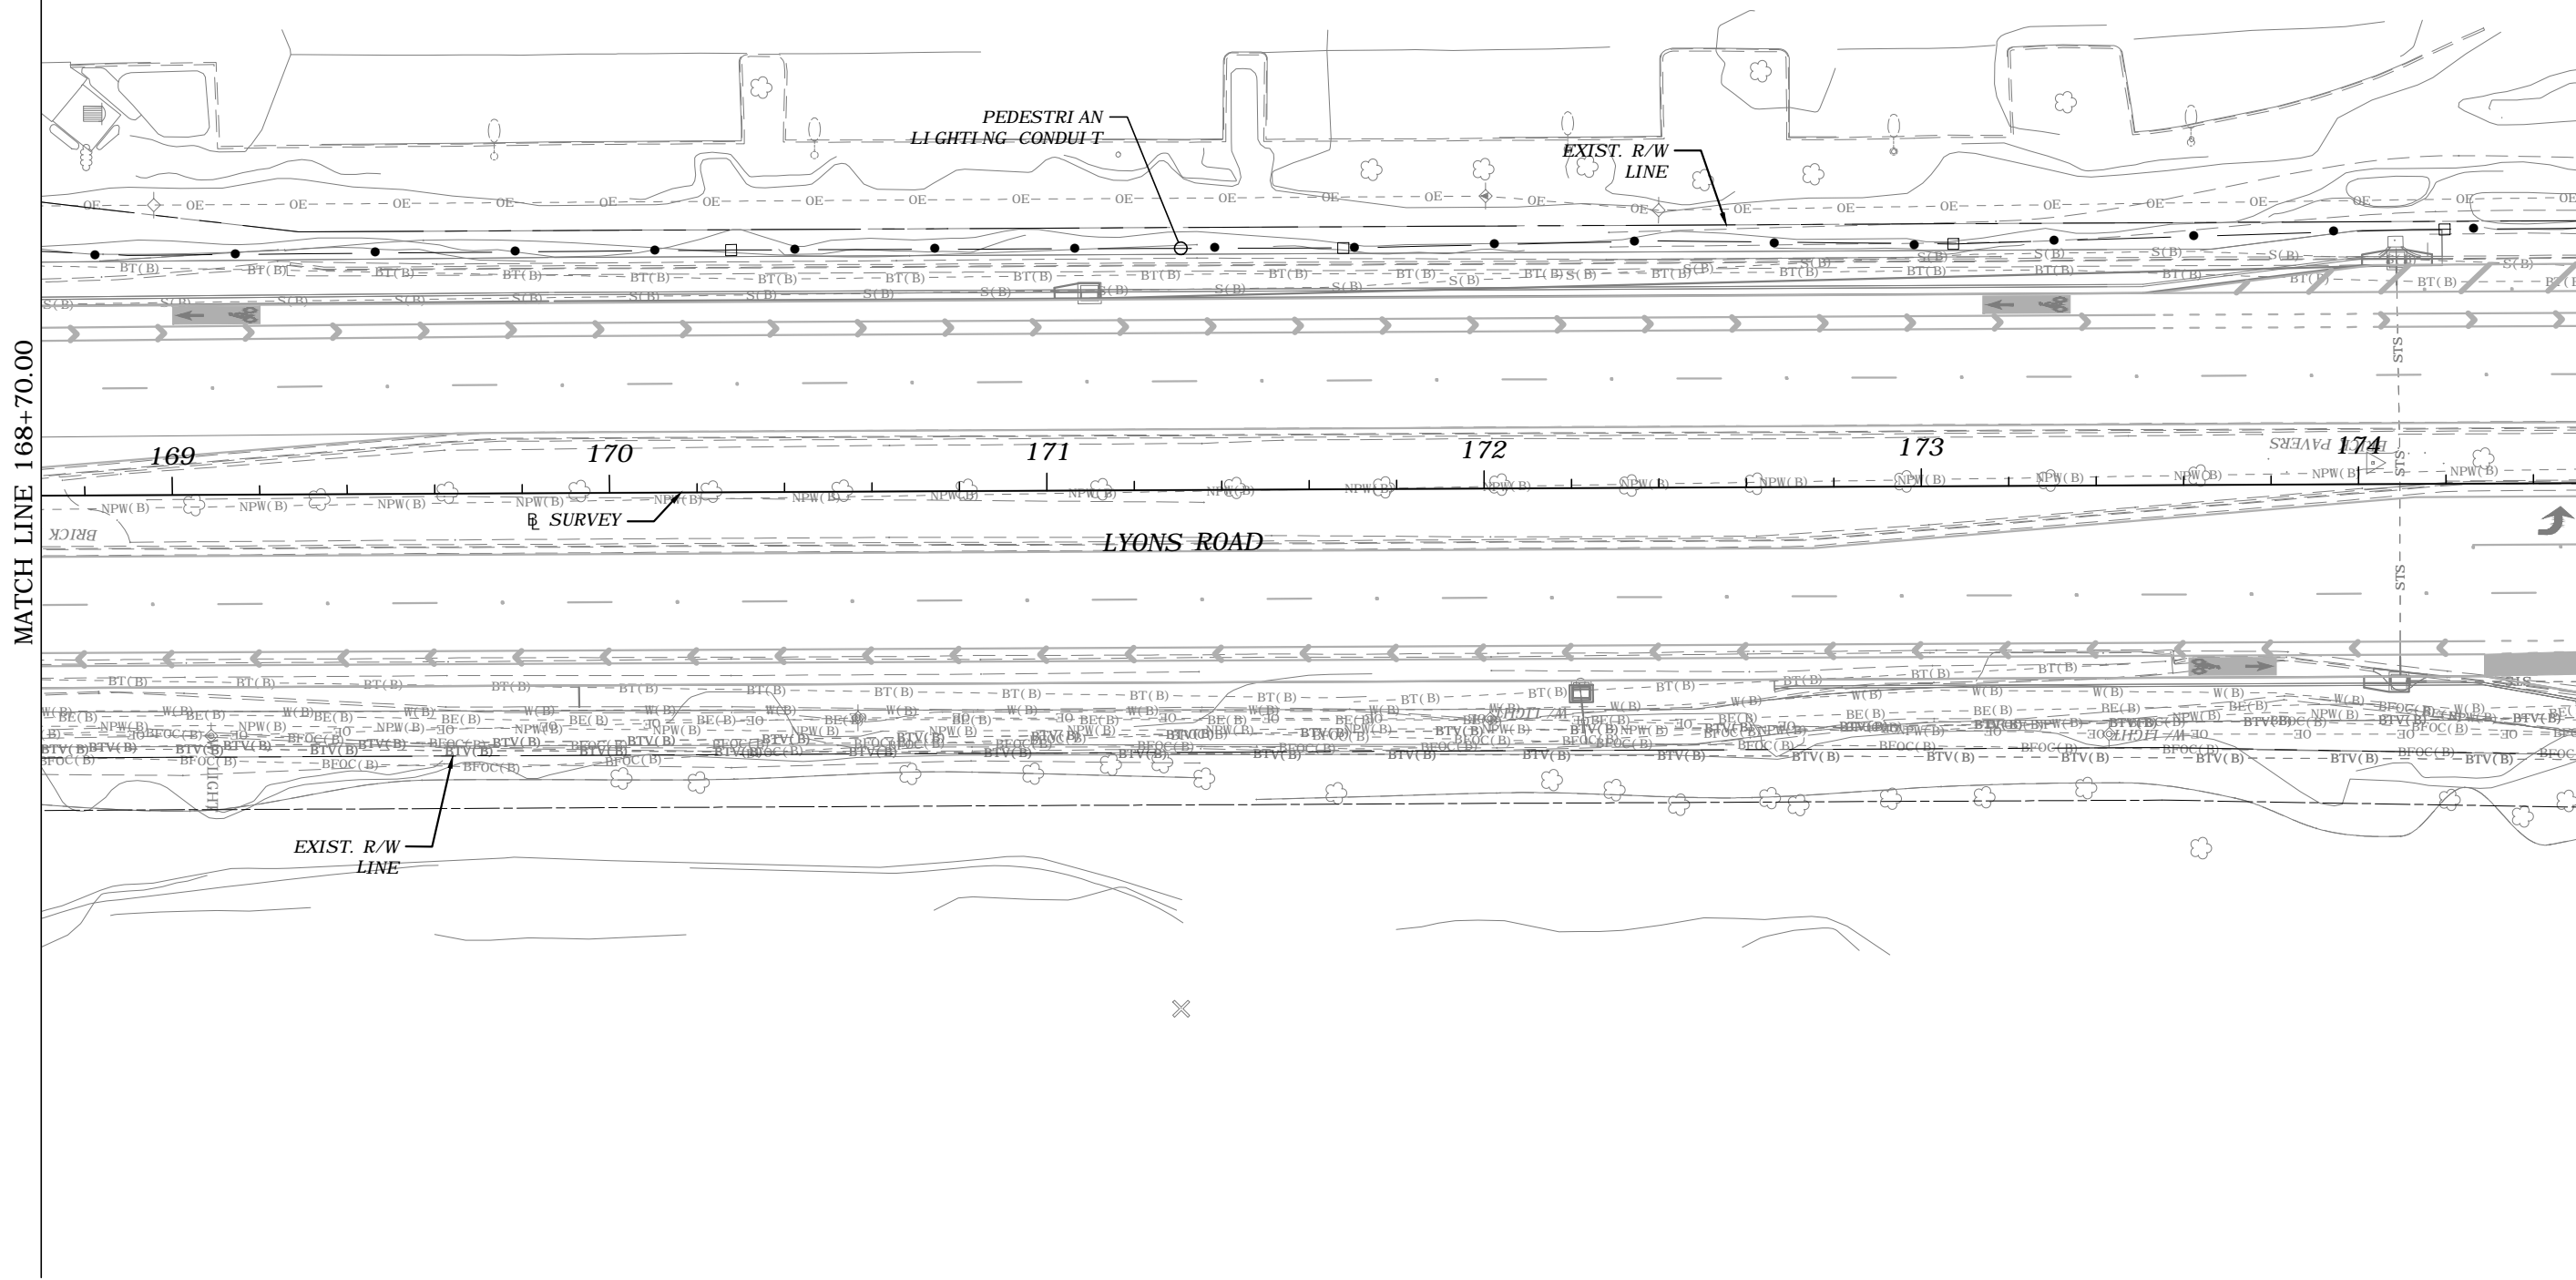
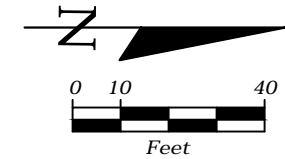


MATCH LINE 168+70.00

MATCH LINE 174+50.00

REVISIONS				FREDDIE A. VARGAS, P.E. P.E. LICENSE NUMBER 35941 CARNAHAN PROCTOR & CROSS, INC. 814 S. MILITARY TRAIL DEERFIELD BEACH, FL 33442 CERTIFICATE OF AUTHORIZATION 2936	STATE OF FLORIDA DEPARTMENT OF TRANSPORTATION			<i>PEDESTRIAN LIGHTING-CONDUIT          PLANS</i>	SHEET NO.
DATE	DESCRIPTION	DATE	DESCRIPTION		ROAD NO.	COUNTY	FINANCIAL PROJECT ID		L-32
---	---	---	---						



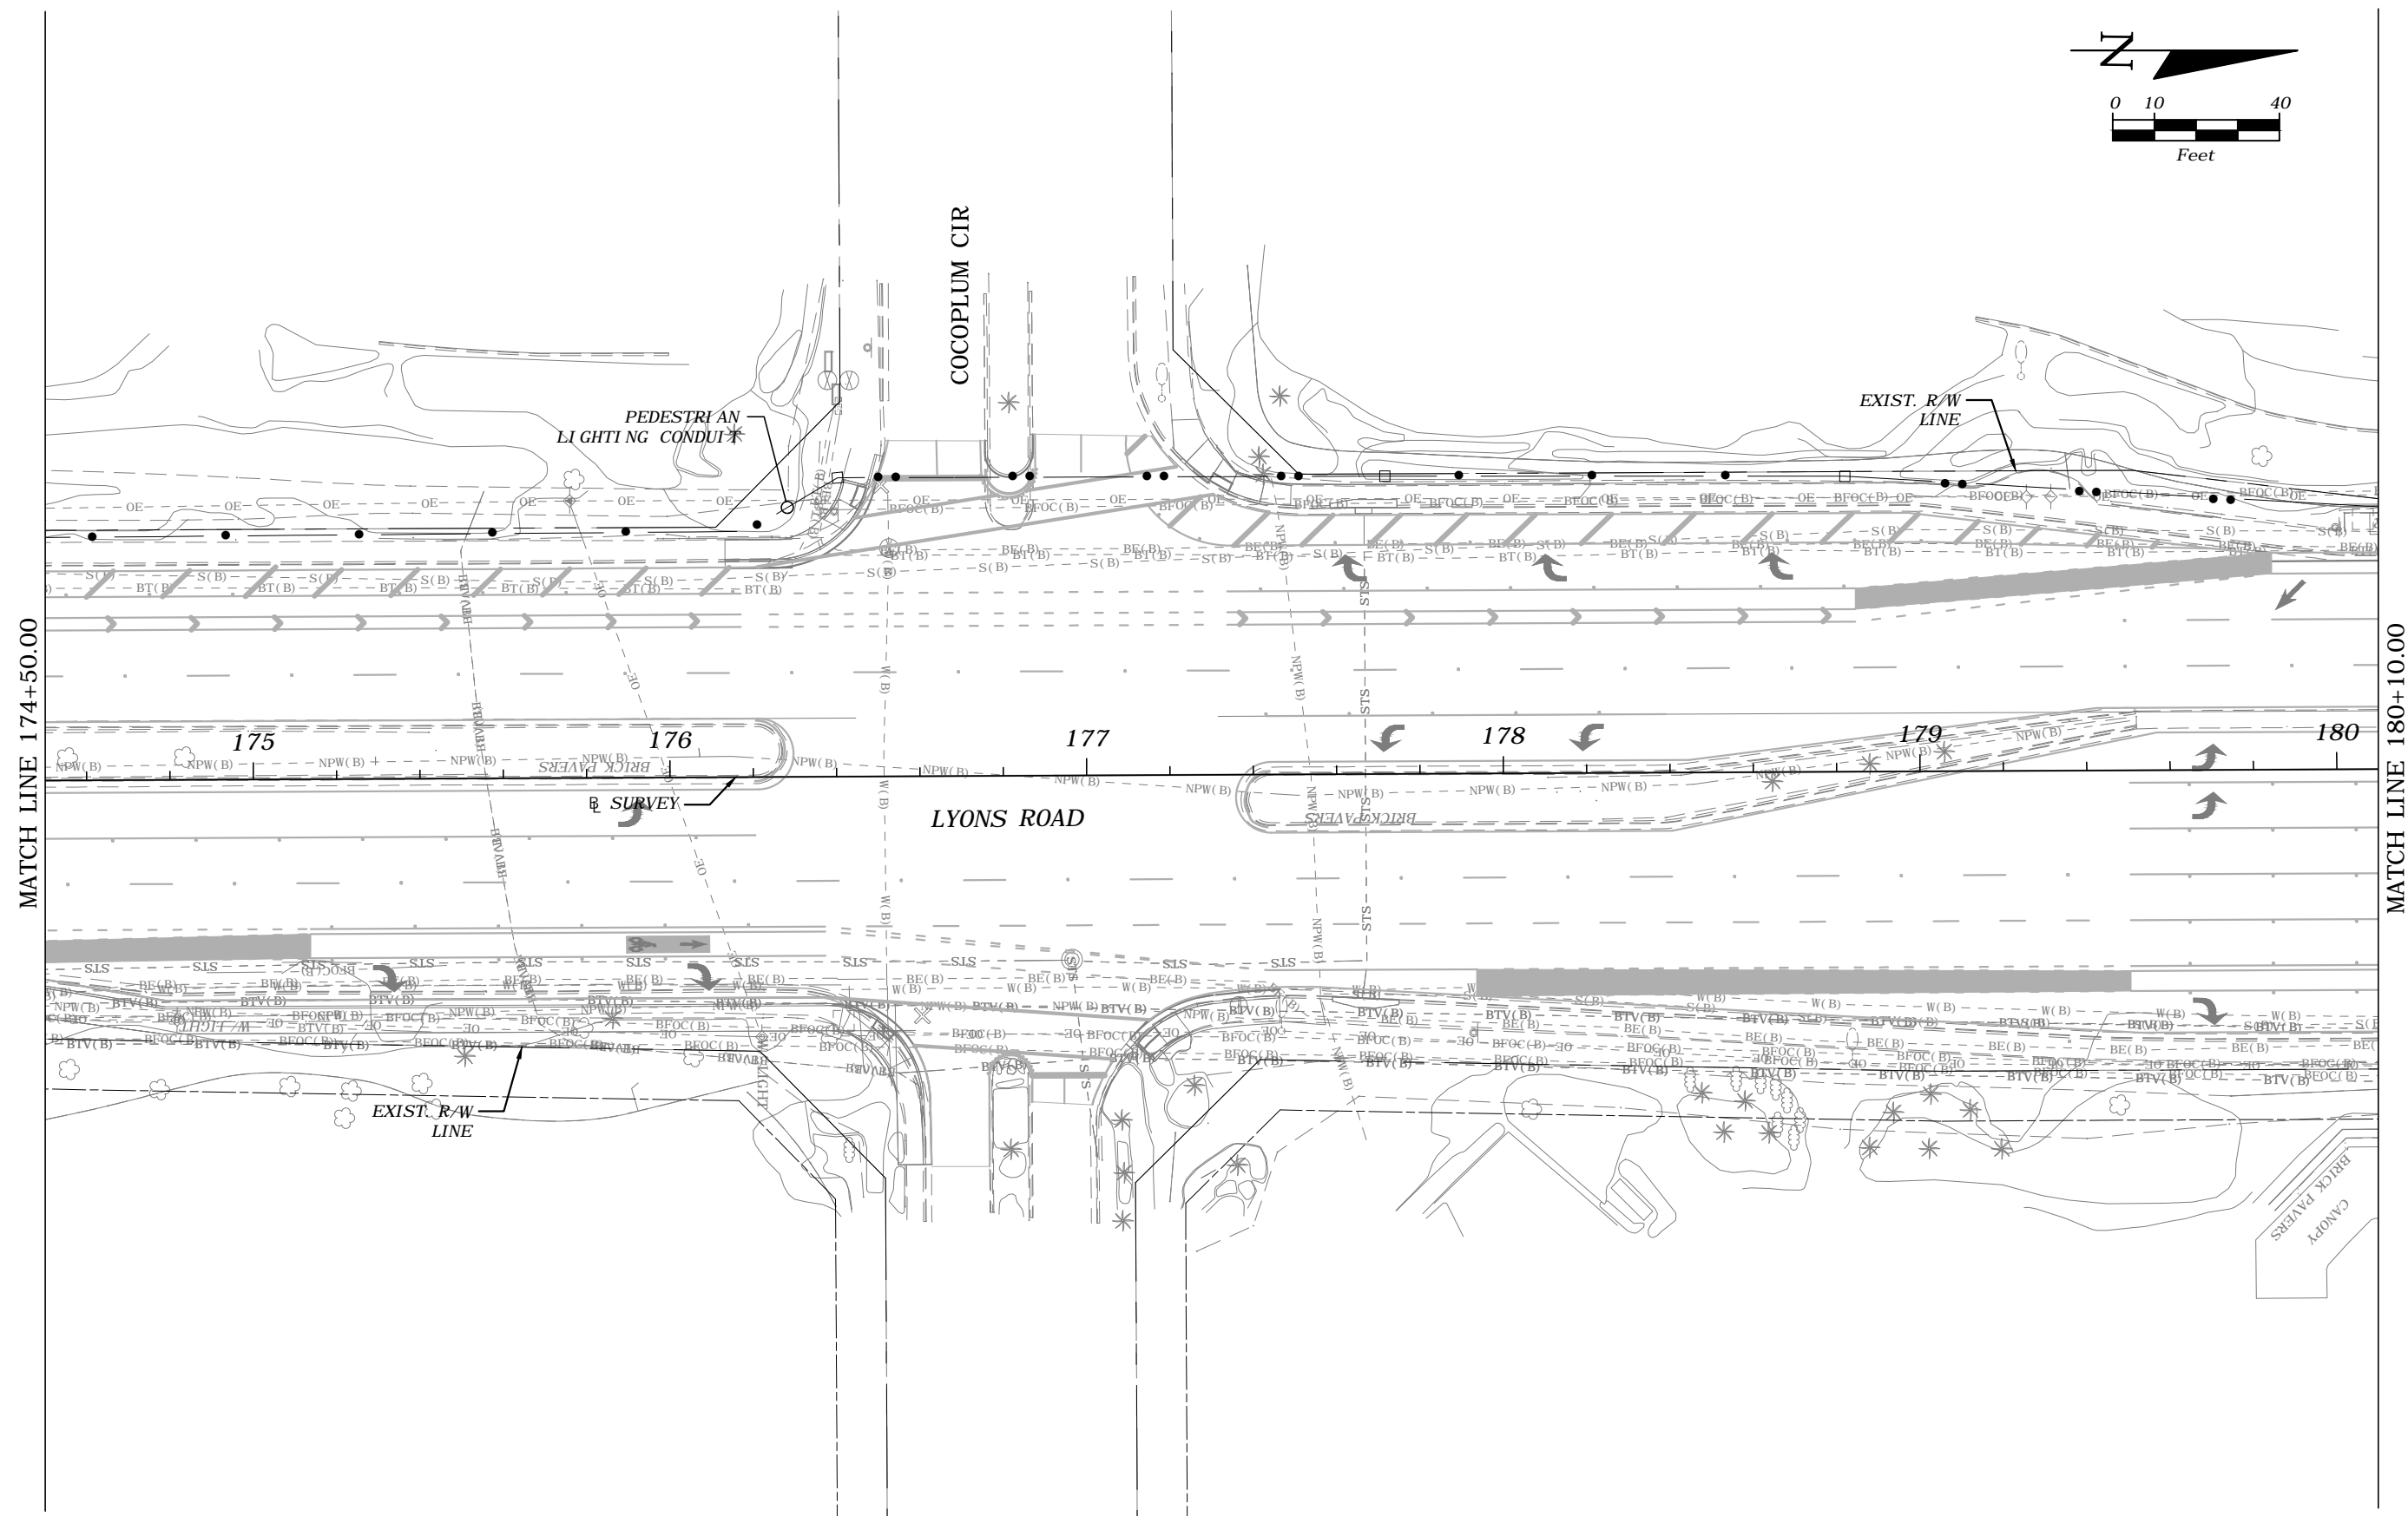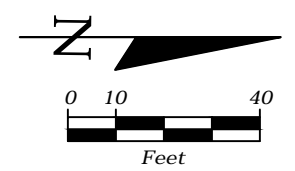

MATCH LINE 174+50.00

MATCH LINE 180+10.00



REVISIONS			
DATE	DESCRIPTION	DATE	DESCRIPTION
---	---	---	---

FREDDIE A. VARGAS, P.E.  
 P.E. LICENSE NUMBER 35941  
 CARNAHAN PROCTOR & CROSS, INC.  
 814 S. MILITARY TRAIL  
 DEERFIELD BEACH, FL 33442  
 CERTIFICATE OF AUTHORIZATION 2936

<b>STATE OF FLORIDA</b>		
<b>DEPARTMENT OF TRANSPORTATION</b>		
ROAD NO.	COUNTY	FINANCIAL PROJECT ID
	BROWARD	436319-1-52-03

***PEDESTRIAN LIGHTING-CONDUIT  
 PLANS***



SHEET  
 NO.  
**L-33**

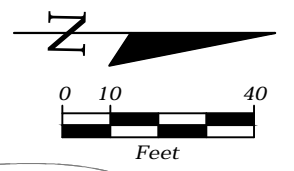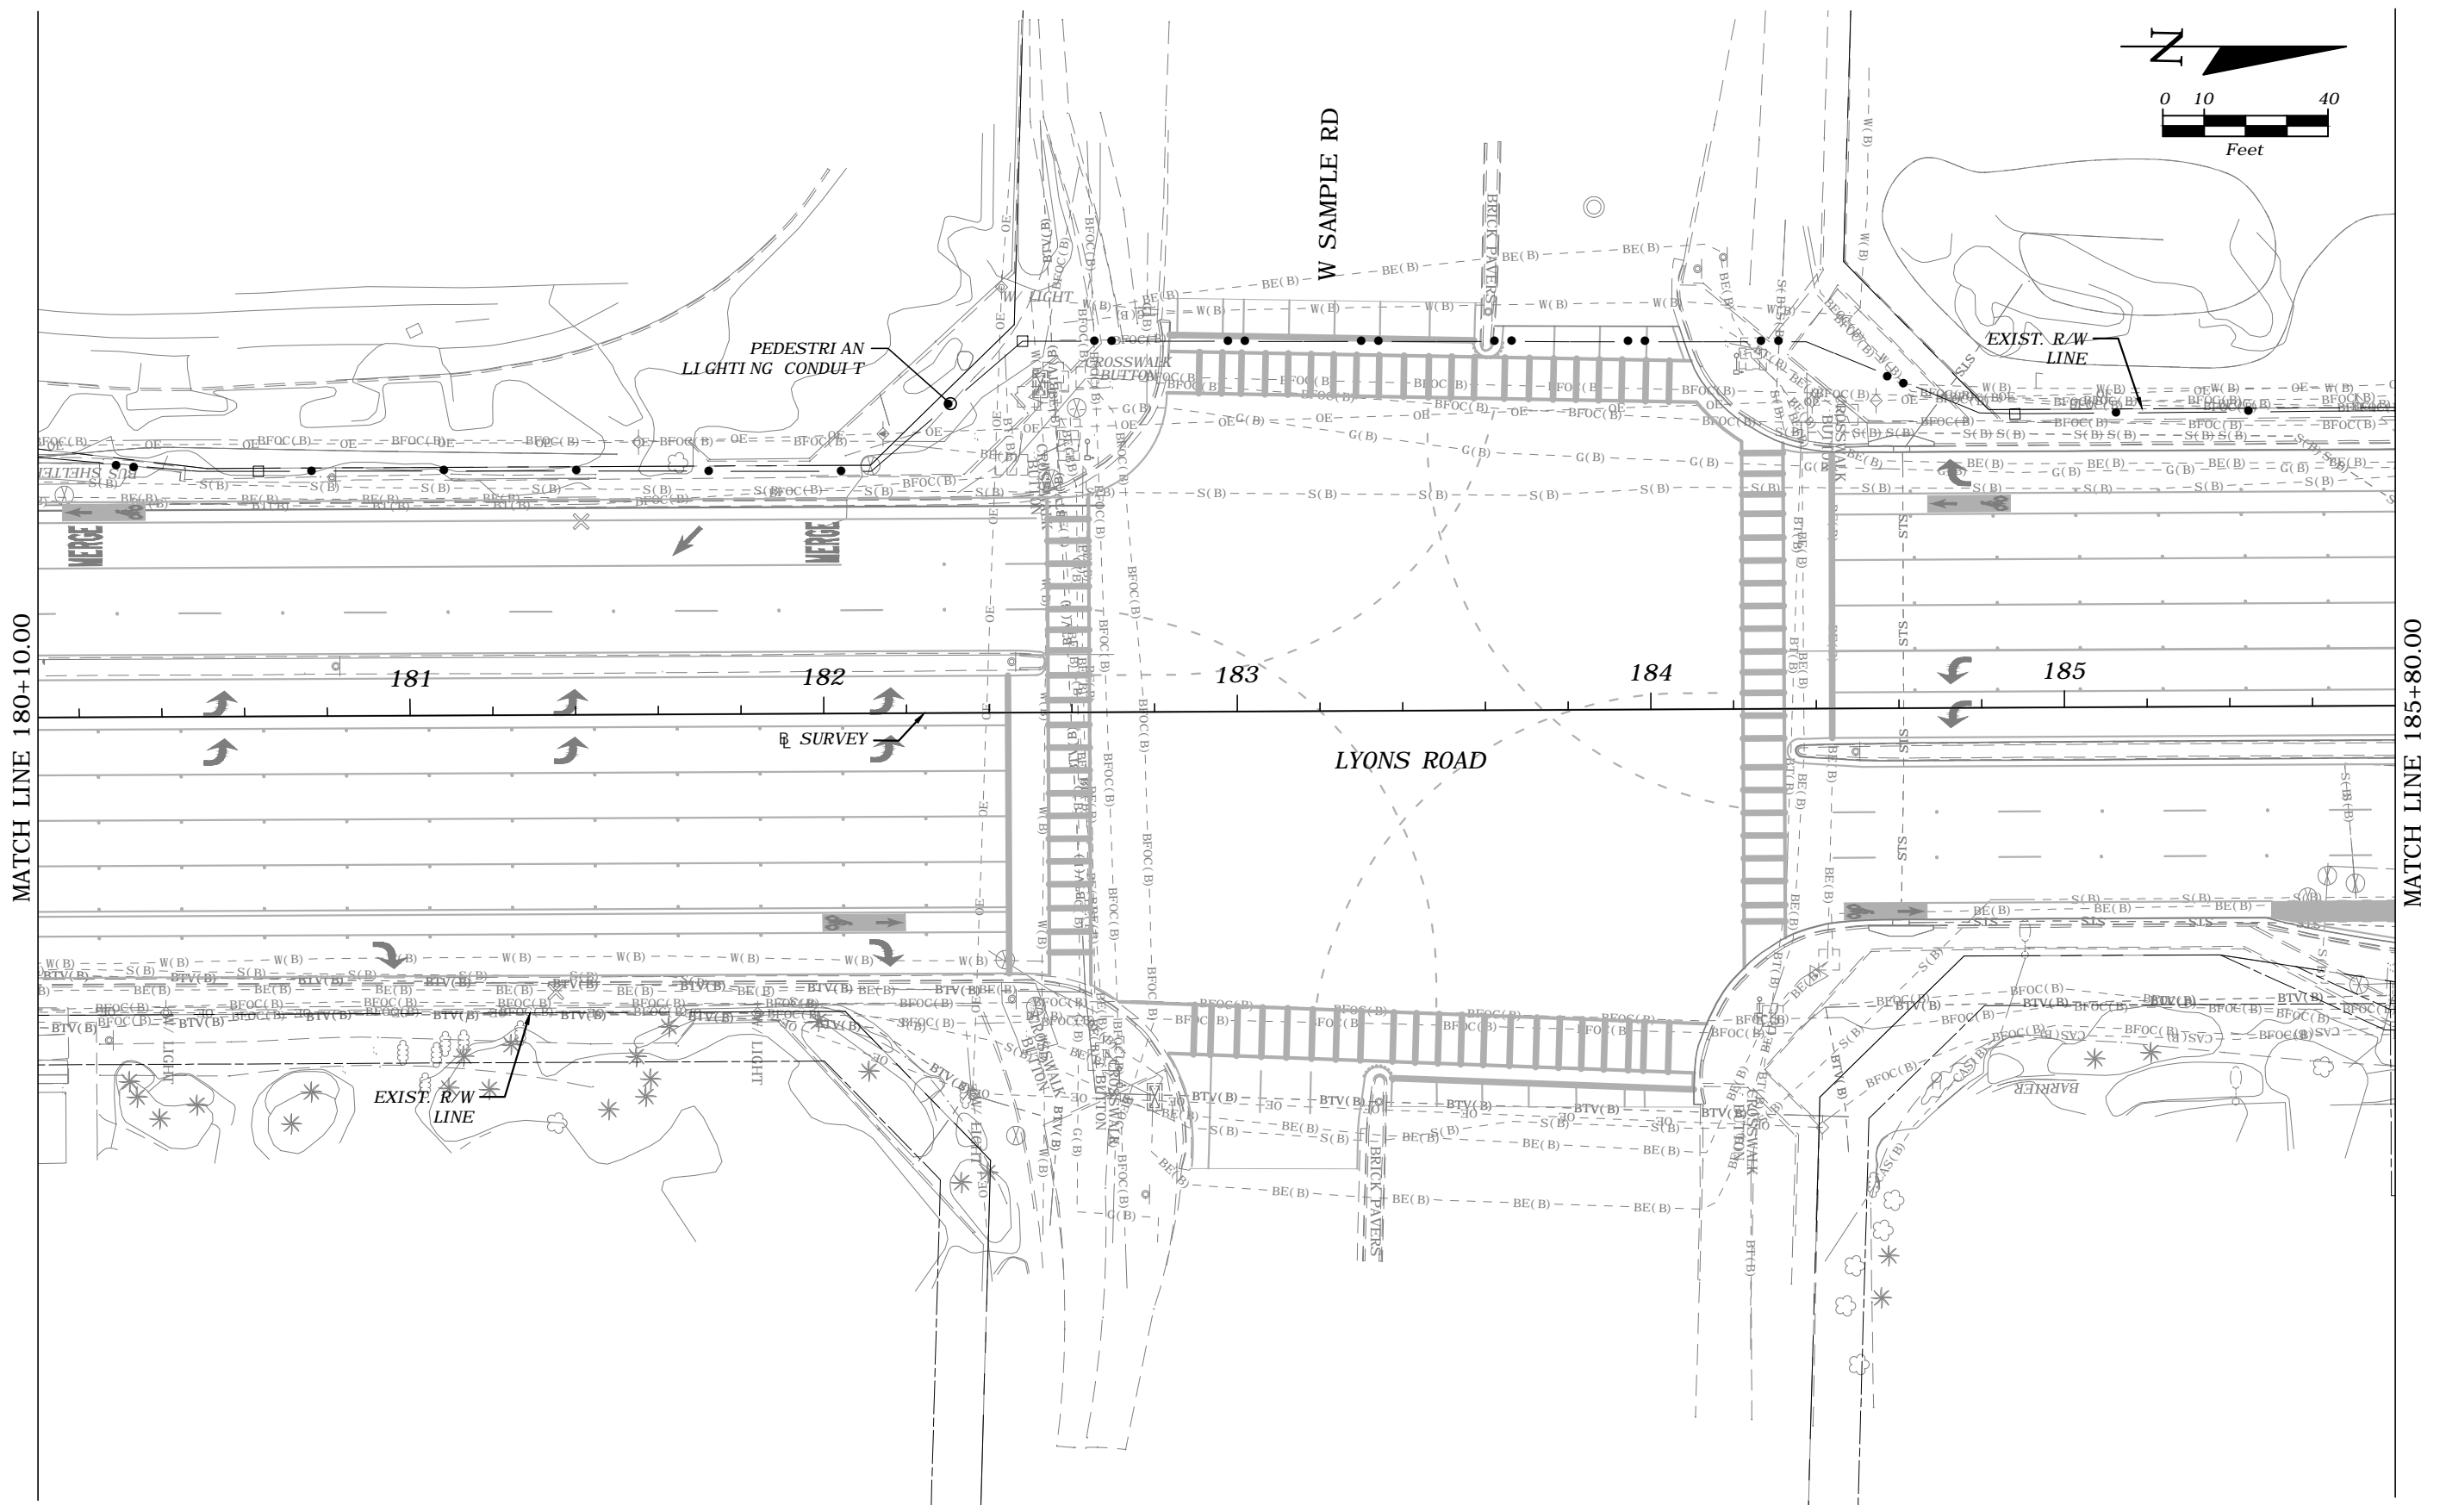

MATCH LINE 180+10.00

MATCH LINE 185+80.00


REVISIONS				FREDDIE A. VARGAS, P.E. P.E. LICENSE NUMBER 35941 CARNAHAN PROCTOR & CROSS, INC. 814 S. MILITARY TRAIL DEERFIELD BEACH, FL 33442 CERTIFICATE OF AUTHORIZATION 2936	STATE OF FLORIDA DEPARTMENT OF TRANSPORTATION			<i>PEDESTRIAN LIGHTING-CONDUIT PLANS</i>	SHEET NO.
DATE	DESCRIPTION	DATE	DESCRIPTION		ROAD NO.	COUNTY	FINANCIAL PROJECT ID		L-34
---	---	---	---			BROWARD	436319-1-52-03		

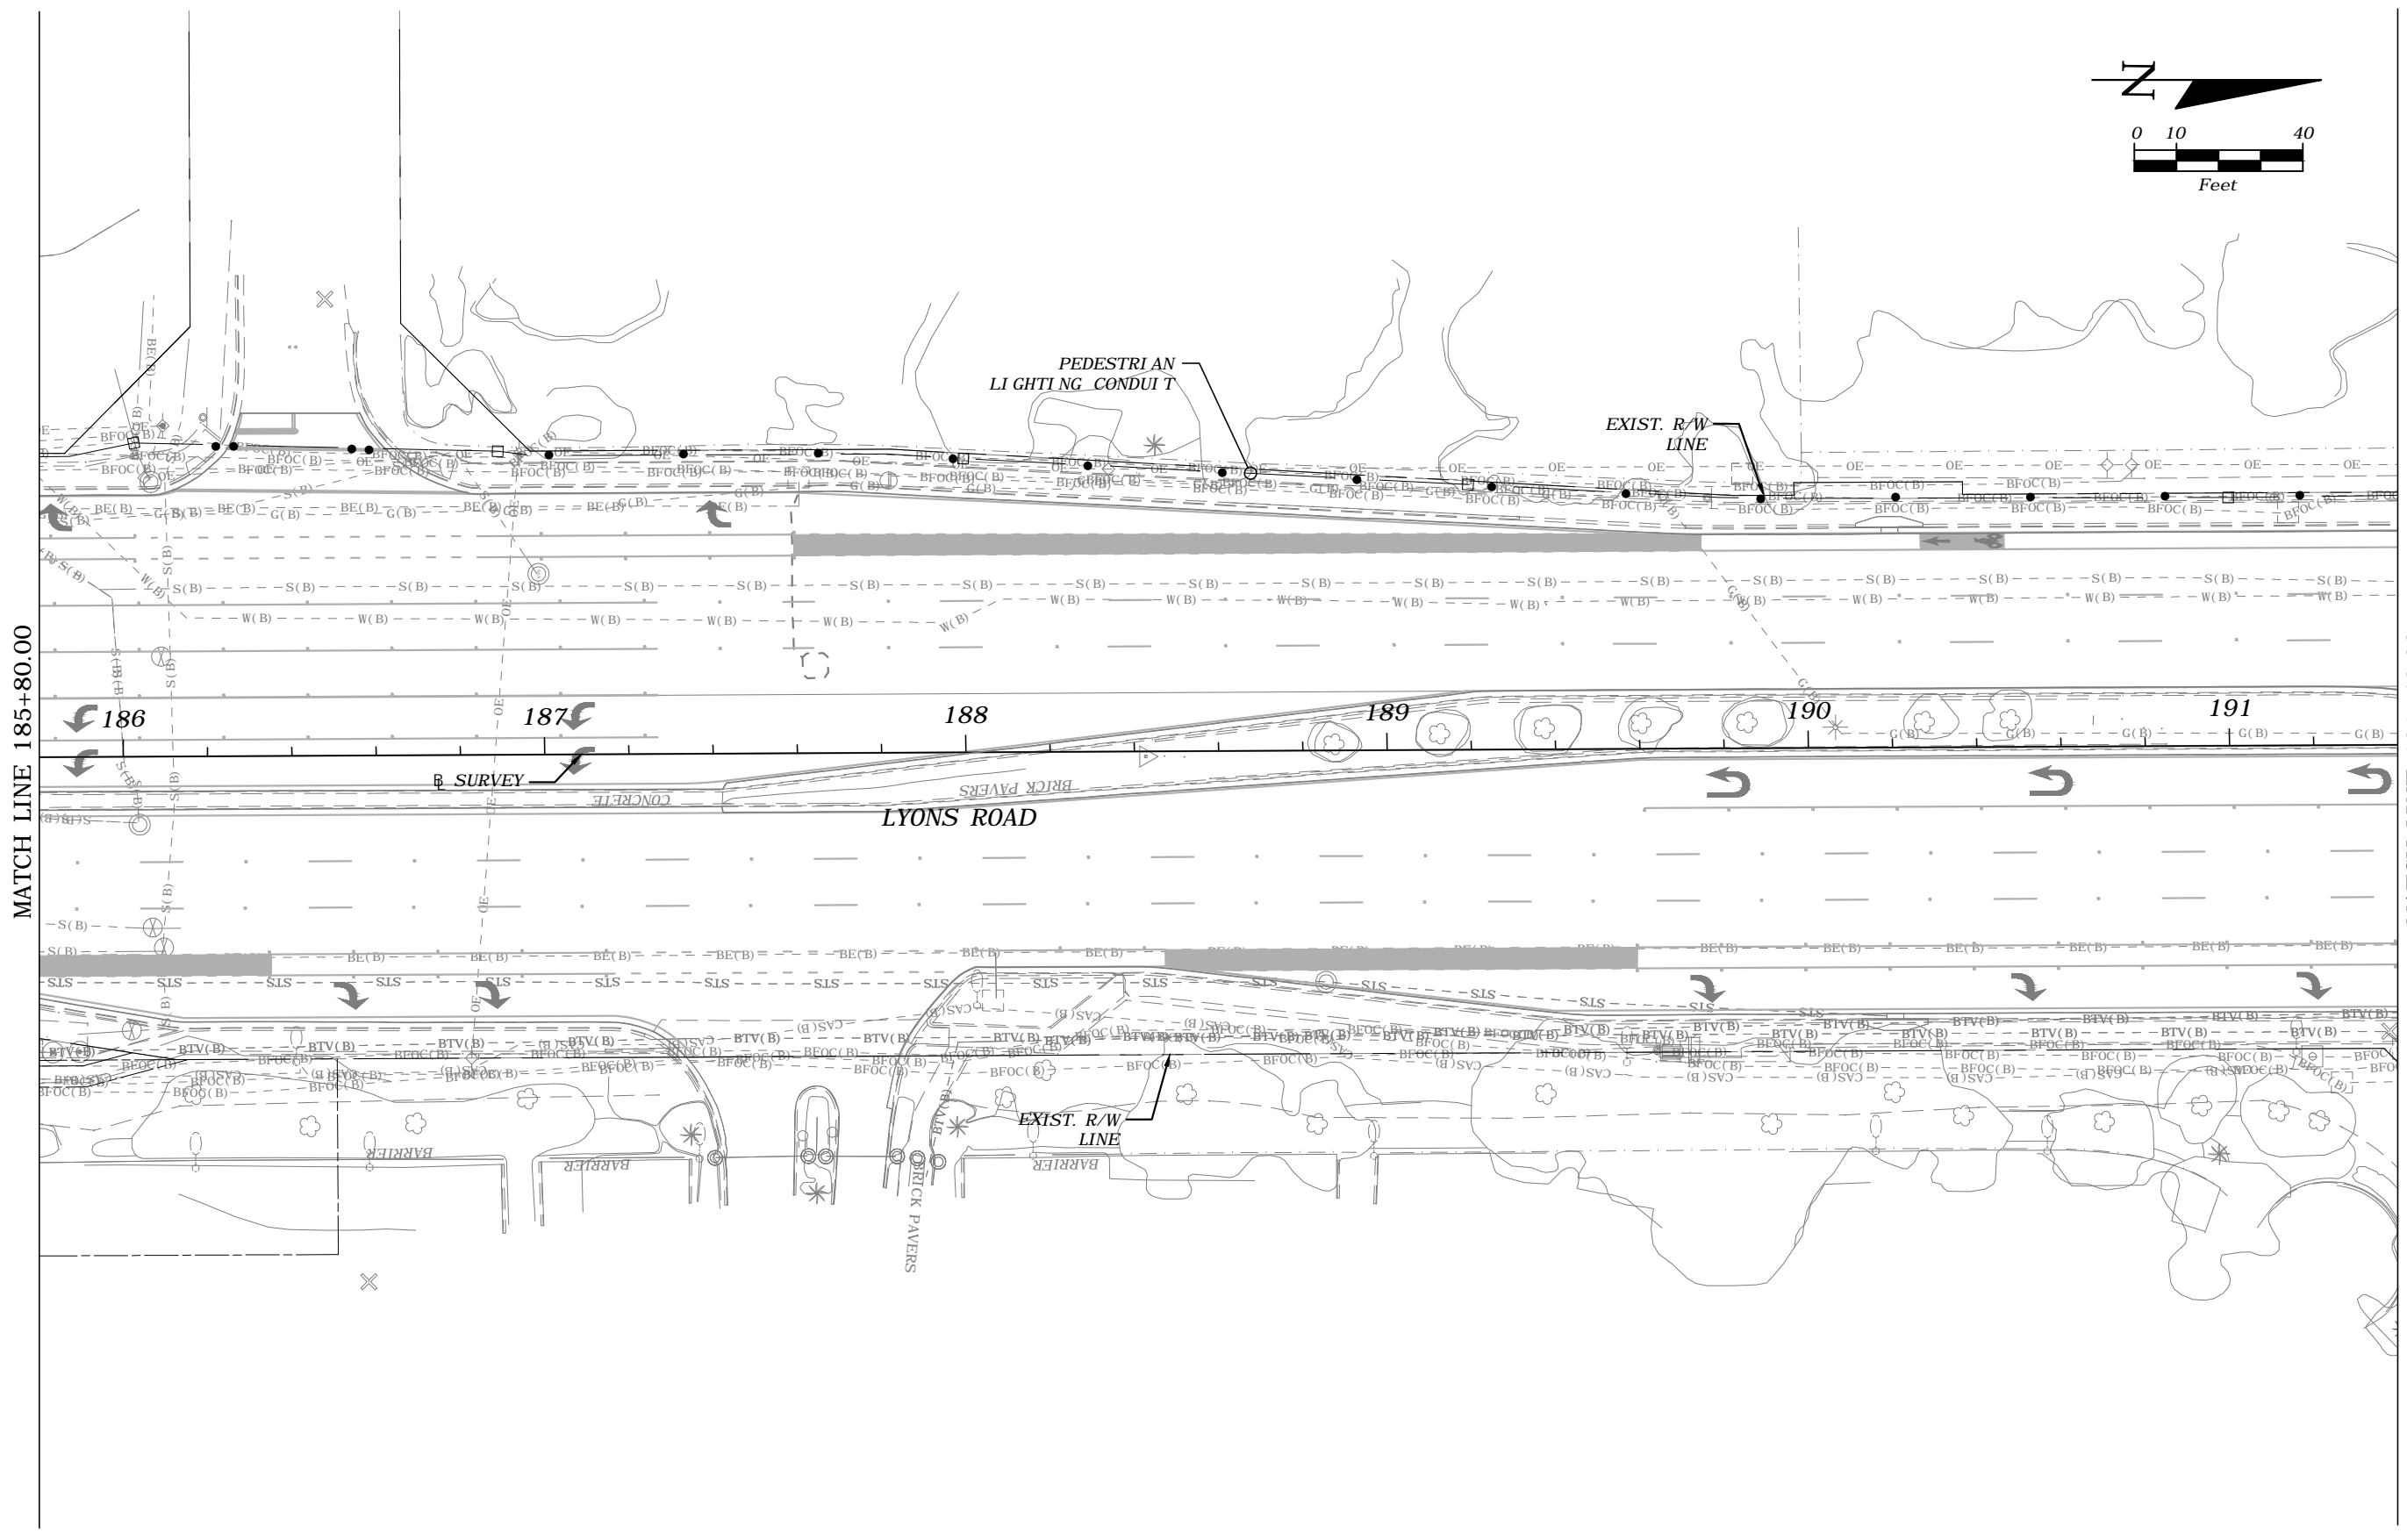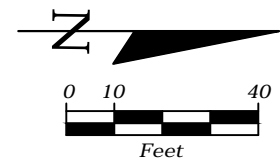

MATCH LINE 185+80.00


MATCH LINE 191+40.00

REVISIONS				FREDDIE A. VARGAS, P.E. P.E. LICENSE NUMBER 35941 CARNAHAN PROCTOR & CROSS, INC. 814 S. MILITARY TRAIL DEERFIELD BEACH, FL 33442 CERTIFICATE OF AUTHORIZATION 2936	STATE OF FLORIDA DEPARTMENT OF TRANSPORTATION			<i>PEDESTRIAN LIGHTING-CONDUIT          PLANS</i>	SHEET NO.  L-35
DATE	DESCRIPTION	DATE	DESCRIPTION		ROAD NO.	COUNTY	FINANCIAL PROJECT ID		
---	---	---	---						

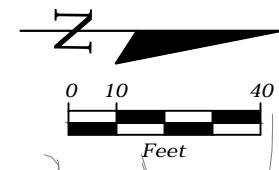

MATCH LINE 191+40.00

MATCH LINE 197+10.00

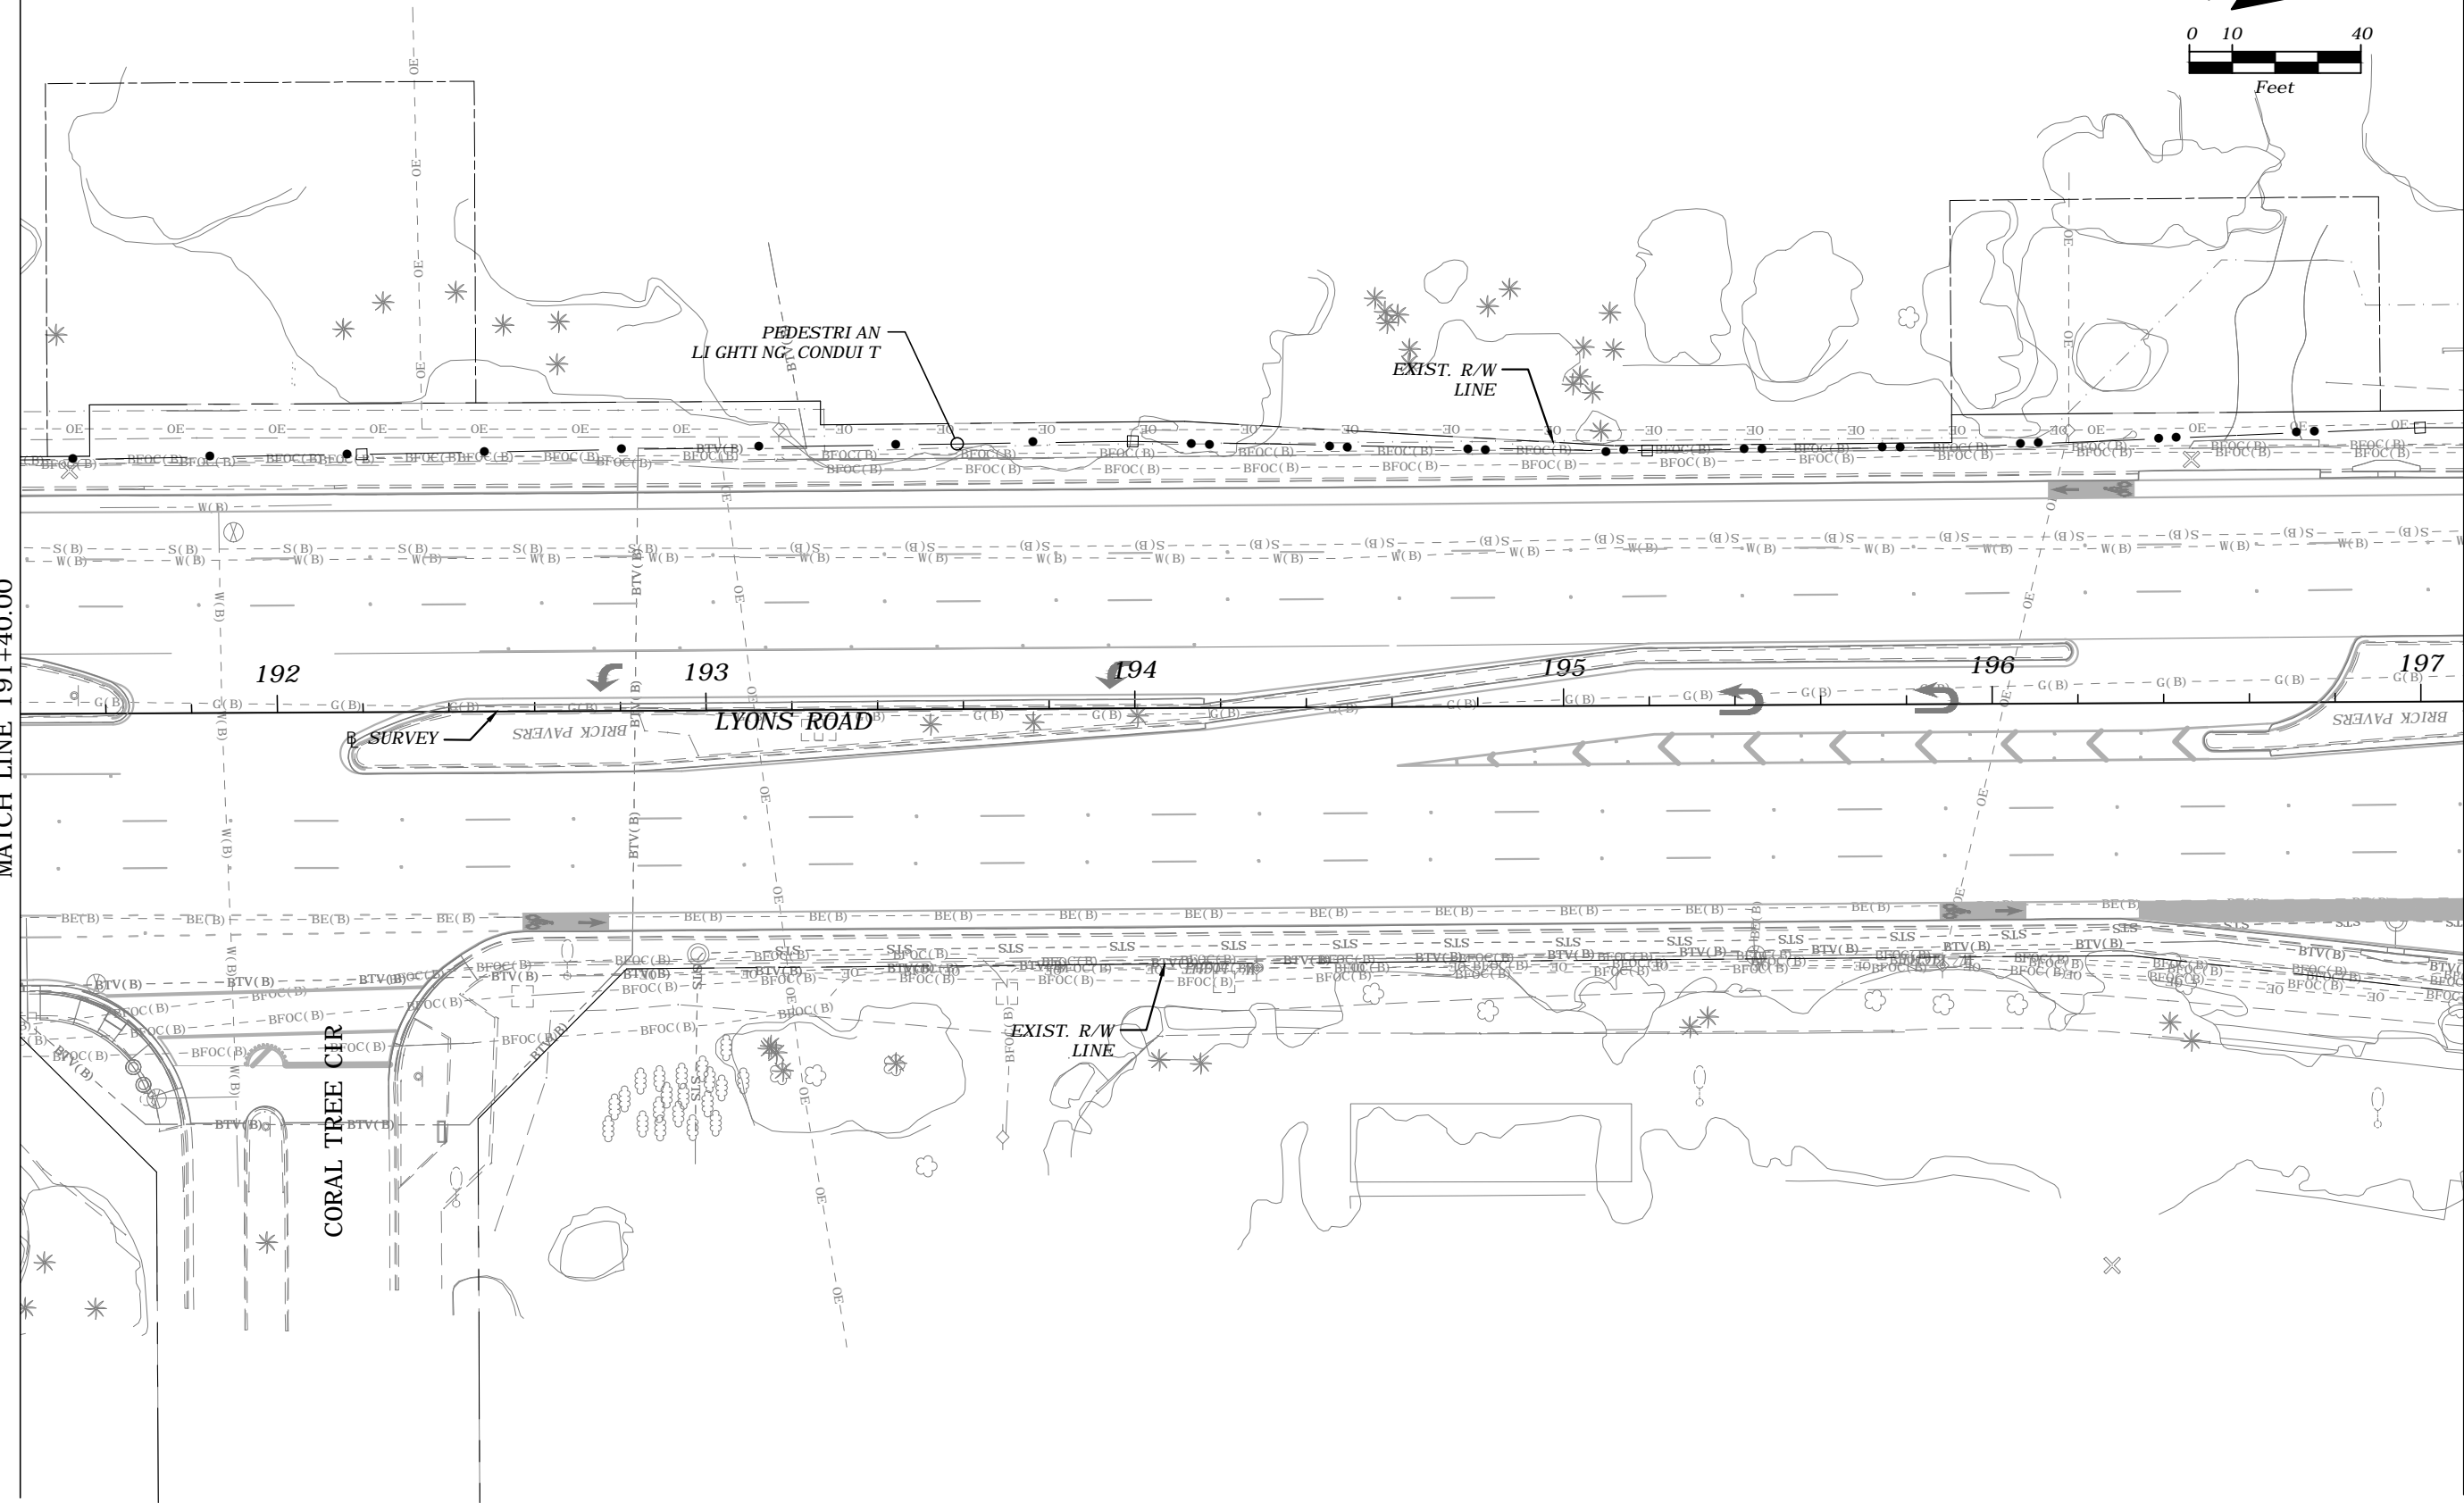

CORAL TREE CIR

PEDESTRIAN LIGHTING CONDUIT

EXIST. R/W LINE

EXIST. R/W LINE

192 193 194 195 196 197  
 SURVEY BRICK PAVERS LYONS ROAD BRICK PAVERS

REVISIONS			
DATE	DESCRIPTION	DATE	DESCRIPTION
---	---	---	---



FREDDIE A. VARGAS, P.E.  
 P.E. LICENSE NUMBER 35941  
 CARNAHAN PROCTOR & CROSS, INC.  
 814 S. MILITARY TRAIL  
 DEERFIELD BEACH, FL 33442  
 CERTIFICATE OF AUTHORIZATION 2936

STATE OF FLORIDA DEPARTMENT OF TRANSPORTATION		
ROAD NO.	COUNTY	FINANCIAL PROJECT ID
	BROWARD	436319-1-52-03

*PEDESTRIAN LIGHTING-CONDUIT  
 PLANS*

SHEET NO.  
L-36

THE OFFICIAL RECORD OF THIS SHEET IS THE ELECTRONIC FILE DIGITALLY SIGNED AND SEALED UNDER RULE 61G15-23.004, F.A.C.

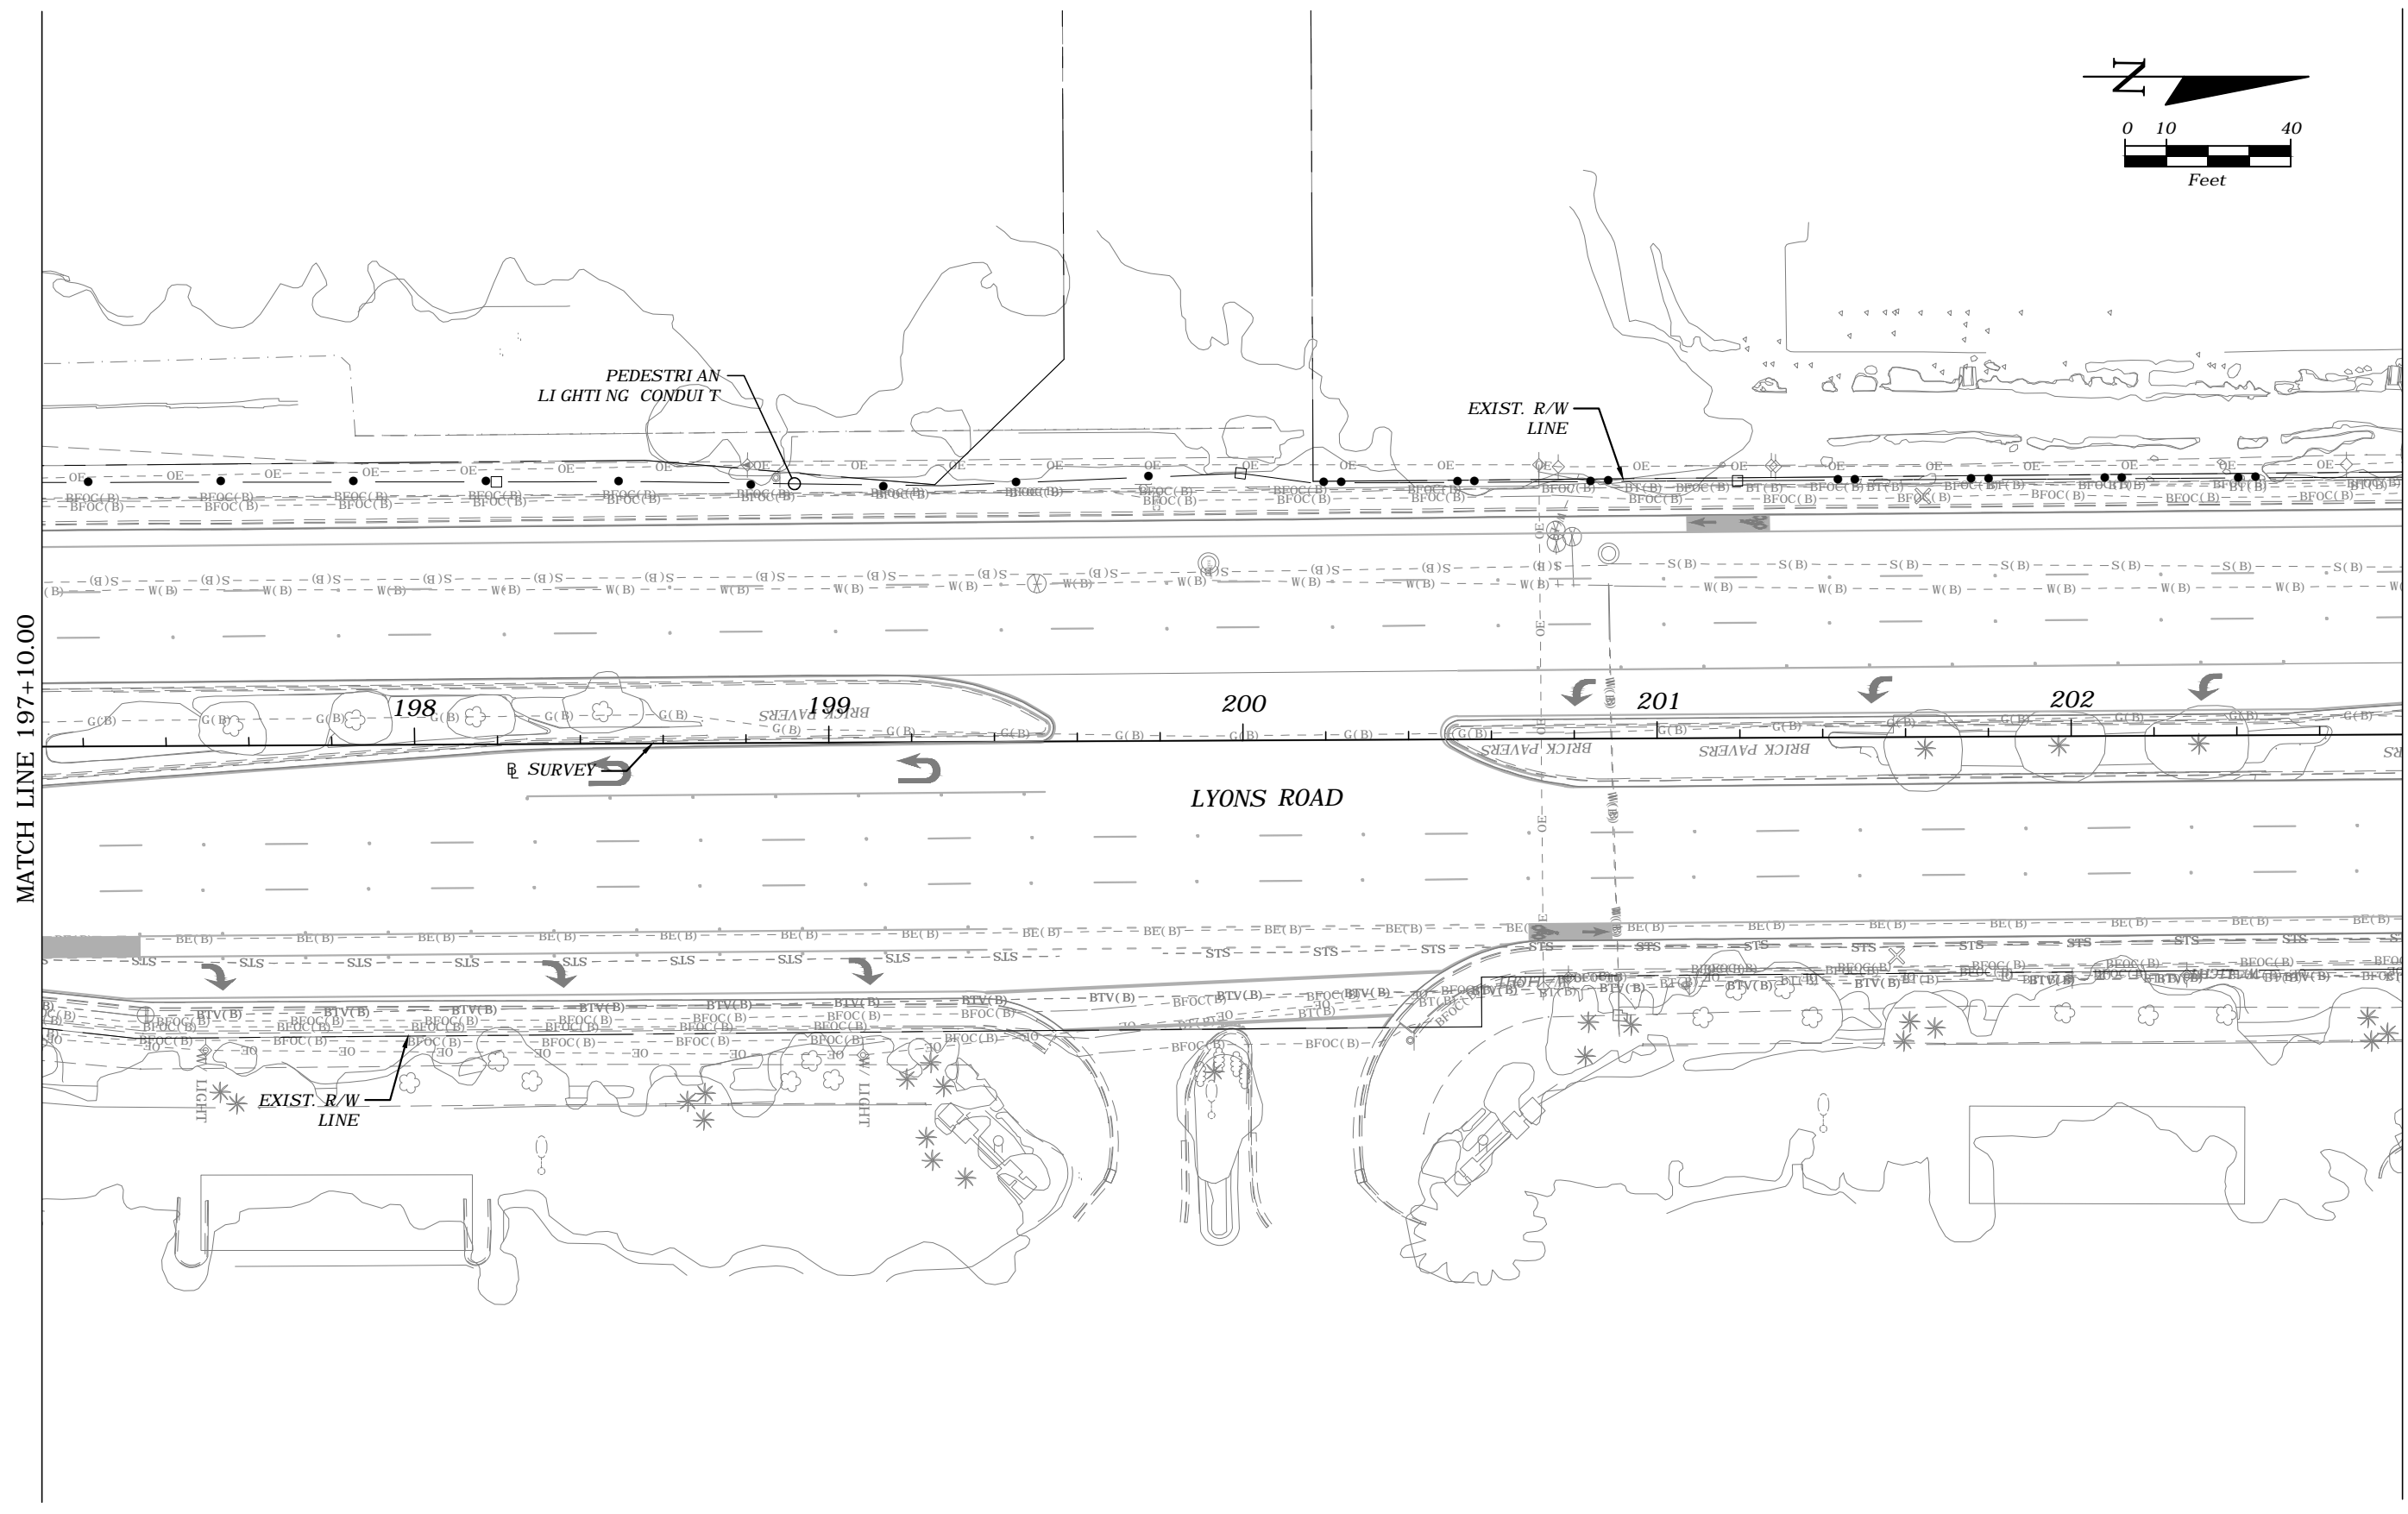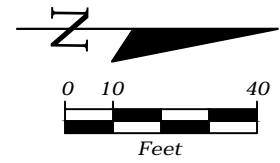

MATCH LINE 197+10.00

MATCH LINE 202+80.00



REVISIONS				FREDDIE A. VARGAS, P.E. P.E. LICENSE NUMBER 35941 CARNAHAN PROCTOR & CROSS, INC. 814 S. MILITARY TRAIL DEERFIELD BEACH, FL 33442 CERTIFICATE OF AUTHORIZATION 2936	STATE OF FLORIDA DEPARTMENT OF TRANSPORTATION			<i>PEDESTRIAN LIGHTING-CONDUIT          PLANS</i>	SHEET NO.  L-37
DATE	DESCRIPTION	DATE	DESCRIPTION		ROAD NO.	COUNTY	FINANCIAL PROJECT ID		
---	---								

Terence Castillo

6/4/2019 12:39:48 PM

P:\projects\181201 - Pedestrian Light Features\43631915201\PLANLT02.dwg

THE OFFICIAL RECORD OF THIS SHEET IS THE ELECTRONIC FILE DIGITALLY SIGNED AND SEALED UNDER RULE 61G15-23.004, F.A.C.

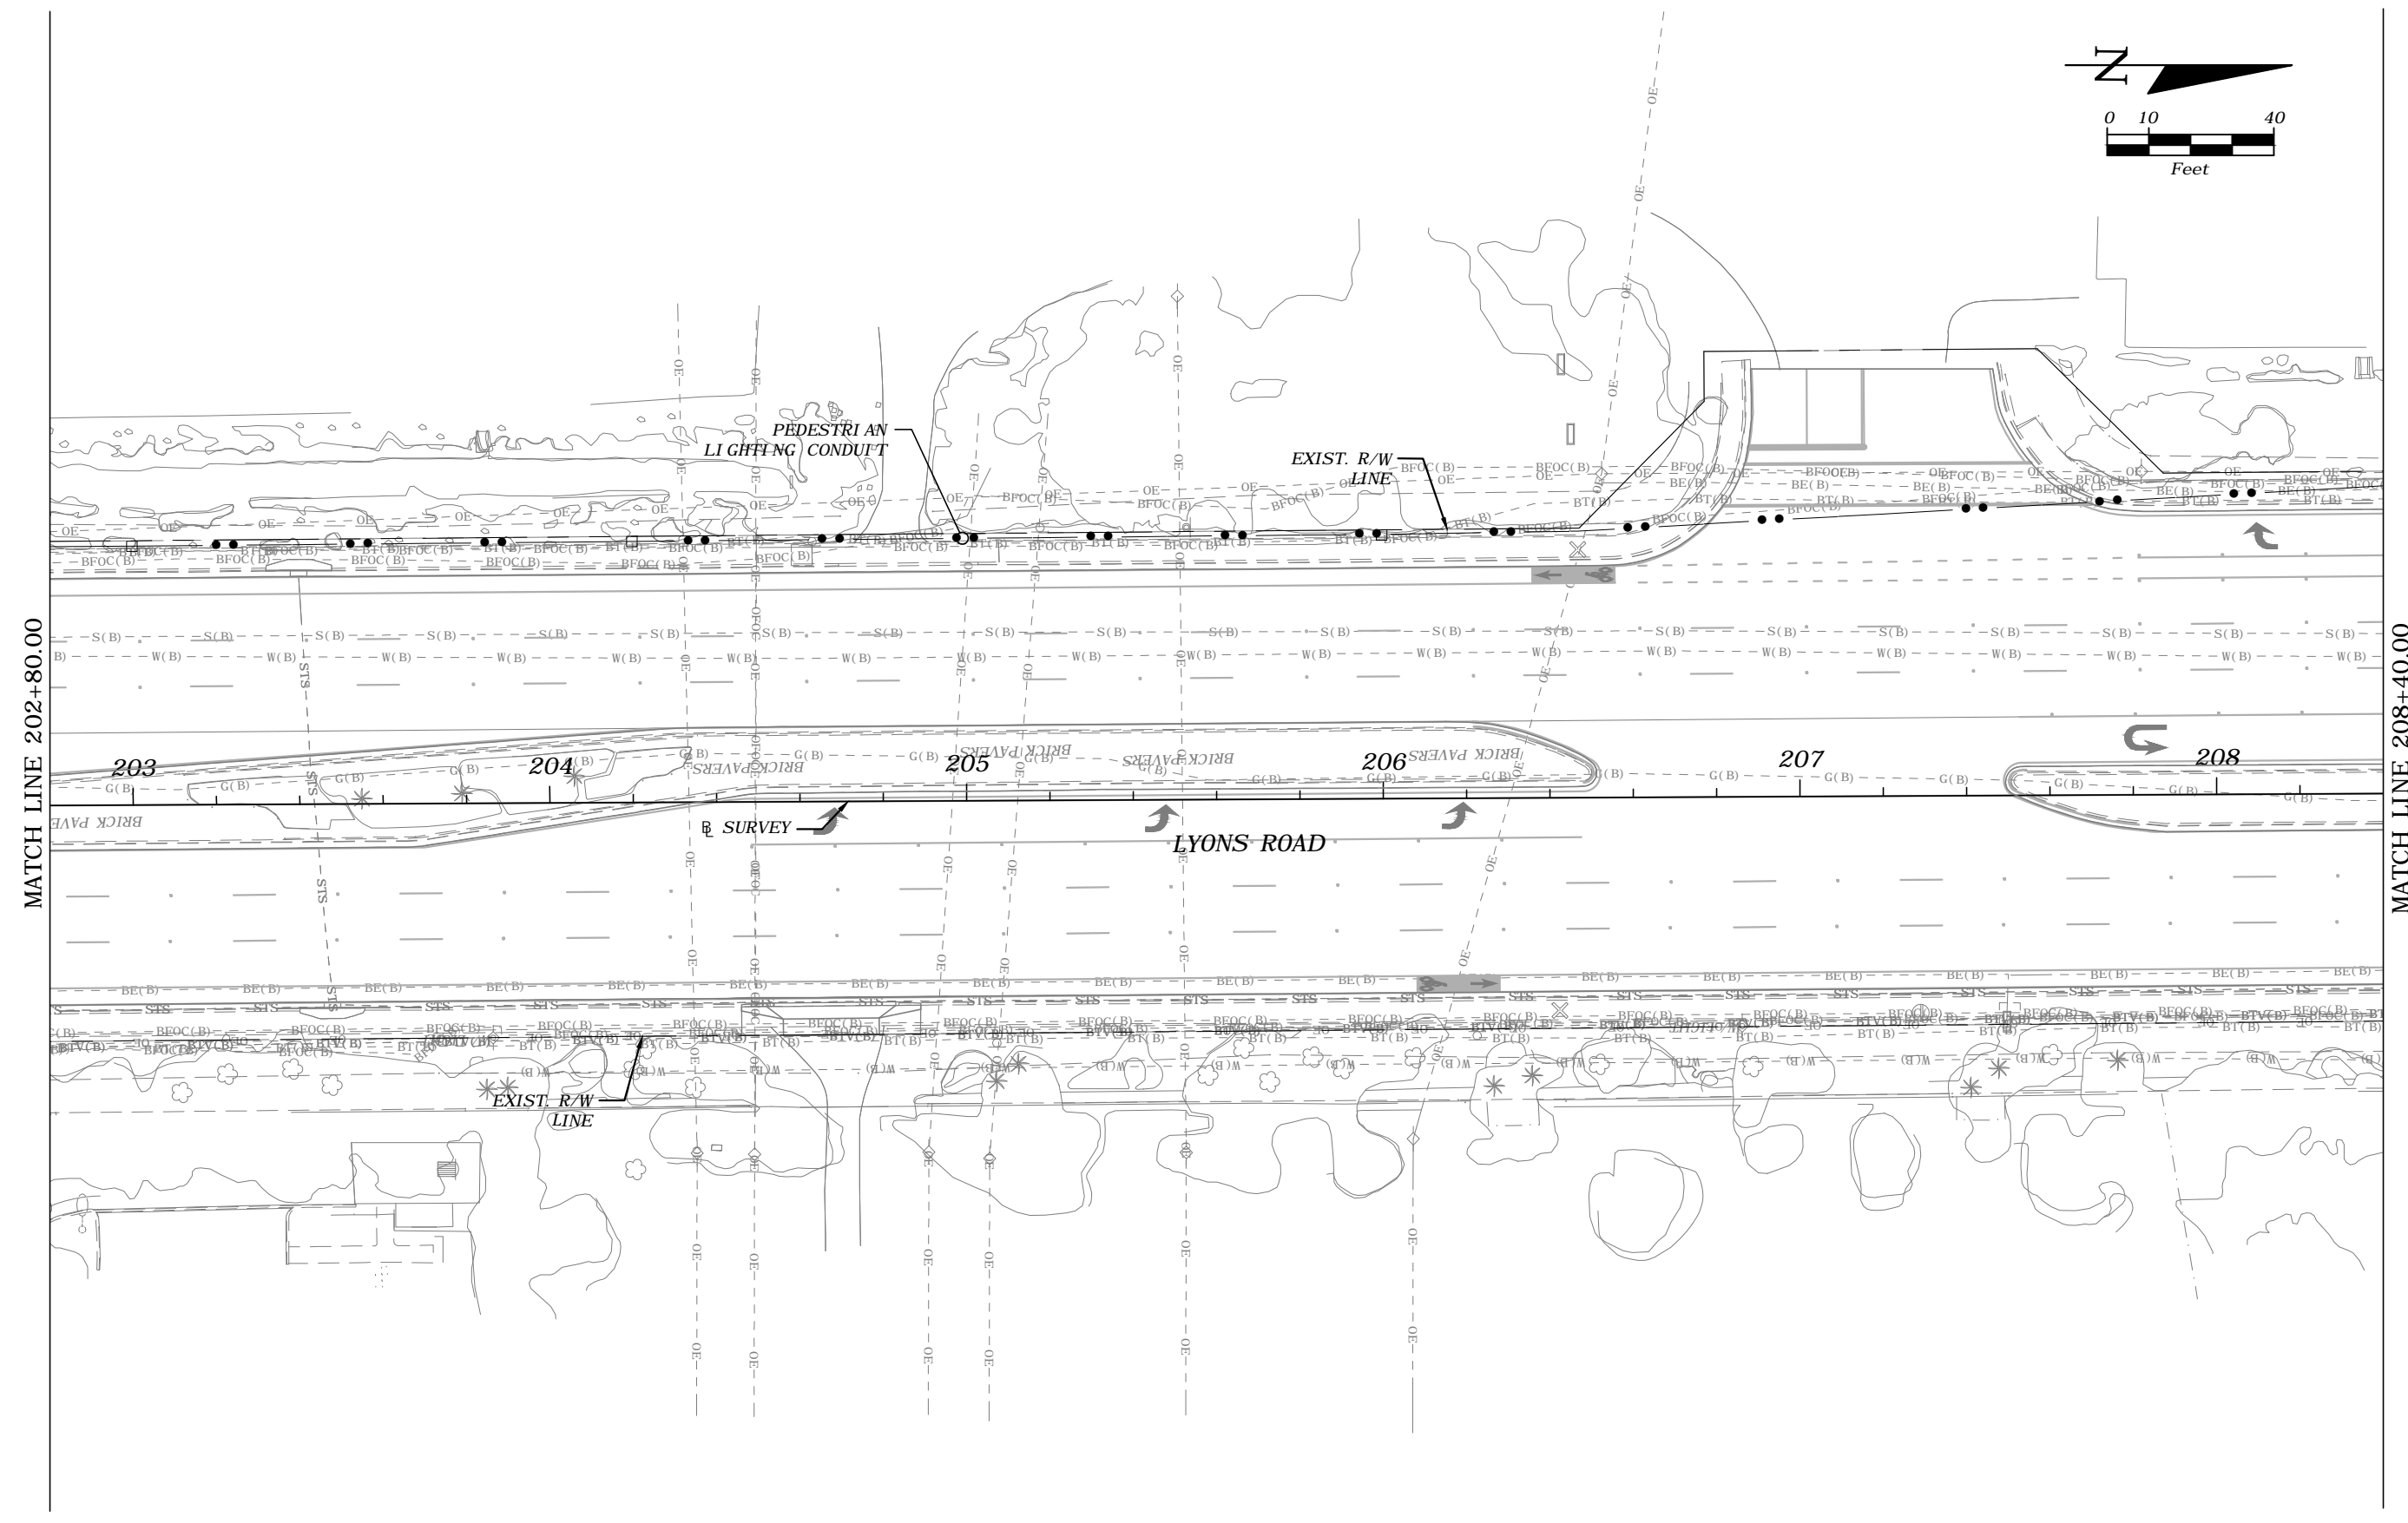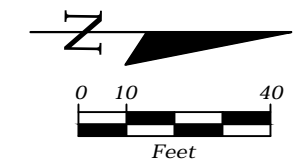

MATCH LINE 202+80.00

MATCH LINE 208+40.00



REVISIONS				FREDDIE A. VARGAS, P.E. P.E. LICENSE NUMBER 35941 CARNAHAN PROCTOR & CROSS, INC. 814 S. MILITARY TRAIL DEERFIELD BEACH, FL 33442 CERTIFICATE OF AUTHORIZATION 2936	STATE OF FLORIDA DEPARTMENT OF TRANSPORTATION			<i>PEDESTRIAN LIGHTING-CONDUIT          PLANS</i>	SHEET NO.  L-38
DATE	DESCRIPTION	DATE	DESCRIPTION		ROAD NO.	COUNTY	FINANCIAL PROJECT ID		
---	---	---	---		BROWARD	436319-1-52-03			

Terence Castillo

6/4/2019 12:40:03 PM

P:\projects\181201 - Pedestrian Light Features\43631915201\PLANLT02.dwg

THE OFFICIAL RECORD OF THIS SHEET IS THE ELECTRONIC FILE DIGITALLY SIGNED AND SEALED UNDER RULE 61G15-23.004, F.A.C.

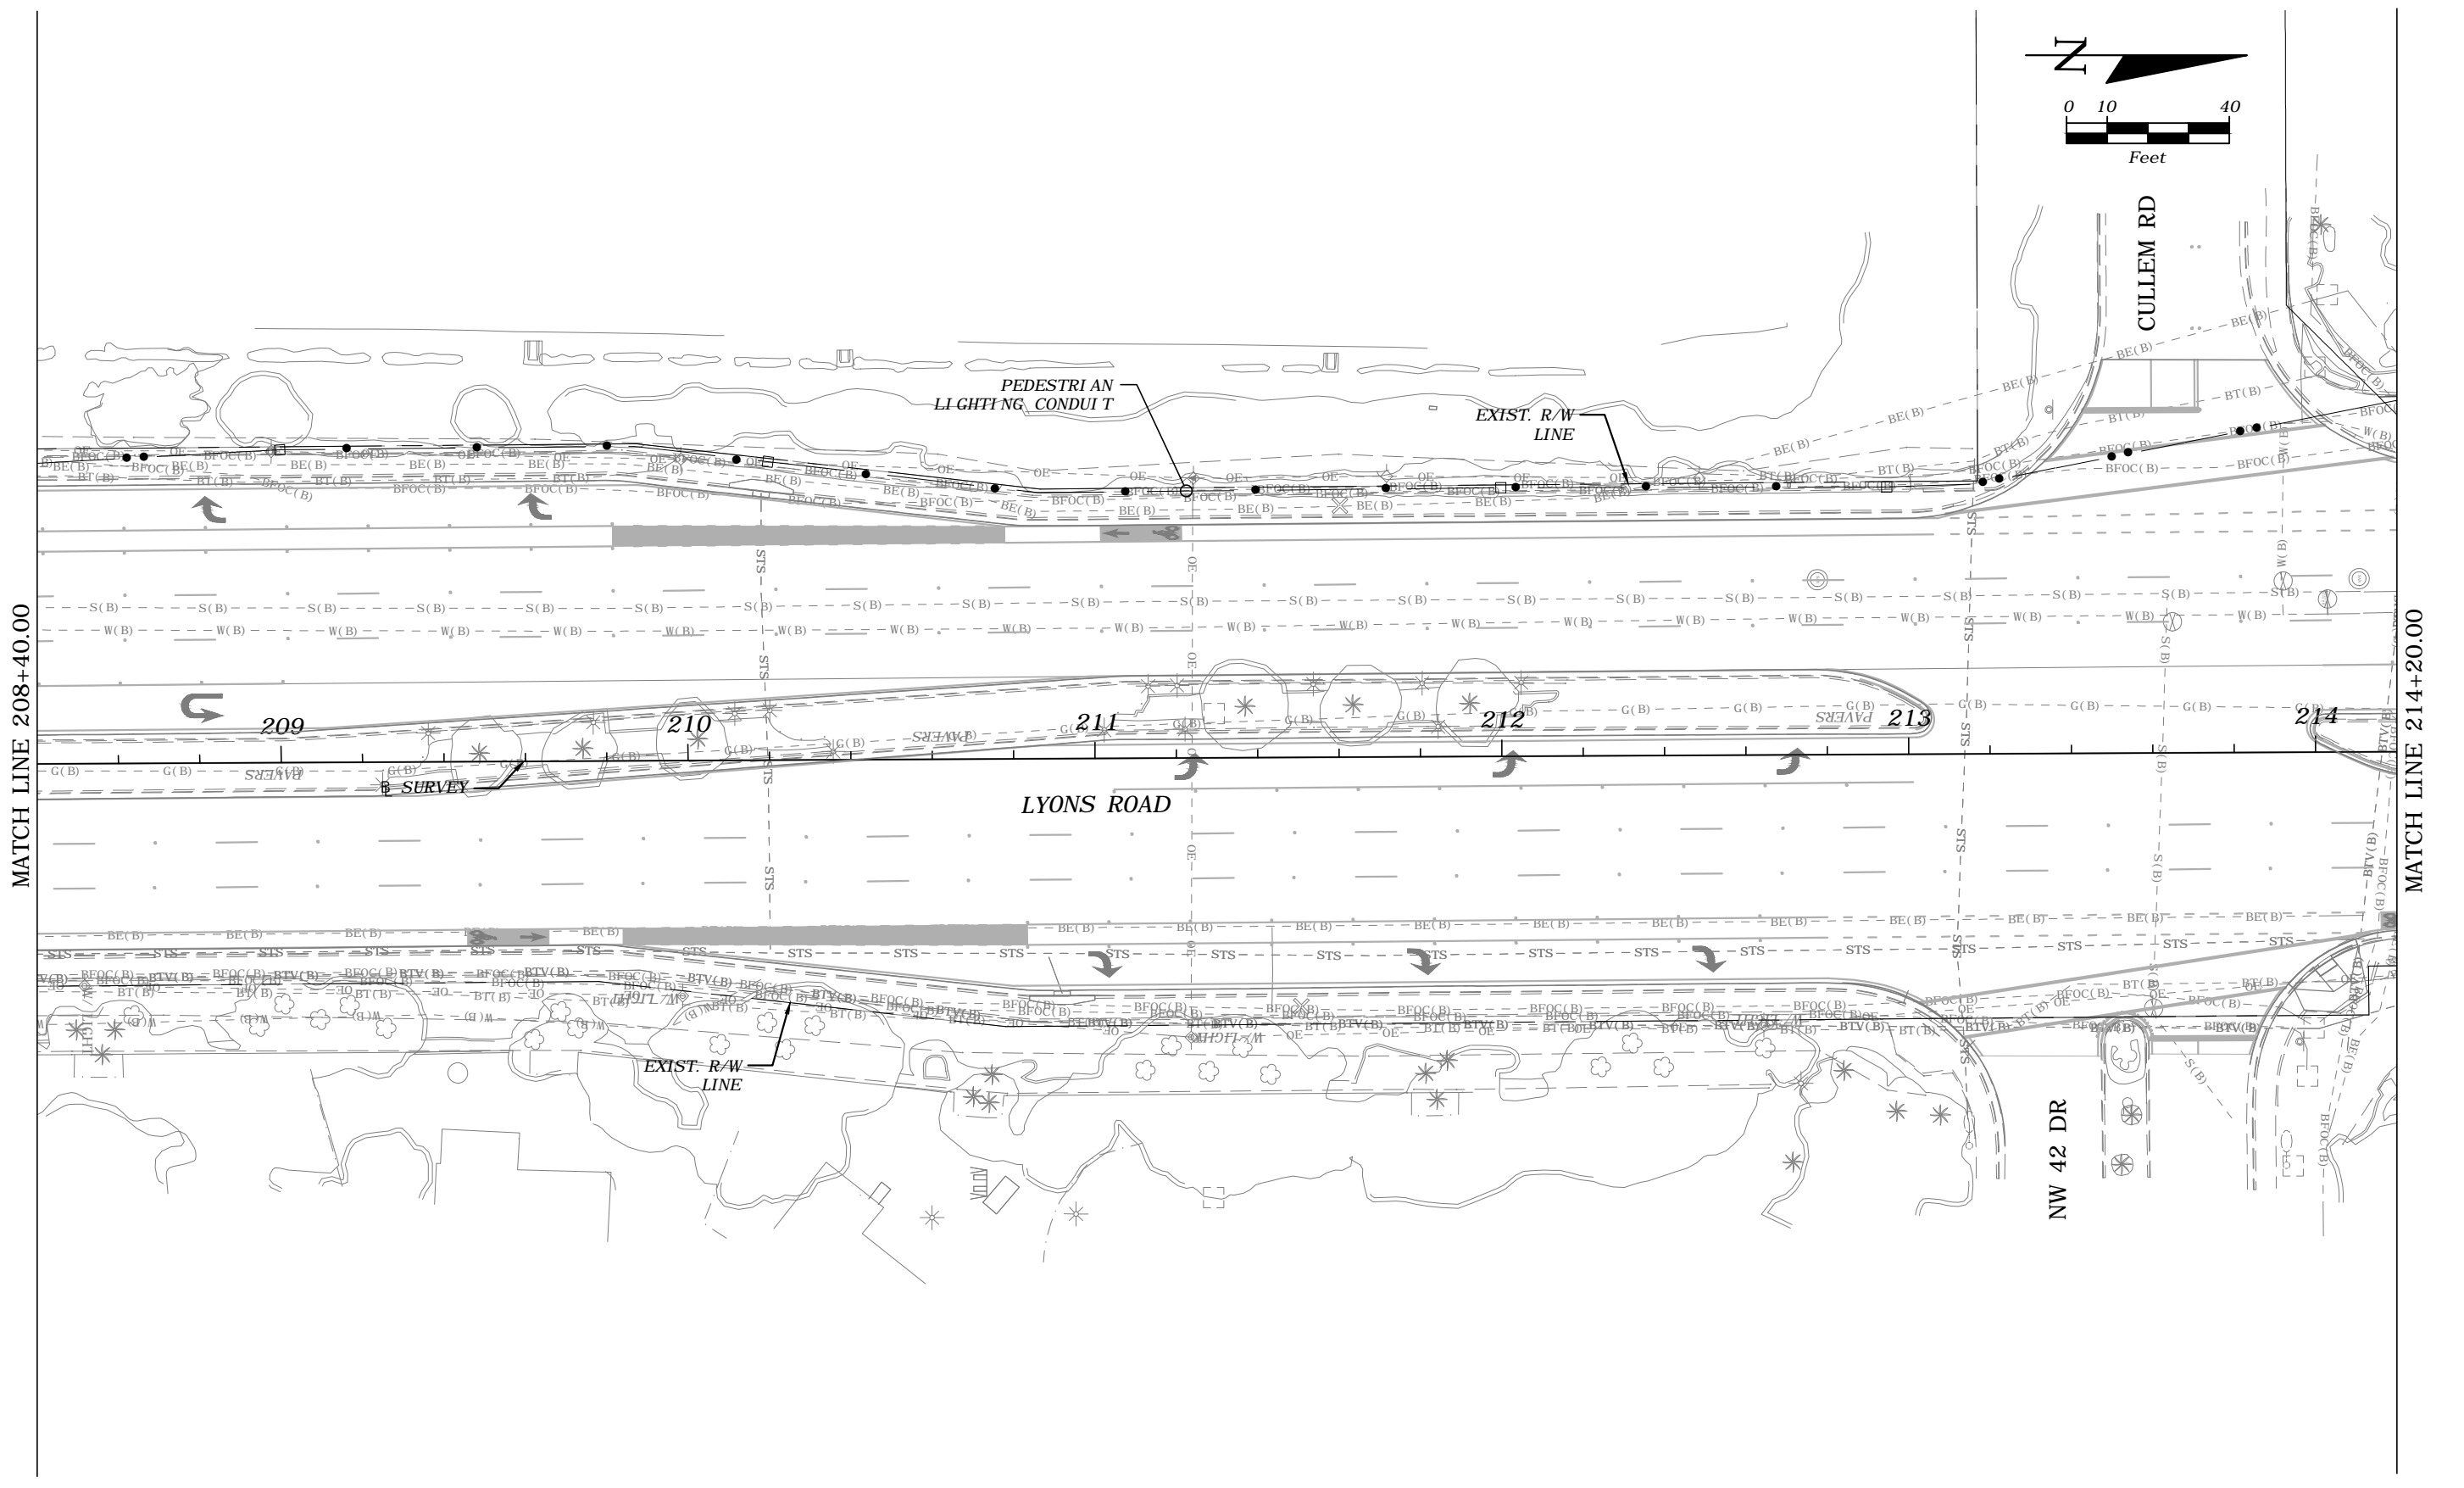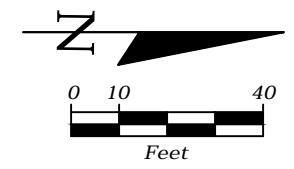

REVISIONS			
DATE	DESCRIPTION	DATE	DESCRIPTION
---	---	---	---



FREDDIE A. VARGAS, P.E.  
P.E. LICENSE NUMBER 35941  
CARNAHAN PROCTOR & CROSS, INC.  
814 S. MILITARY TRAIL  
DEERFIELD BEACH, FL 33442  
CERTIFICATE OF AUTHORIZATION 2936

STATE OF FLORIDA DEPARTMENT OF TRANSPORTATION		
ROAD NO.	COUNTY	FINANCIAL PROJECT ID
	BROWARD	436319-1-52-03

*PEDESTRIAN LIGHTING-CONDUIT  
PLANS*

SHEET NO.  
L-39

THE OFFICIAL RECORD OF THIS SHEET IS THE ELECTRONIC FILE DIGITALLY SIGNED AND SEALED UNDER RULE 61G15-23.004, F.A.C.

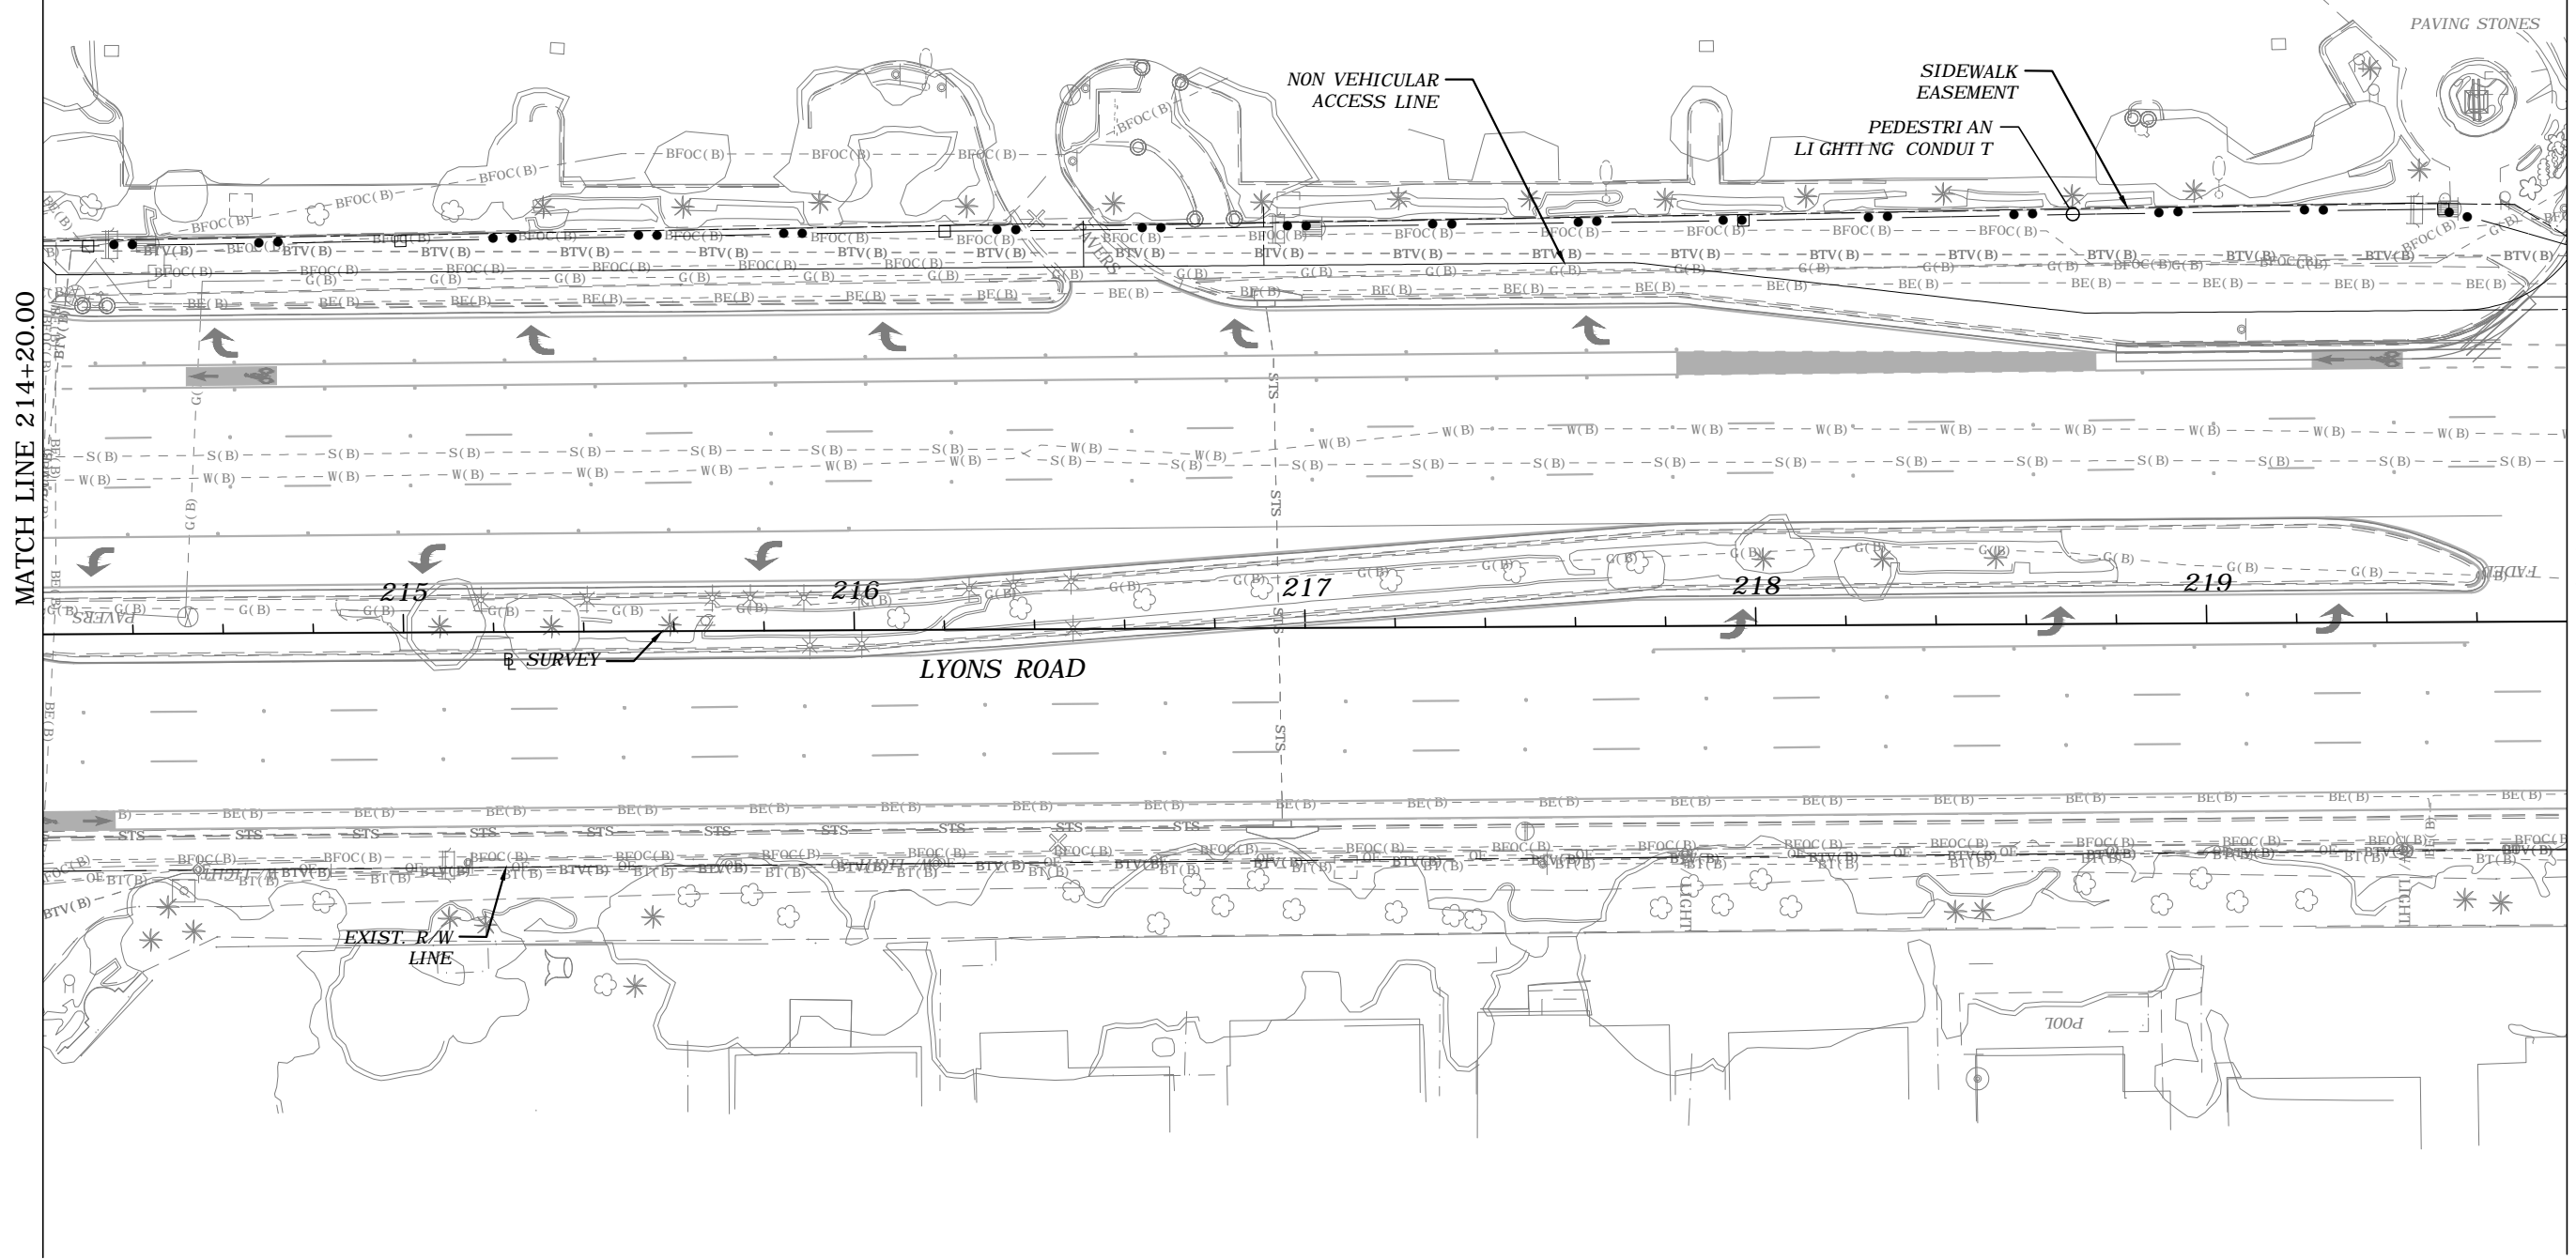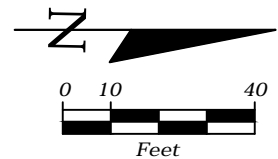

REVISIONS				FREDDIE A. VARGAS, P.E. P.E. LICENSE NUMBER 35941 CARNAHAN PROCTOR & CROSS, INC. 814 S. MILITARY TRAIL DEERFIELD BEACH, FL 33442 CERTIFICATE OF AUTHORIZATION 2936	STATE OF FLORIDA DEPARTMENT OF TRANSPORTATION			<i>PEDESTRIAN LIGHTING-CONDUIT          PLANS</i>	SHEET NO.  L-40
DATE	DESCRIPTION	DATE	DESCRIPTION		ROAD NO.	COUNTY	FINANCIAL PROJECT ID		
---	---	---	---		BROWARD	436319-1-52-03			



Terence Castillo

6/4/2019 12:40:33 PM

P:\projects\181201 - Pedestrian Light Features\43631915201\PLANLT02.dwg



THE OFFICIAL RECORD OF THIS SHEET IS THE ELECTRONIC FILE DIGITALLY SIGNED AND SEALED UNDER RULE 61G15-23.004, F.A.C.



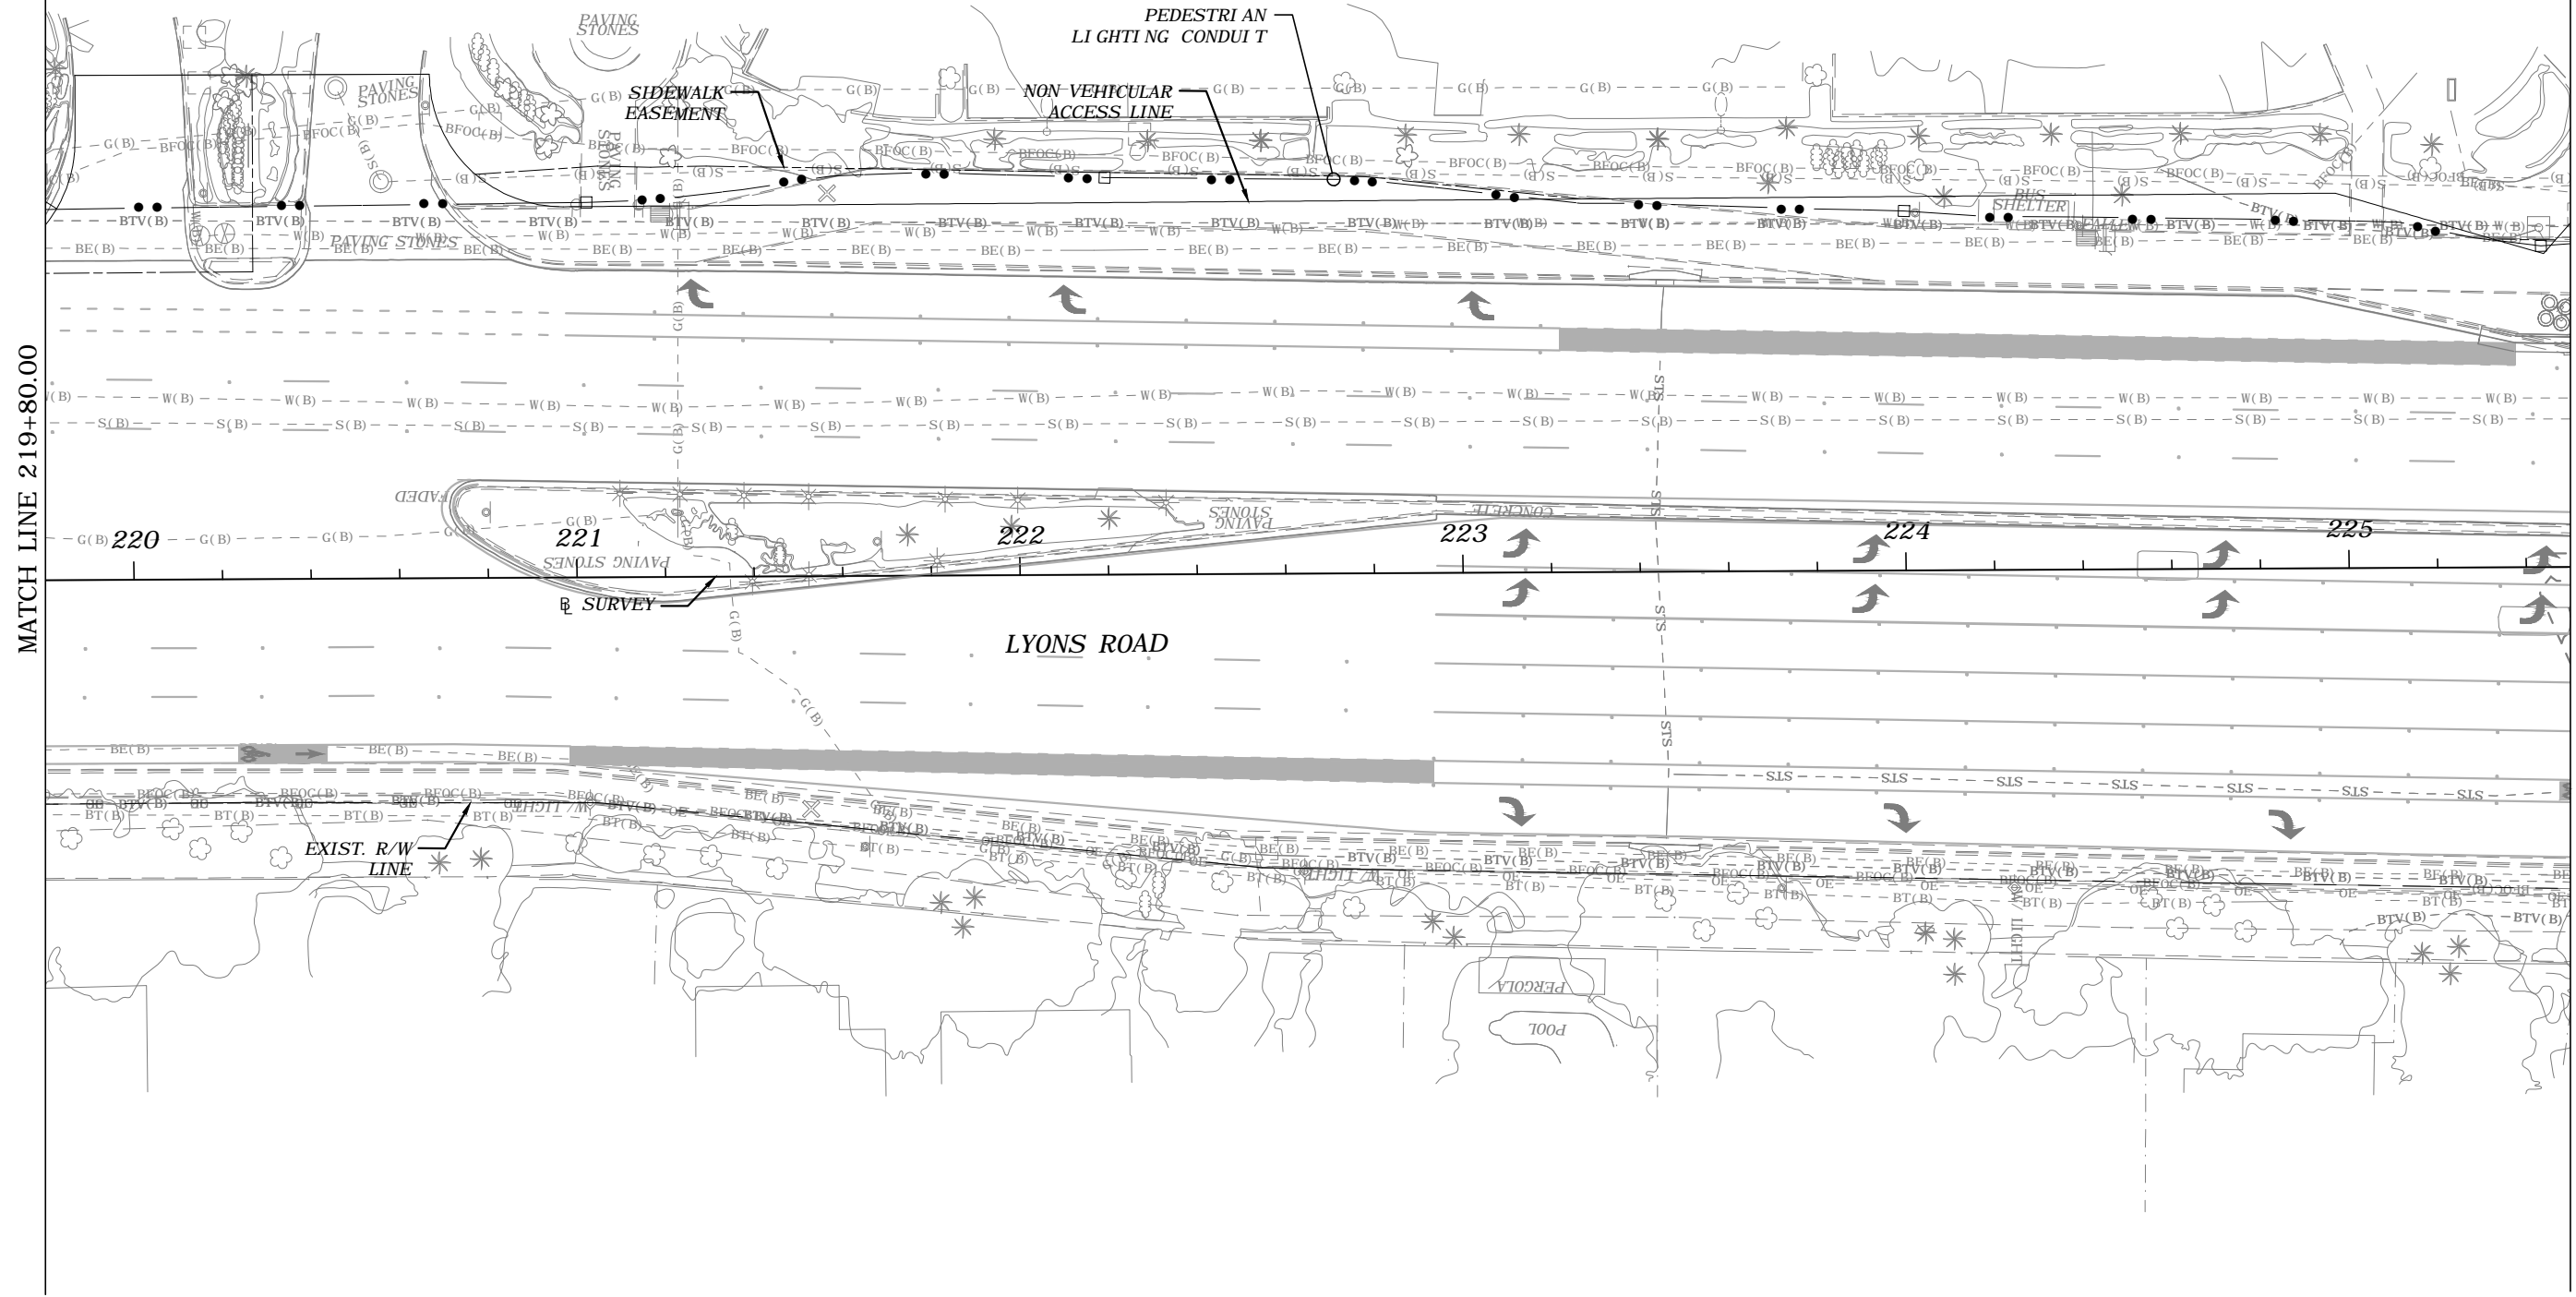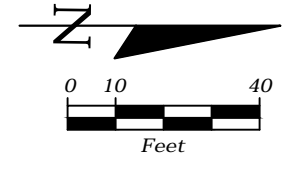

REVISIONS				FREDDIE A. VARGAS, P.E. P.E. LICENSE NUMBER 35941 CARNAHAN PROCTOR & CROSS, INC. 814 S. MILITARY TRAIL DEERFIELD BEACH, FL 33442 CERTIFICATE OF AUTHORIZATION 2936	STATE OF FLORIDA DEPARTMENT OF TRANSPORTATION			PEDESTRIAN LIGHTING-CONDUIT PLANS	SHEET NO.  L-41
DATE	DESCRIPTION	DATE	DESCRIPTION		ROAD NO.	COUNTY	FINANCIAL PROJECT ID		
---	---	---	---		BROWARD	436319-1-52-03			

THE OFFICIAL RECORD OF THIS SHEET IS THE ELECTRONIC FILE DIGITALLY SIGNED AND SEALED UNDER RULE 61G15-23.004, F.A.C.

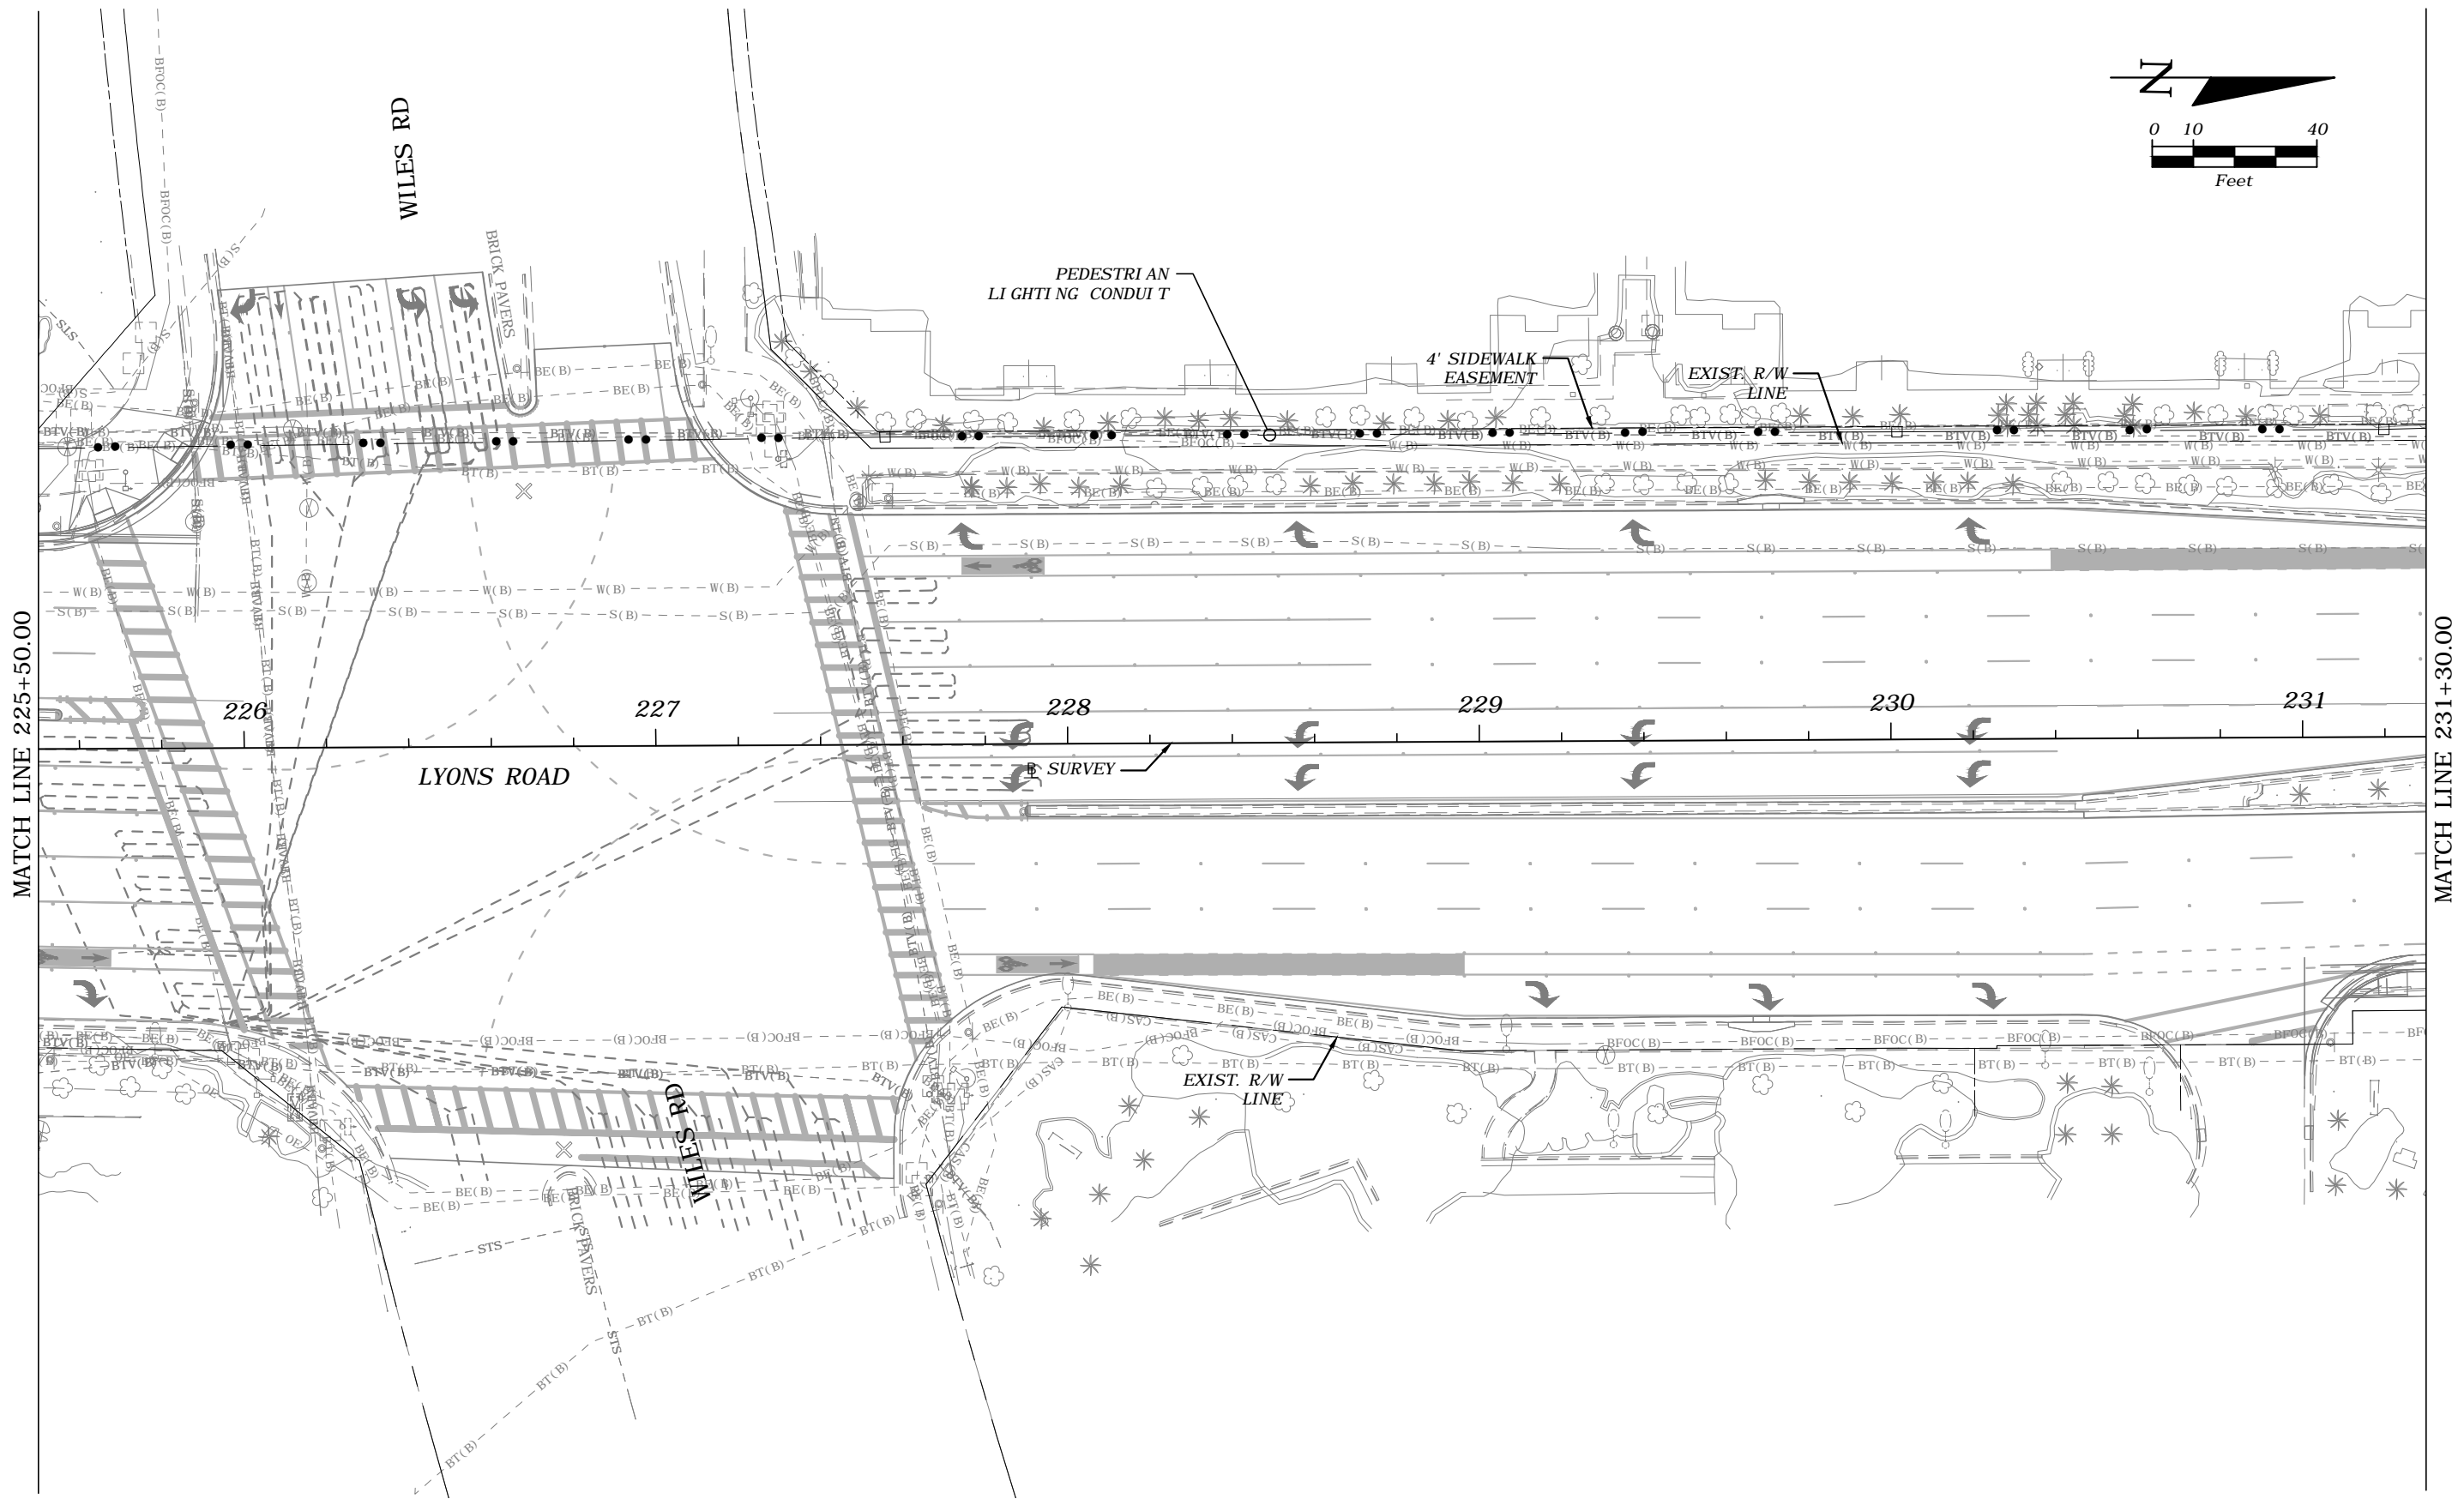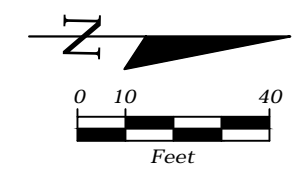

MATCH LINE 225+50.00

MATCH LINE 231+30.00

REVISIONS			
DATE	DESCRIPTION	DATE	DESCRIPTION
---	---	---	---



FREDDIE A. VARGAS, P.E.  
 P.E. LICENSE NUMBER 35941  
 CARNAHAN PROCTOR & CROSS, INC.  
 814 S. MILITARY TRAIL  
 DEERFIELD BEACH, FL 33442  
 CERTIFICATE OF AUTHORIZATION 2936

<b>STATE OF FLORIDA</b> <b>DEPARTMENT OF TRANSPORTATION</b>		
ROAD NO.	COUNTY	FINANCIAL PROJECT ID
	BROWARD	436319-1-52-03

***PEDESTRIAN LIGHTING-CONDUIT***  
***PLANS***

SHEET NO.  
**L-42**

THE OFFICIAL RECORD OF THIS SHEET IS THE ELECTRONIC FILE DIGITALLY SIGNED AND SEALED UNDER RULE 61G15-23.004, F.A.C.

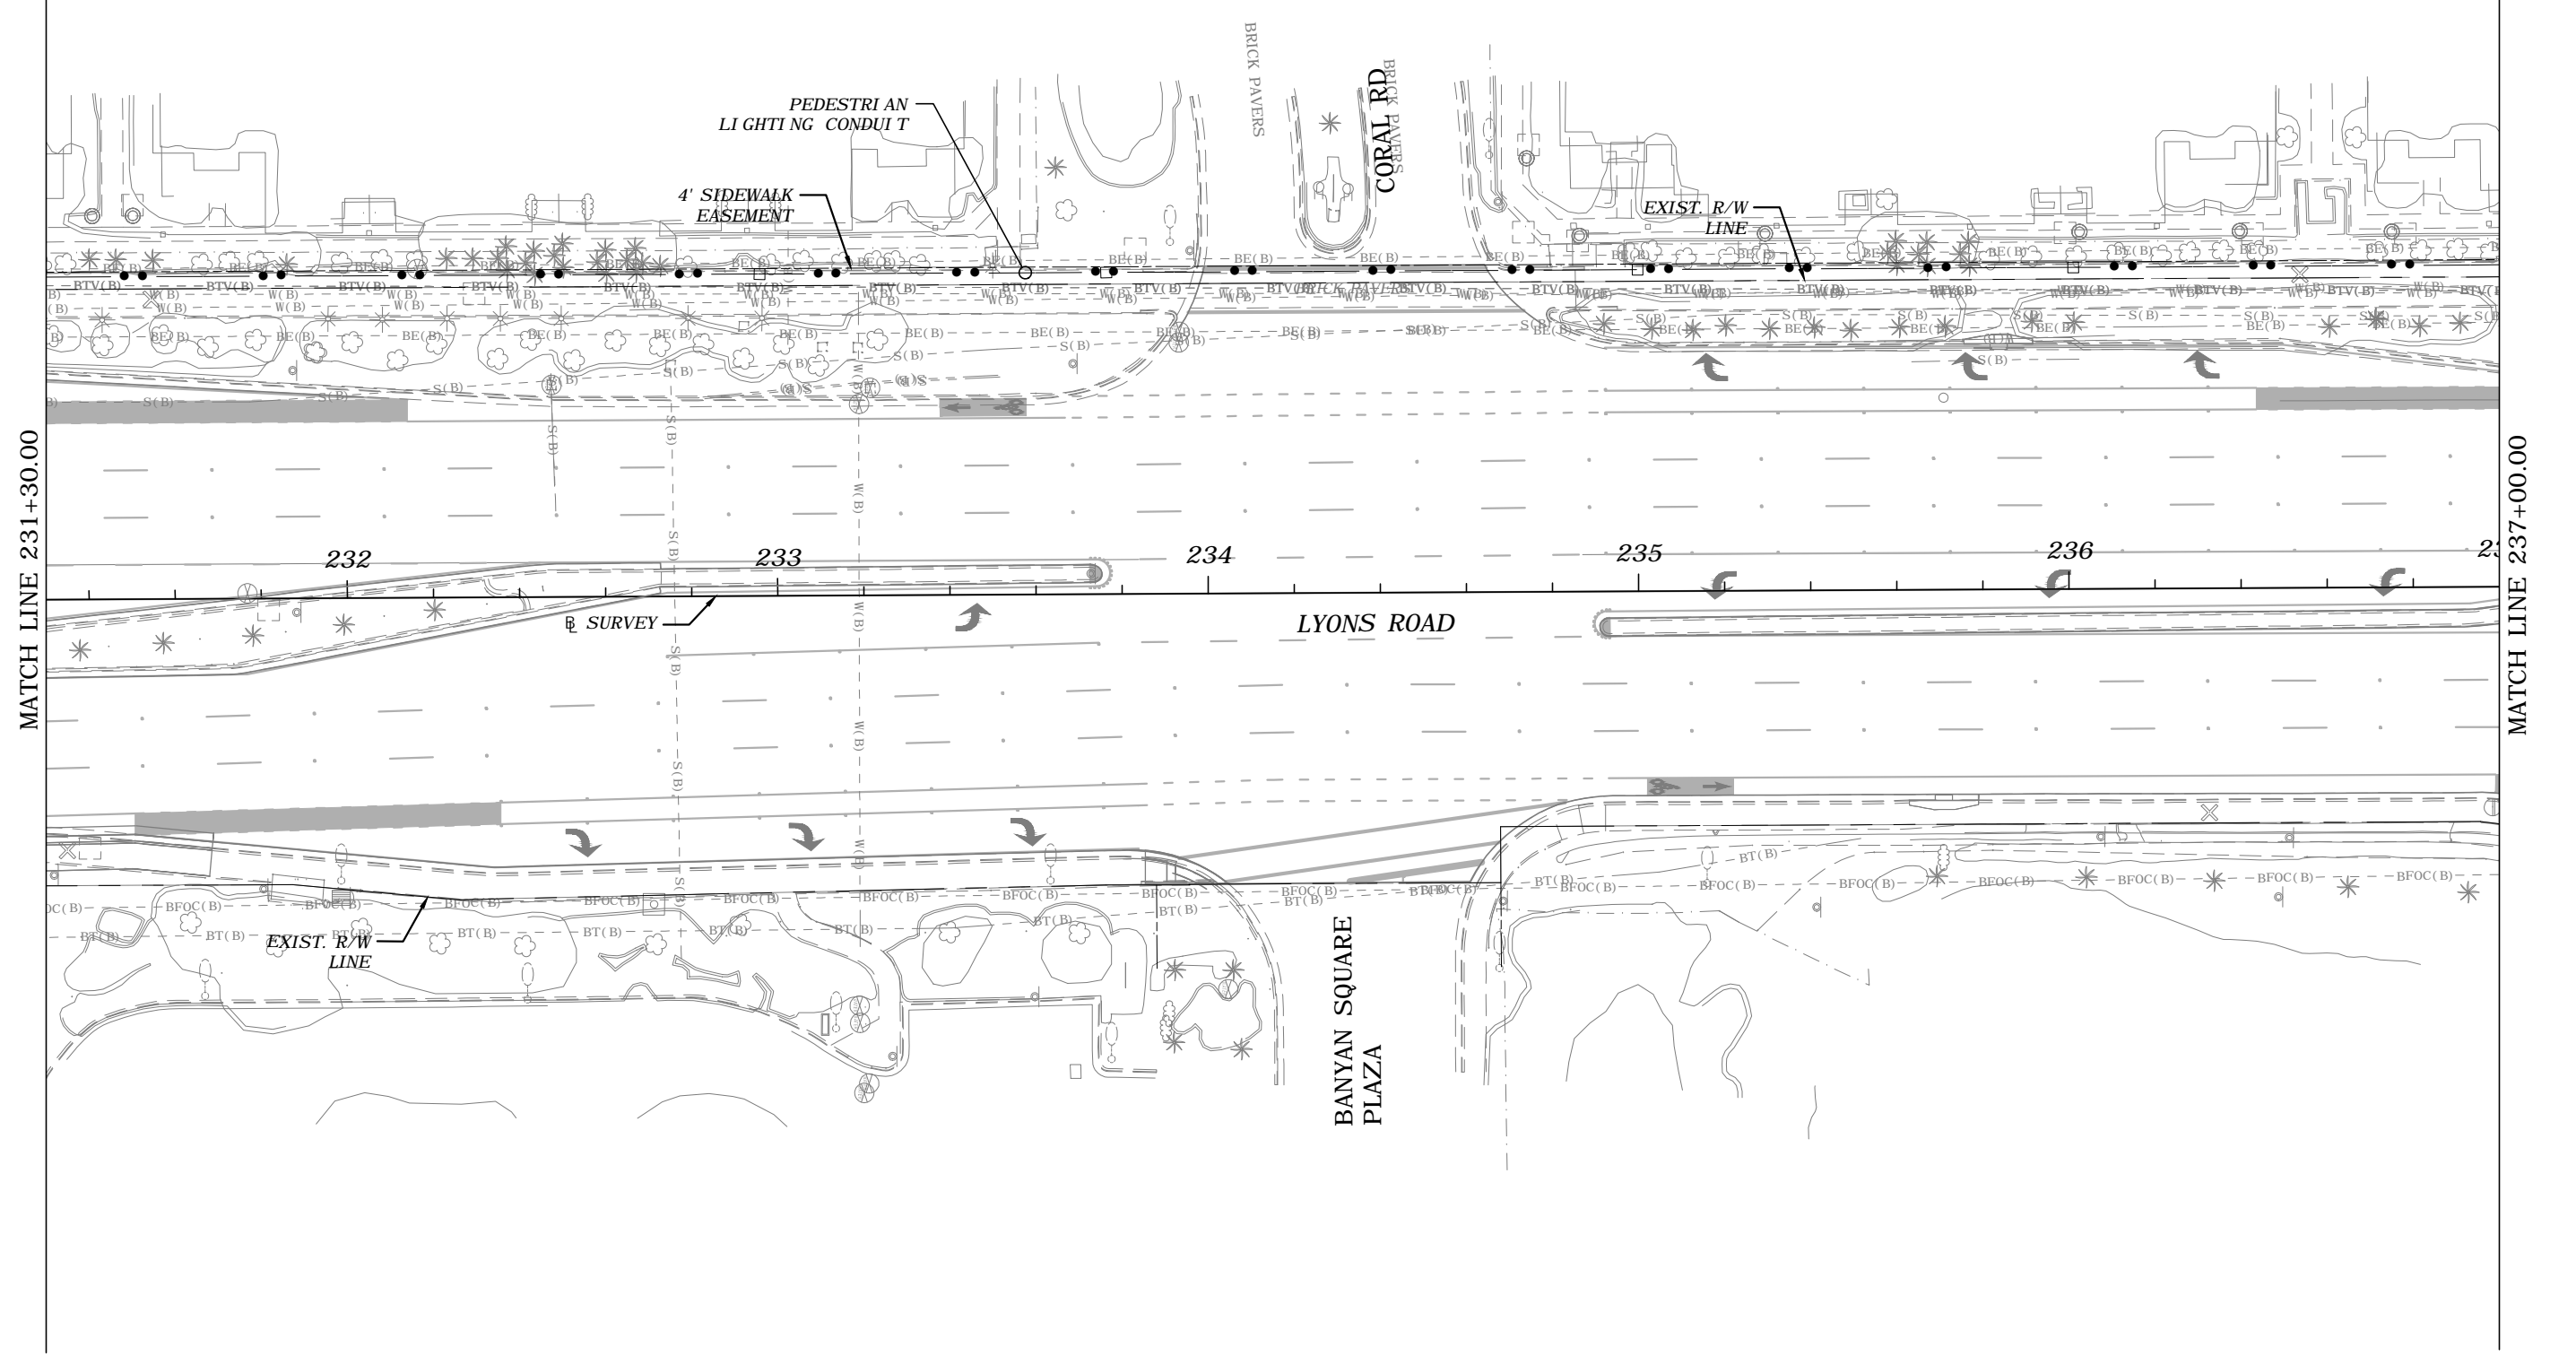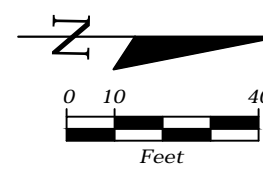

MATCH LINE 231+30.00

MATCH LINE 237+00.00

REVISIONS			
DATE	DESCRIPTION	DATE	DESCRIPTION
---	---	---	---



FREDDIE A. VARGAS, P.E.  
 P.E. LICENSE NUMBER 35941  
 CARNAHAN PROCTOR & CROSS, INC.  
 814 S. MILITARY TRAIL  
 DEERFIELD BEACH, FL 33442  
 CERTIFICATE OF AUTHORIZATION 2936

STATE OF FLORIDA DEPARTMENT OF TRANSPORTATION		
ROAD NO.	COUNTY	FINANCIAL PROJECT ID
	BROWARD	436319-1-52-03

*PEDESTRIAN LIGHTING-CONDUIT  
PLANS*

SHEET NO.  
L-43

THE OFFICIAL RECORD OF THIS SHEET IS THE ELECTRONIC FILE DIGITALLY SIGNED AND SEALED UNDER RULE 61G15-23.004, F.A.C.

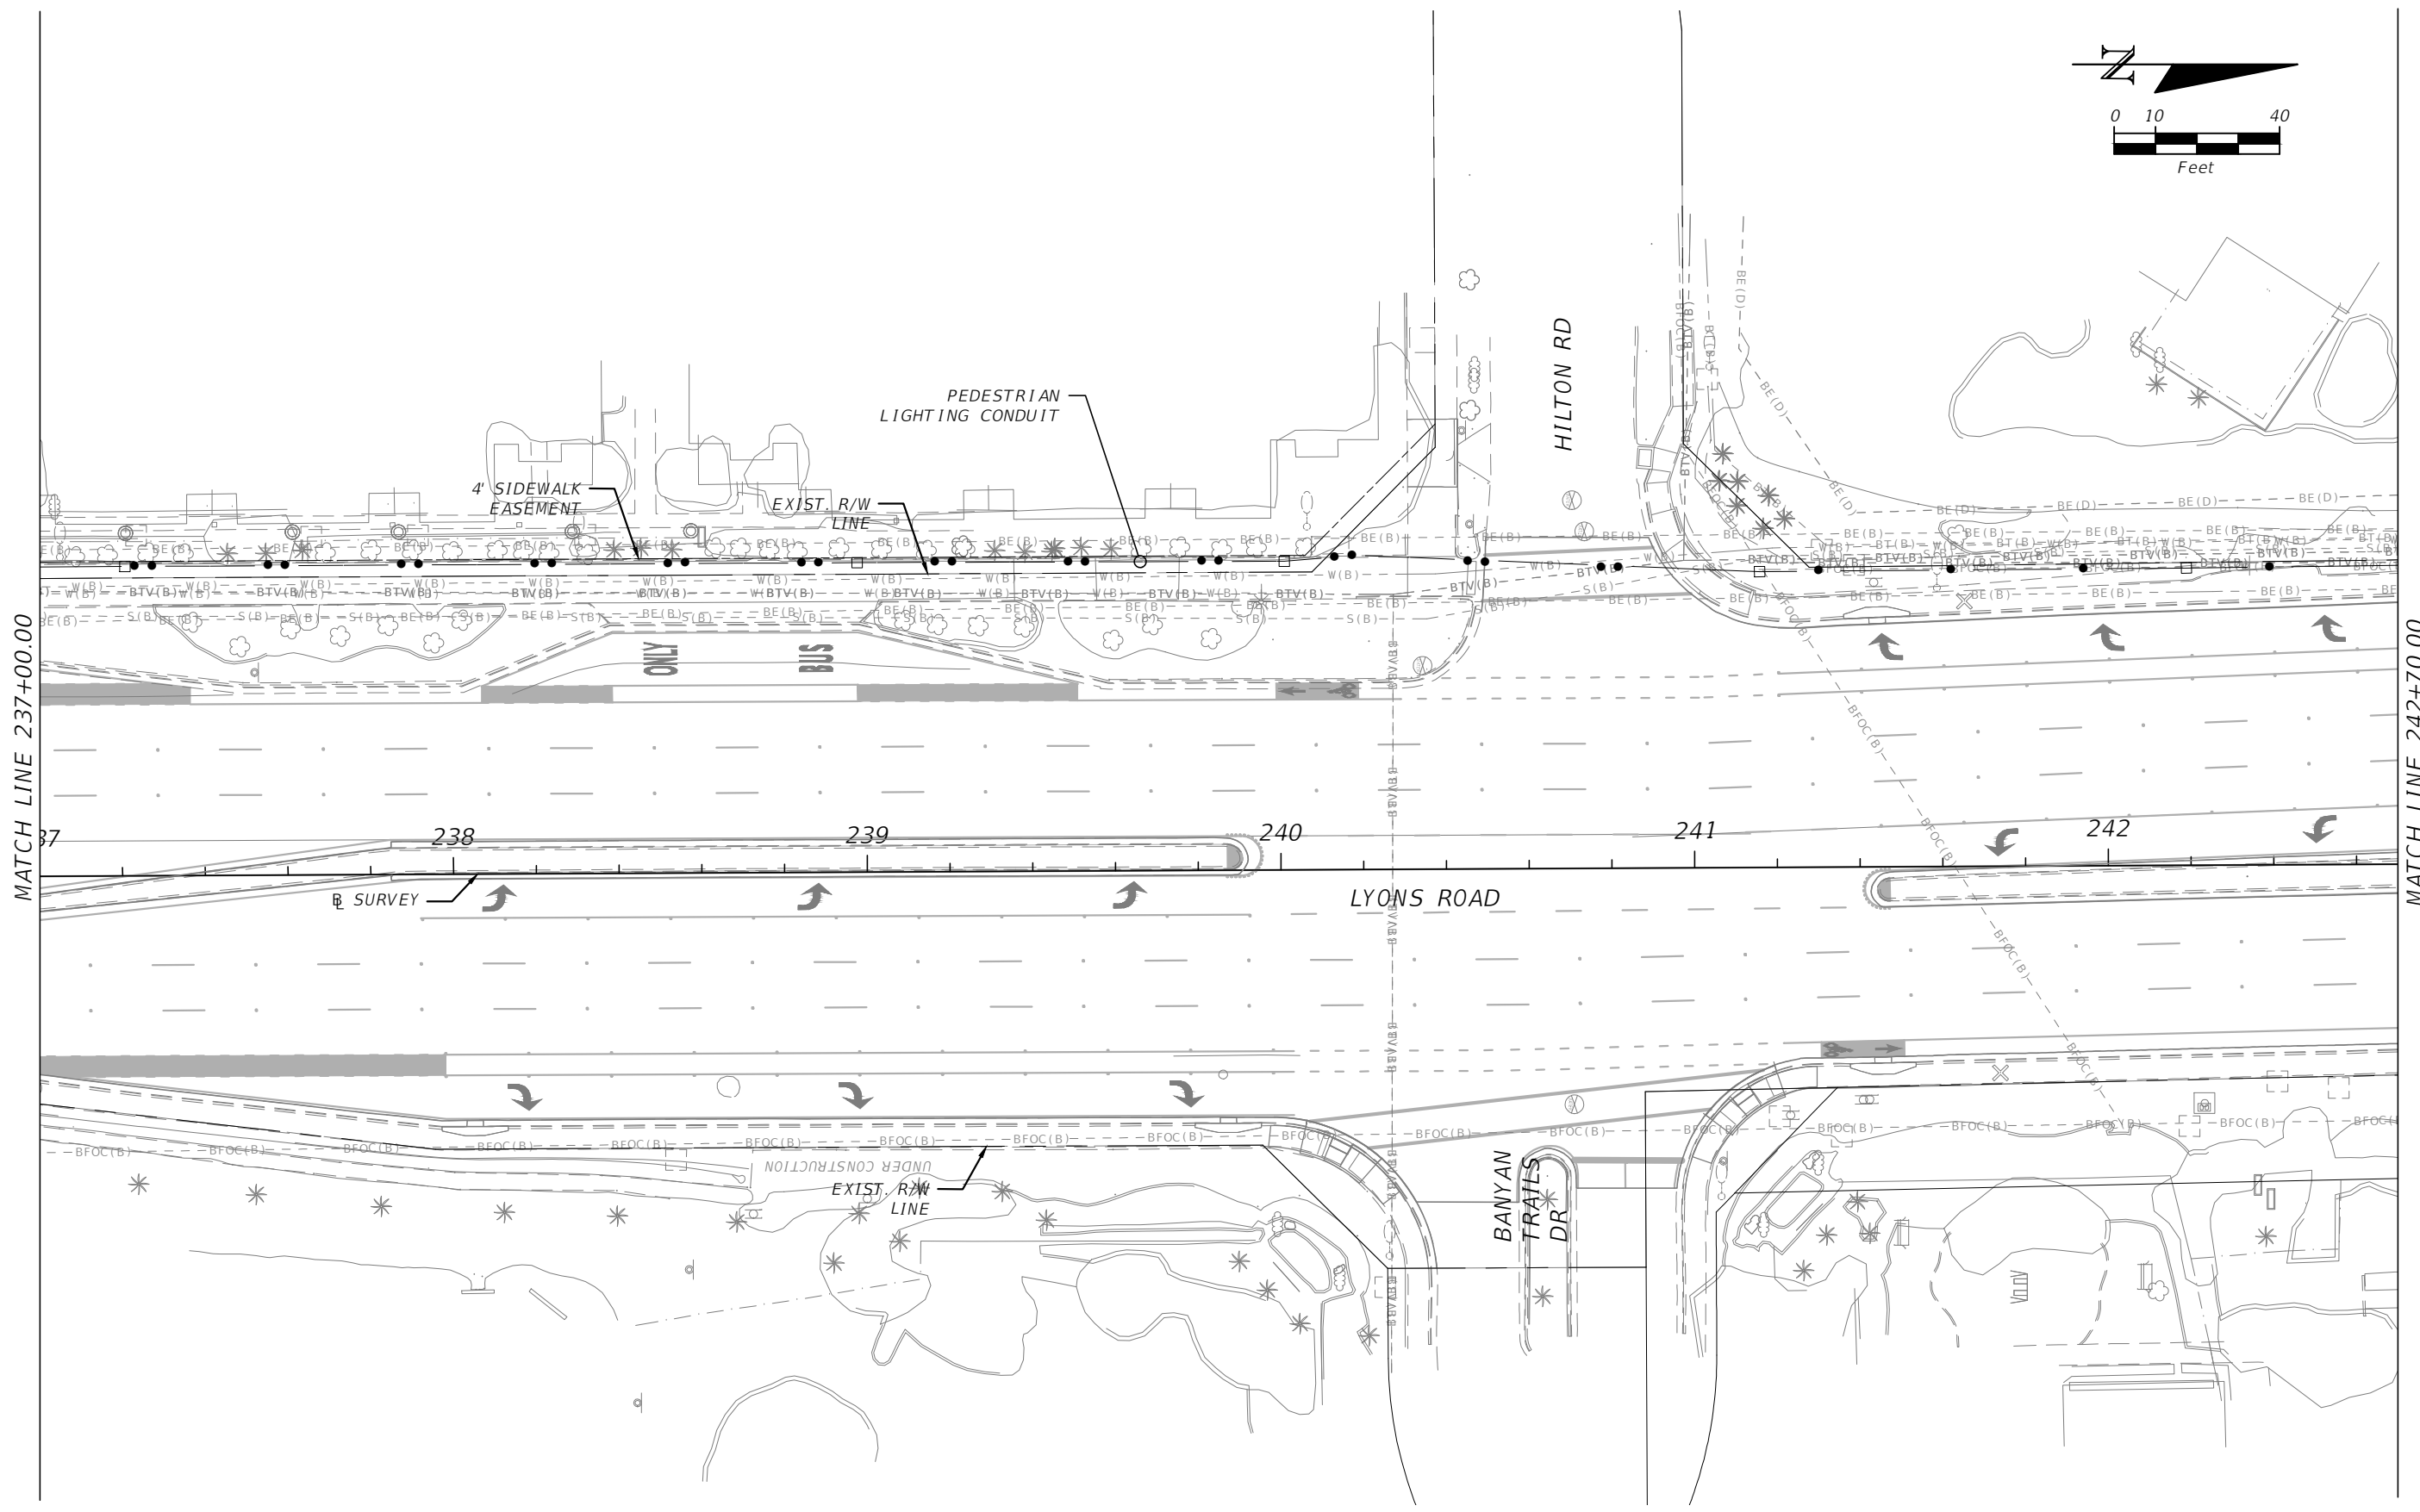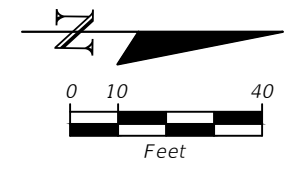

REVISIONS			
DATE	DESCRIPTION	DATE	DESCRIPTION



FREDDIE A. VARGAS, P.E.  
P.E. LICENSE NUMBER 35941  
CARNAHAN PROCTOR & CROSS, INC.  
814 S. MILITARY TRAIL  
DEERFIELD BEACH, FL 33442  
CERTIFICATE OF AUTHORIZATION 2936

STATE OF FLORIDA DEPARTMENT OF TRANSPORTATION		
ROAD NO.	COUNTY	FINANCIAL PROJECT ID
	BROWARD	436319-1-52-03

**PEDESTRIAN LIGHTING-CONDUIT  
PLANS**

SHEET NO.  
L-44



THE OFFICIAL RECORD OF THIS SHEET IS THE ELECTRONIC FILE DIGITALLY SIGNED AND SEALED UNDER RULE 61G15-23.004, F.A.C.

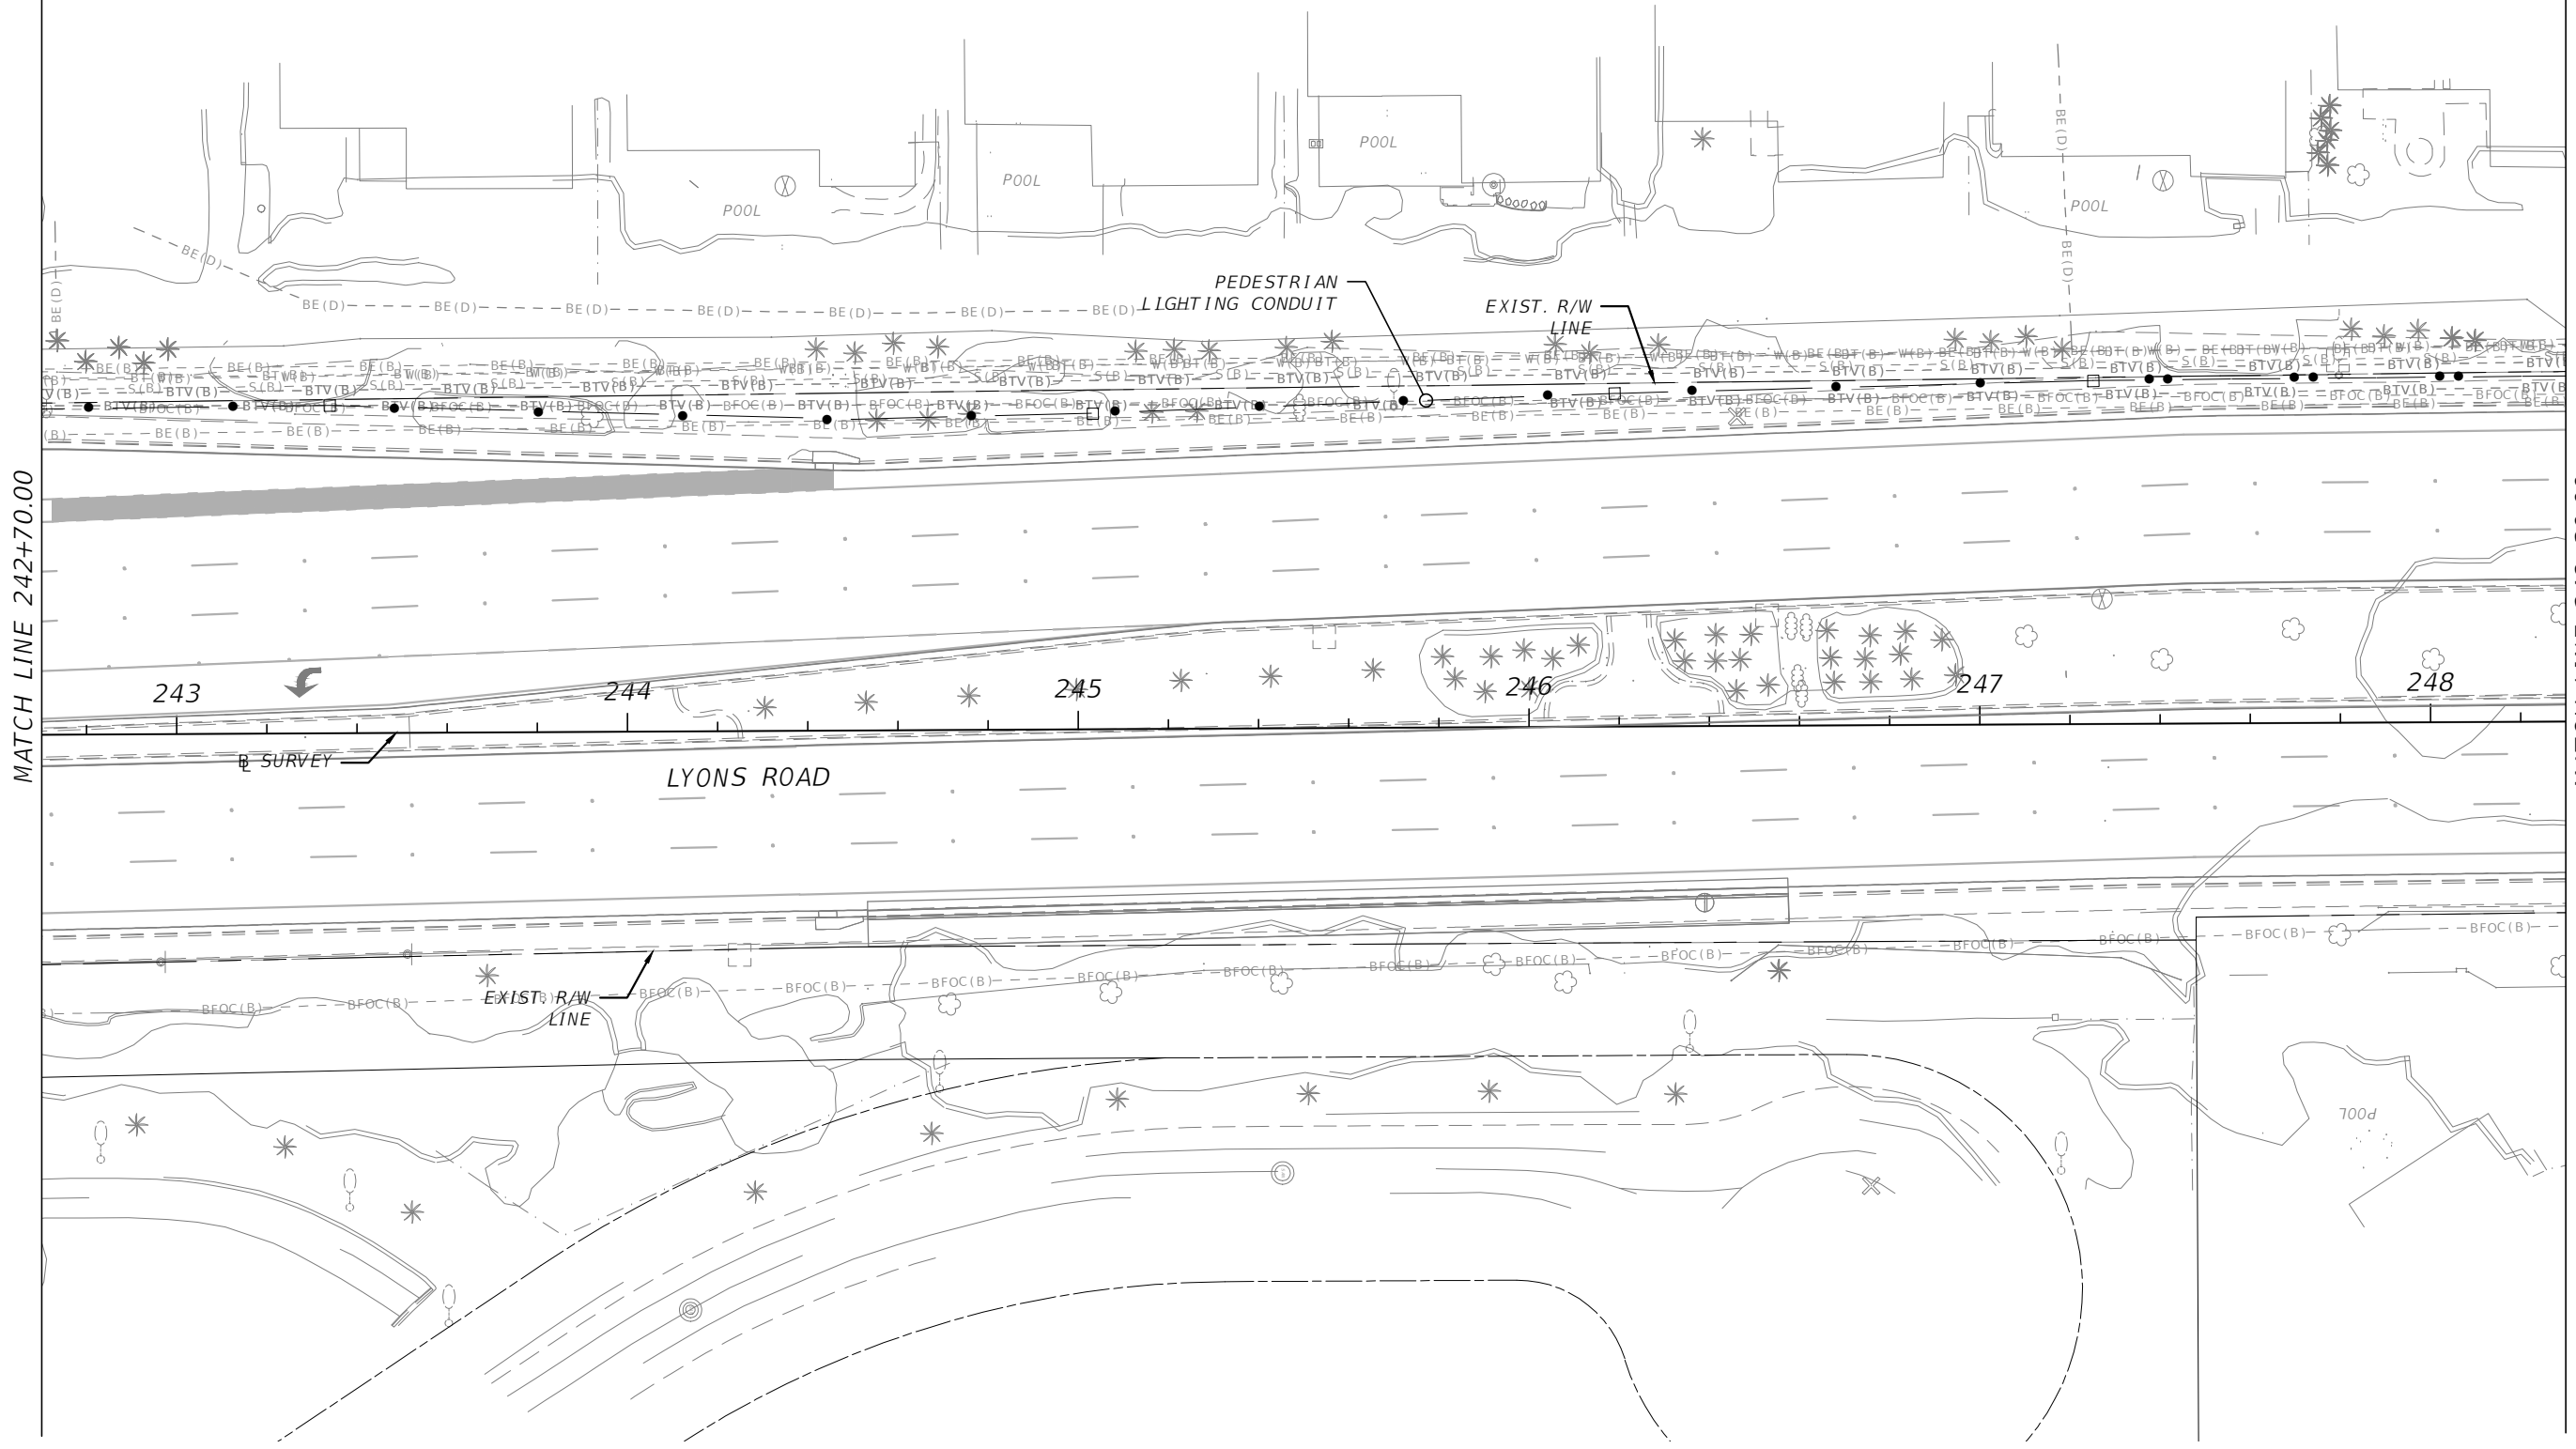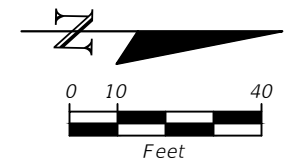

MATCH LINE 242+70.00



MATCH LINE 248+30.00

REVISIONS				FREDDIE A. VARGAS, P.E. P.E. LICENSE NUMBER 35941 CARNAHAN PROCTOR & CROSS, INC. 814 S. MILITARY TRAIL DEERFIELD BEACH, FL 33442 CERTIFICATE OF AUTHORIZATION 2936	STATE OF FLORIDA DEPARTMENT OF TRANSPORTATION		<i>PEDESTRIAN LIGHTING-CONDUIT PLANS</i>	SHEET NO. L-45
DATE	DESCRIPTION	DATE	DESCRIPTION		ROAD NO.	COUNTY		
---	---	---	---		BROWARD	436319-1-52-03		

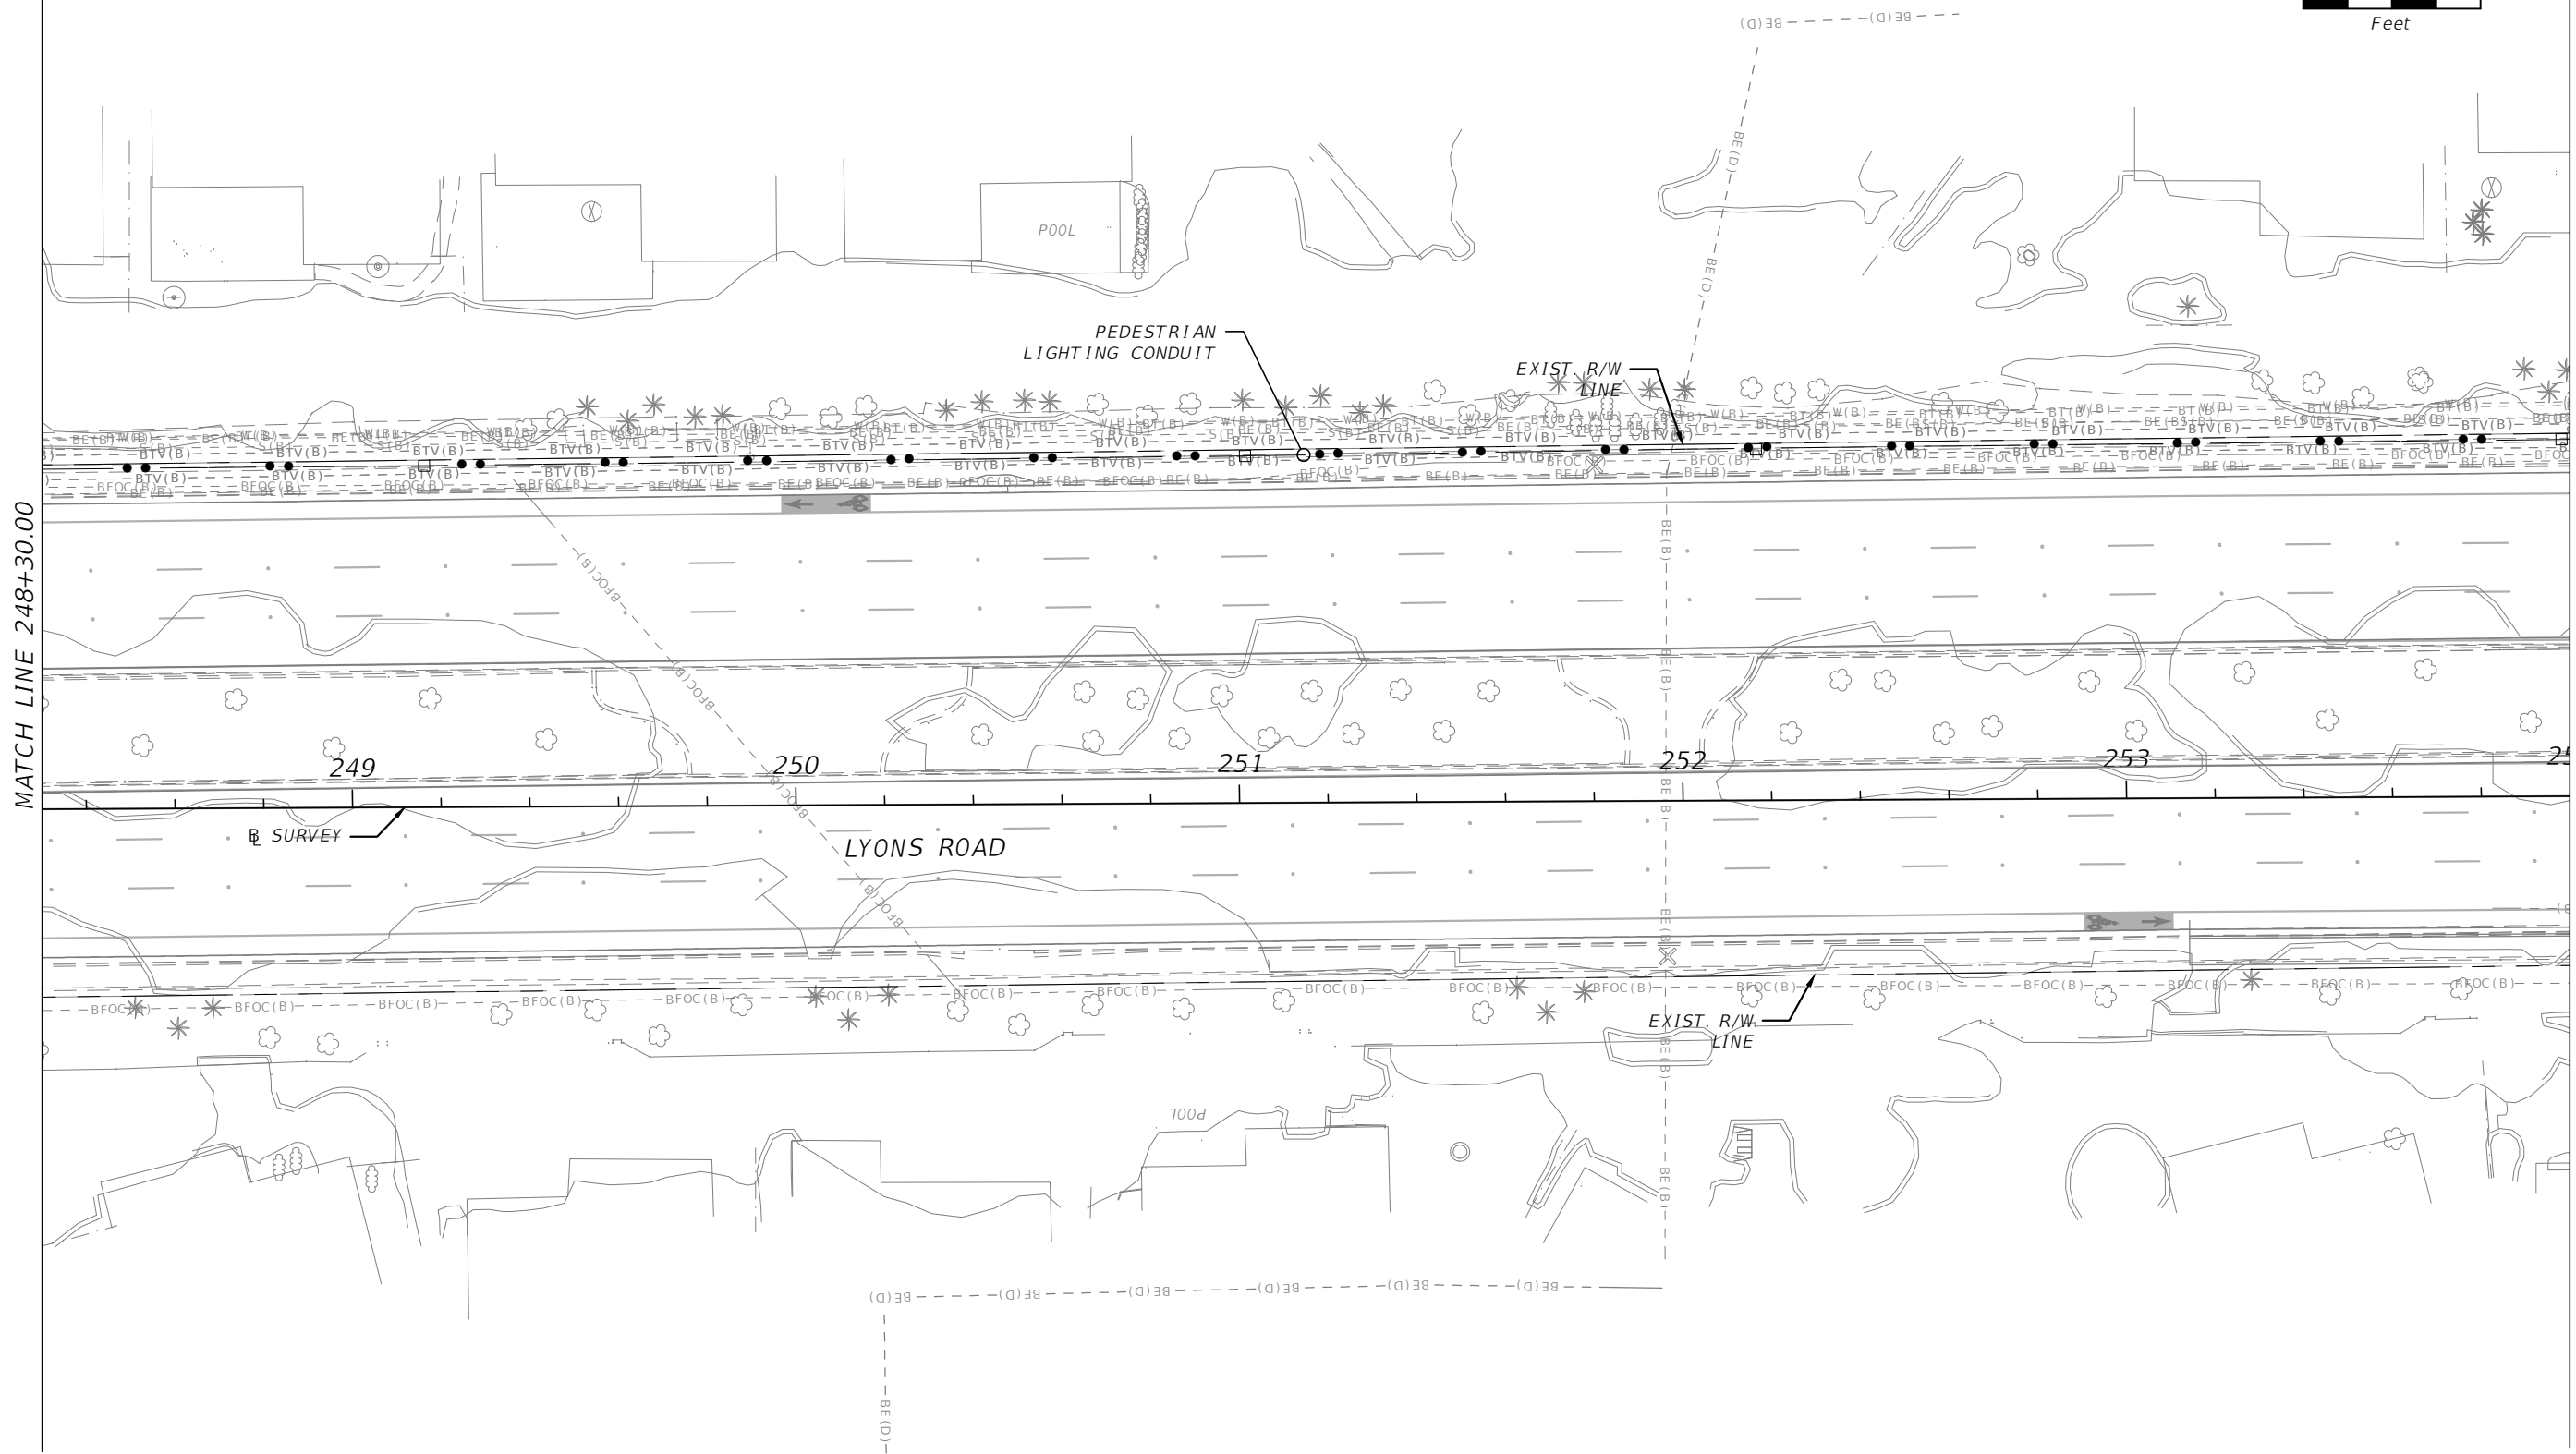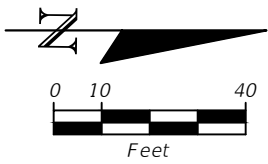

REVISIONS				FREDDIE A. VARGAS, P.E. P.E. LICENSE NUMBER 35941 CARNAHAN PROCTOR & CROSS, INC. 814 S. MILITARY TRAIL DEERFIELD BEACH, FL 33442 CERTIFICATE OF AUTHORIZATION 2936	STATE OF FLORIDA DEPARTMENT OF TRANSPORTATION		<i>PEDESTRIAN LIGHTING-CONDUIT PLANS</i>	SHEET NO. L-46
DATE	DESCRIPTION	DATE	DESCRIPTION		ROAD NO.	COUNTY		
---	---	---	---		BROWARD	436319-1-52-03		



THE OFFICIAL RECORD OF THIS SHEET IS THE ELECTRONIC FILE DIGITALLY SIGNED AND SEALED UNDER RULE 61G15-23.004, F.A.C.

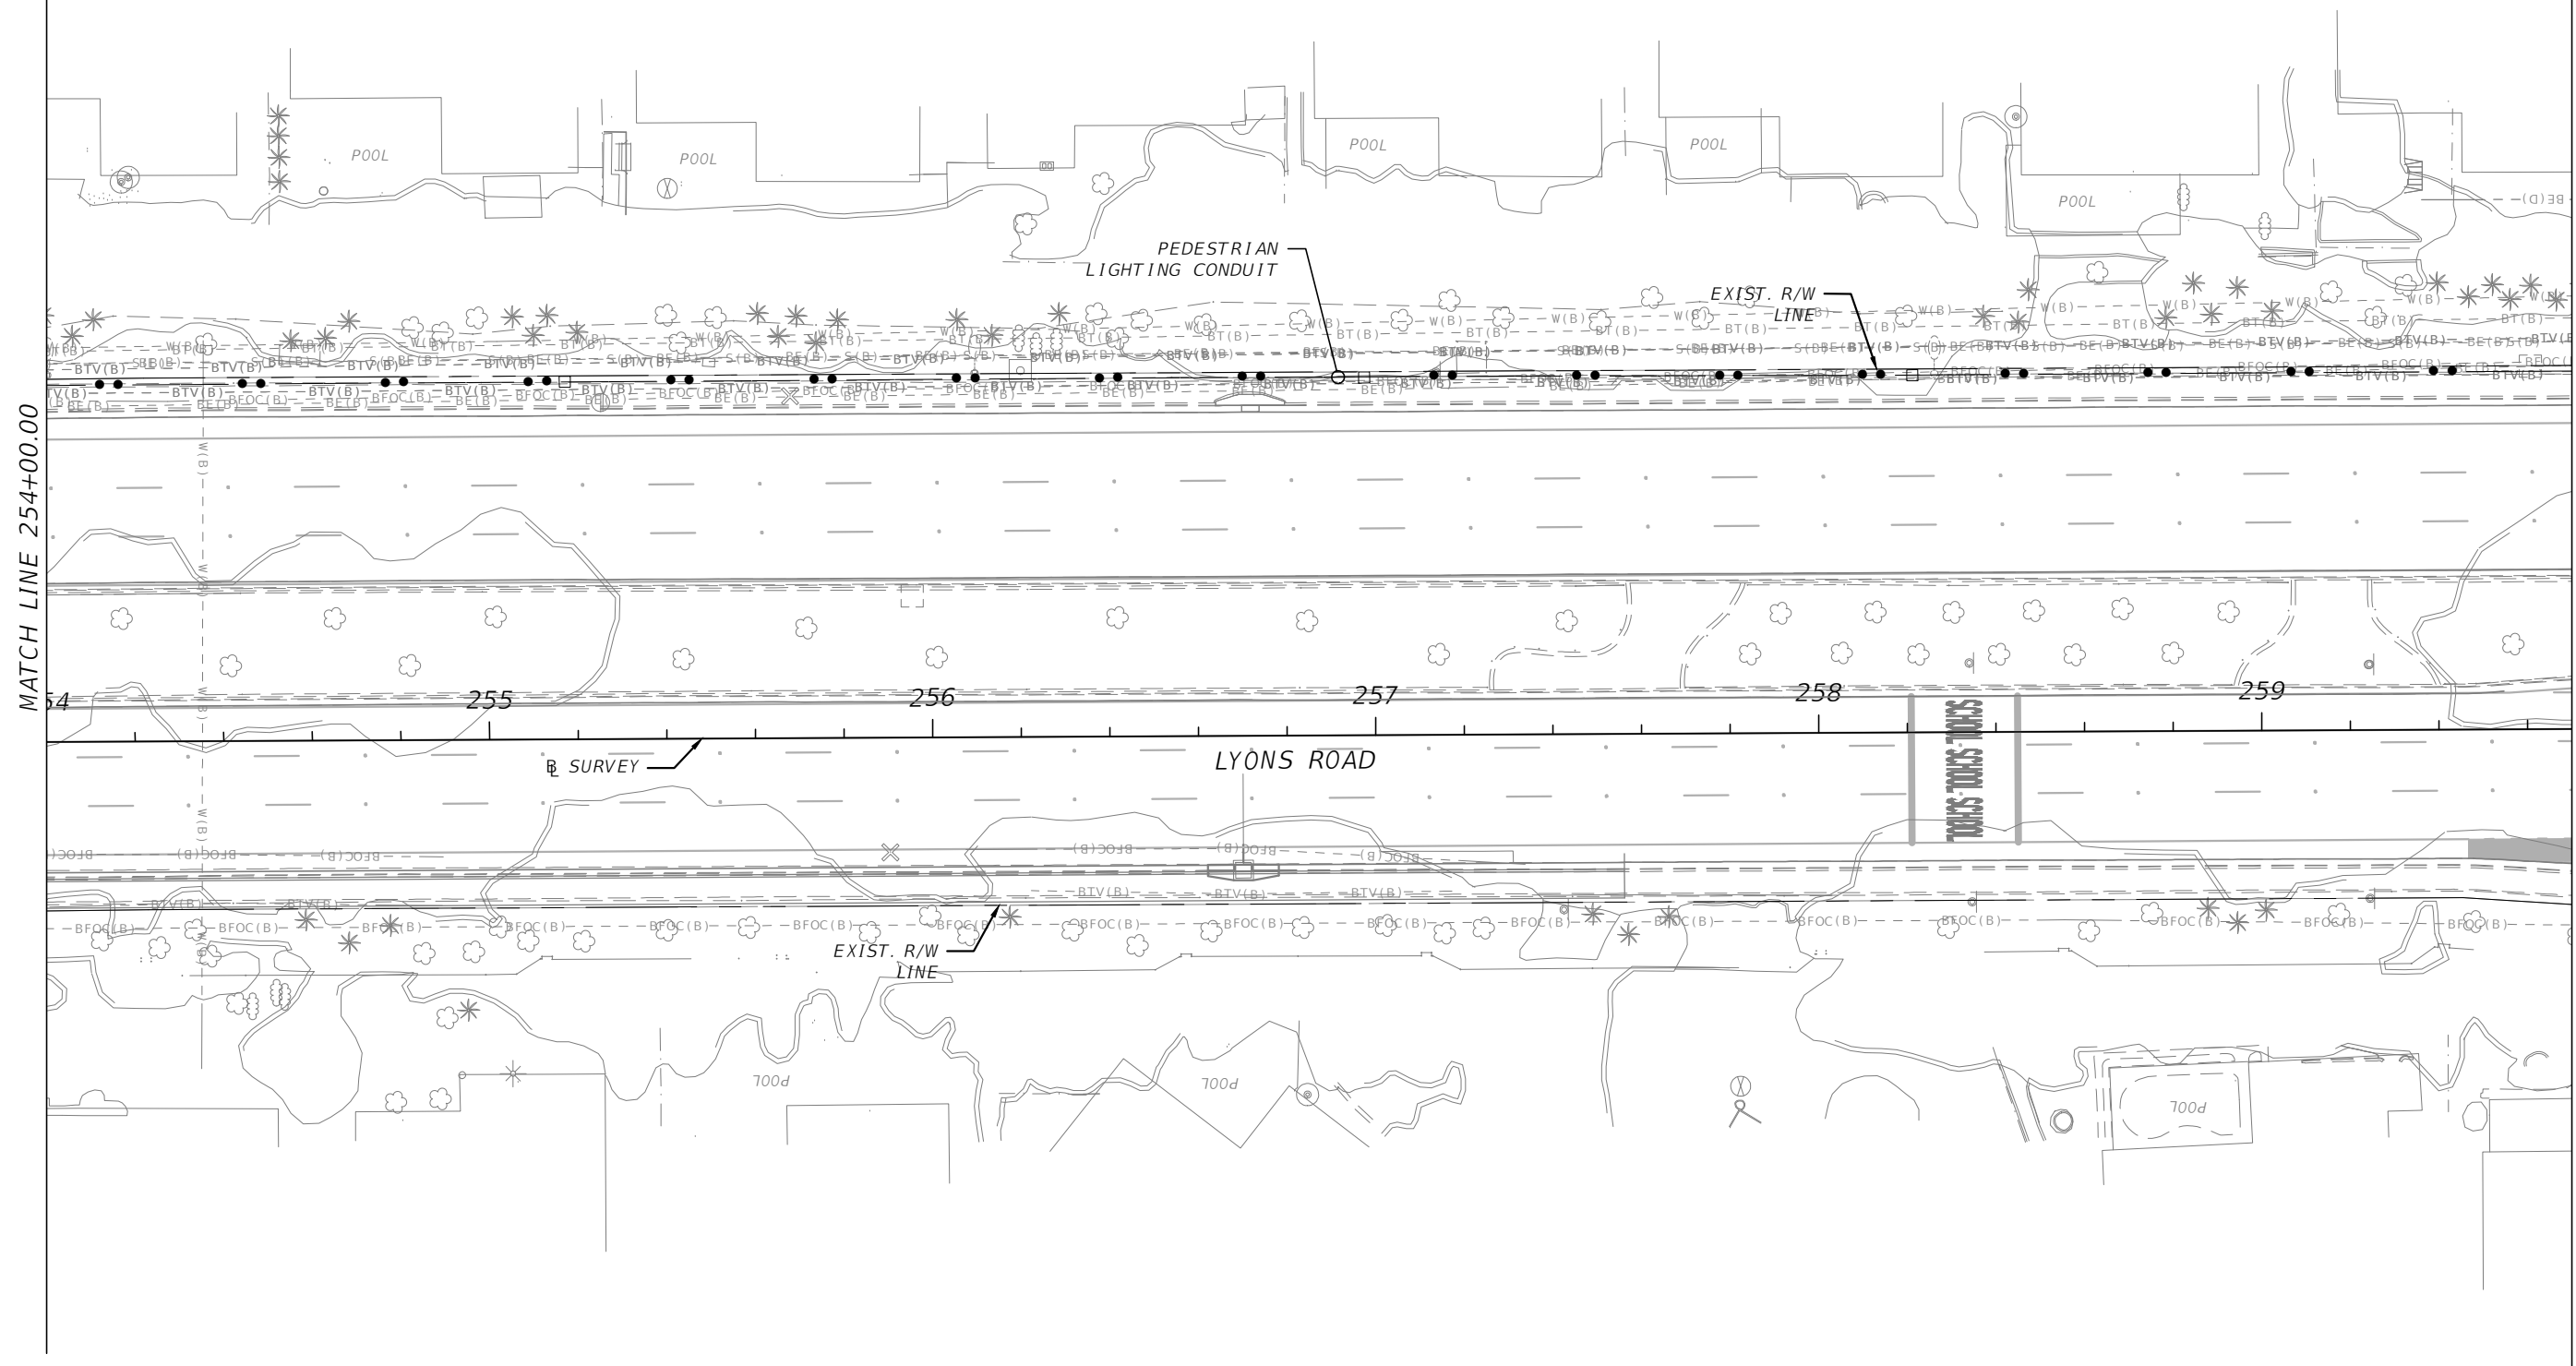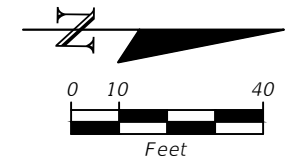

MATCH LINE 254+00.00

MATCH LINE 259+70.00

REVISIONS				FREDDIE A. VARGAS, P.E. P.E. LICENSE NUMBER 35941 CARNAHAN PROCTOR & CROSS, INC. 814 S. MILITARY TRAIL DEERFIELD BEACH, FL 33442 CERTIFICATE OF AUTHORIZATION 2936	STATE OF FLORIDA DEPARTMENT OF TRANSPORTATION		<i>PEDESTRIAN LIGHTING-CONDUIT PLANS</i>	SHEET NO.
DATE	DESCRIPTION	DATE	DESCRIPTION		ROAD NO.	COUNTY		FINANCIAL PROJECT ID
---	---	---	---		BROWARD	436319-1-52-03		

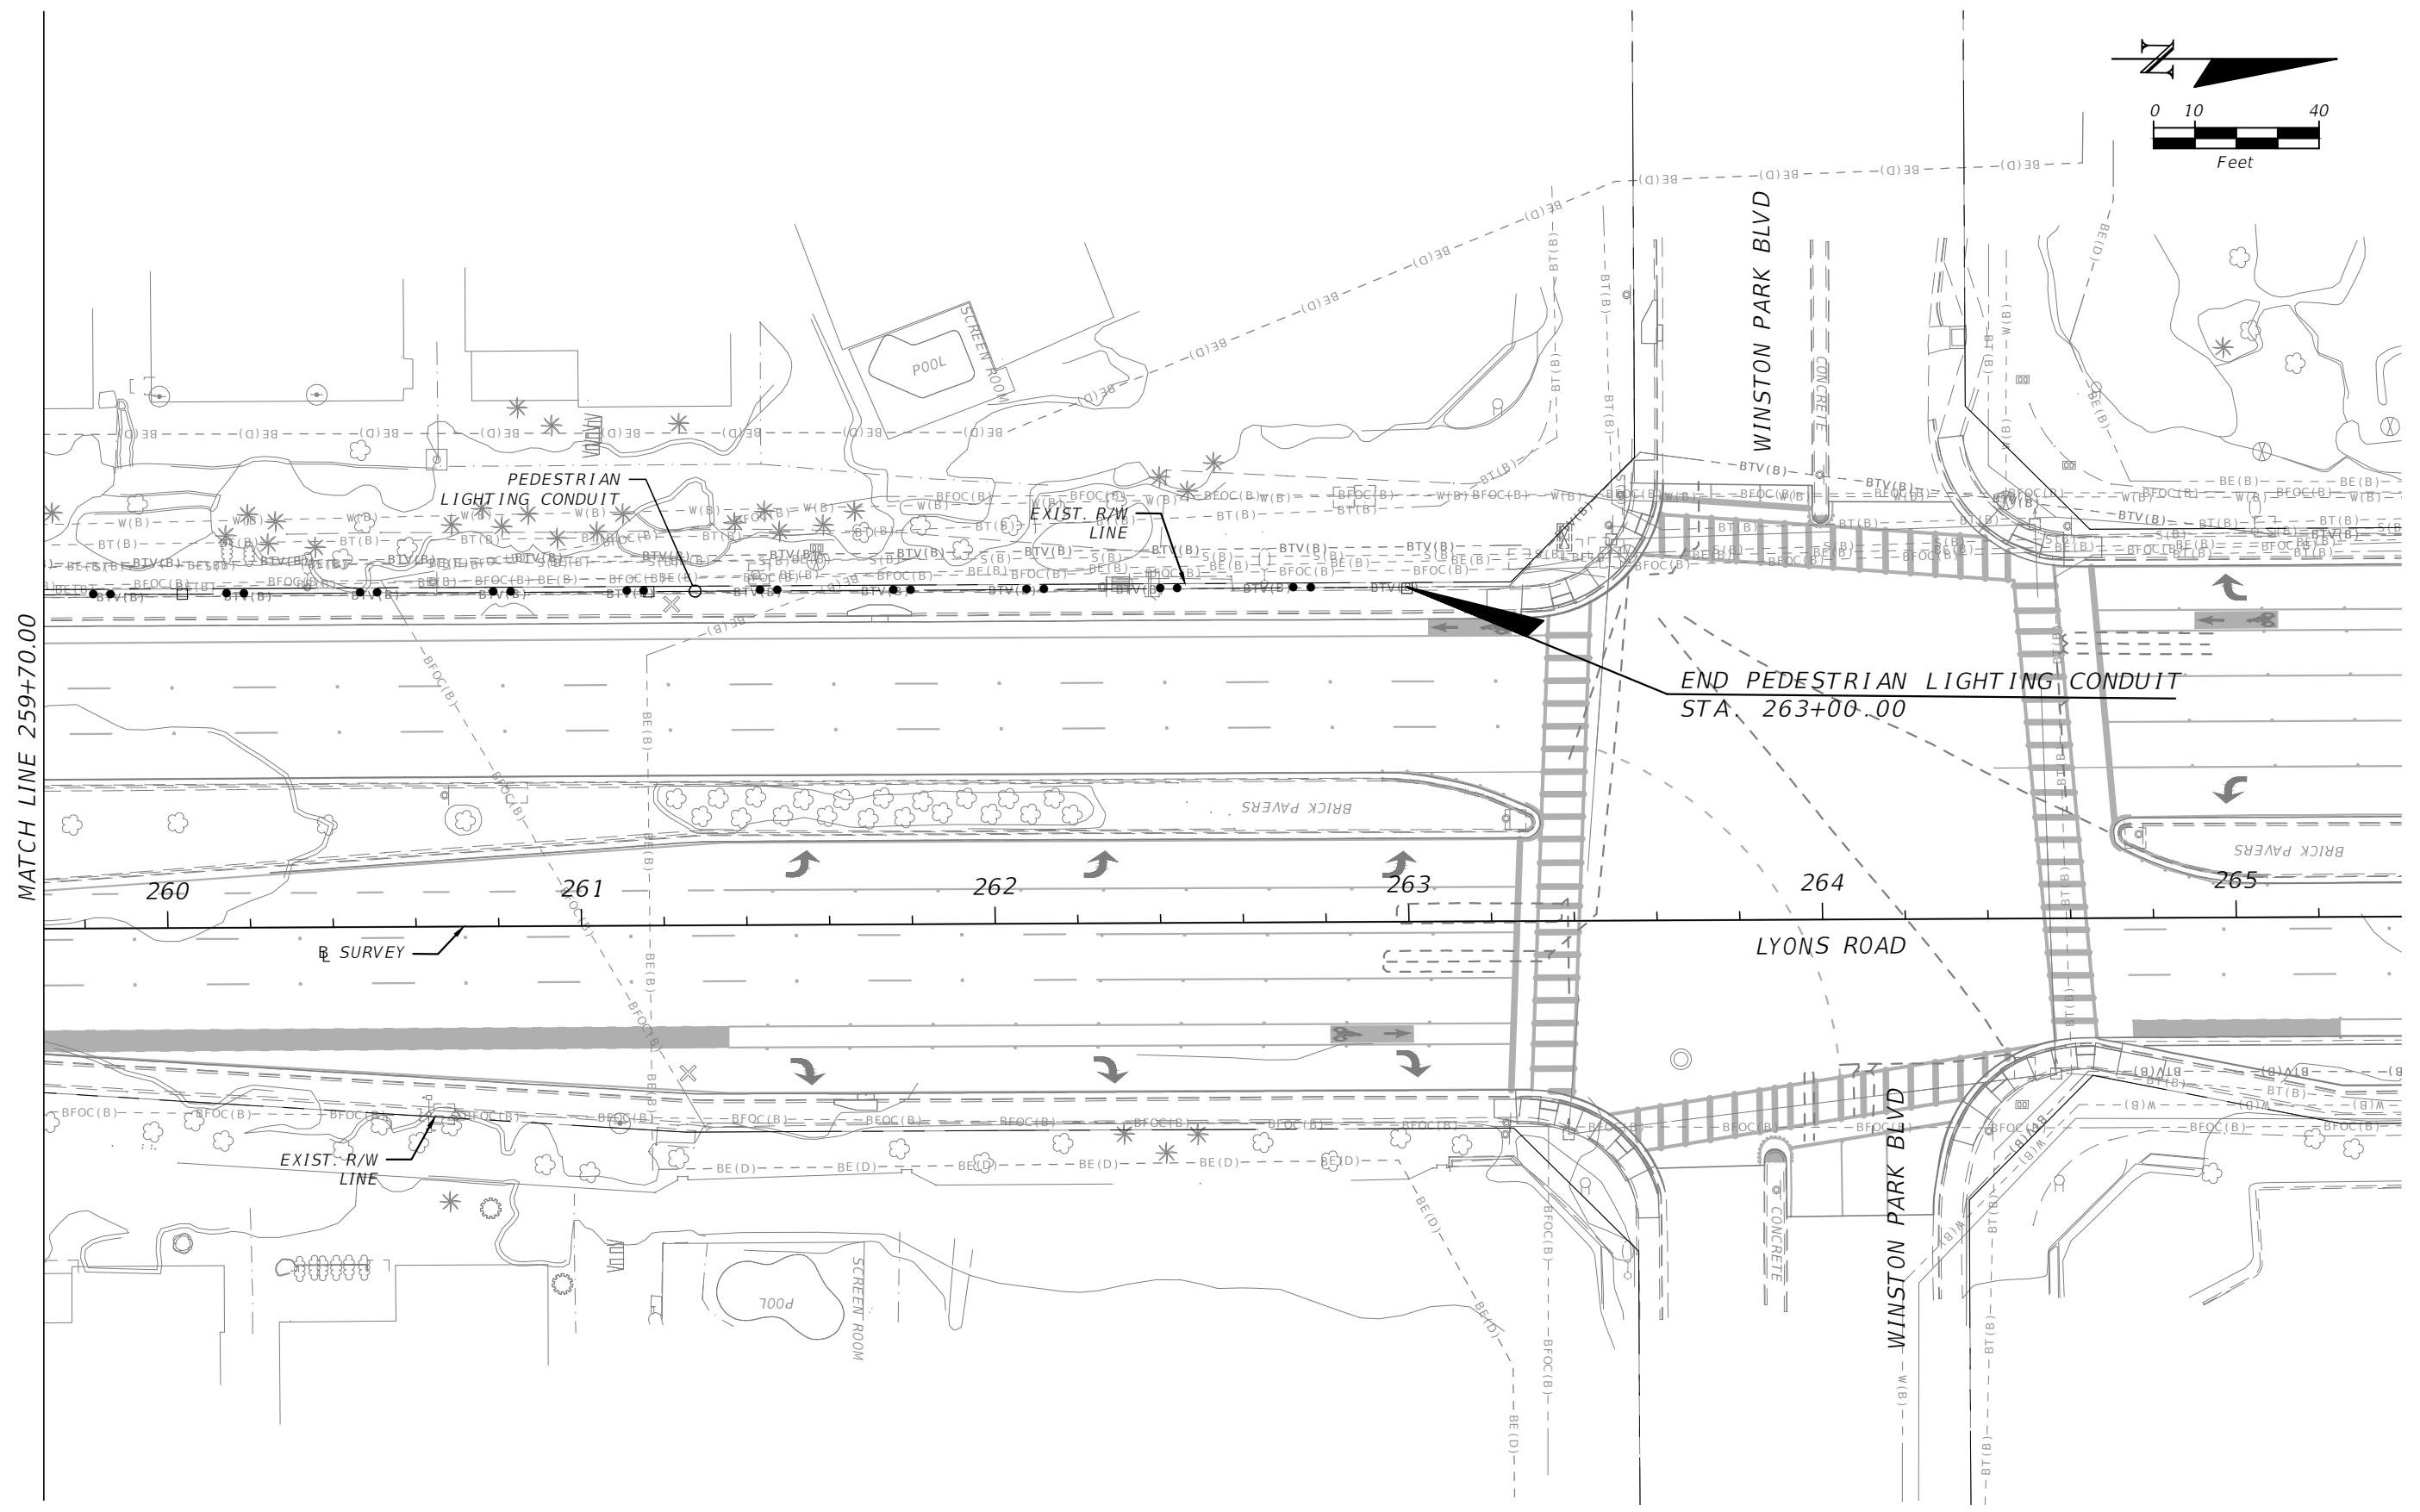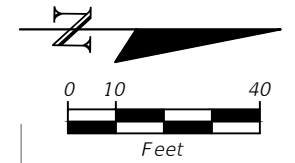

MATCH LINE 259+70.00

END PEDESTRIAN LIGHTING CONDUIT  
STA. 263+00.00

REVISIONS				FREDDIE A. VARGAS, P.E. P.E. LICENSE NUMBER 35941 CARNAHAN PROCTOR & CROSS, INC. 814 S. MILITARY TRAIL DEERFIELD BEACH, FL 33442 CERTIFICATE OF AUTHORIZATION 2936	STATE OF FLORIDA DEPARTMENT OF TRANSPORTATION		<i>PEDESTRIAN LIGHTING-CONDUIT PLANS</i>	SHEET NO.  L-48
DATE	DESCRIPTION	DATE	DESCRIPTION		ROAD NO.	COUNTY		
---	---	---	---		BROWARD	436319-1-52-03		