


EXHIBIT "B"

DATE: Jul 18, 2024 - 4:50pm Z:\Projects\2018\180332-Johns_Farm\Drawings\Construction\Plans\PODS\BLOCK 9\180332-BLOCK 9-SP001.dwg

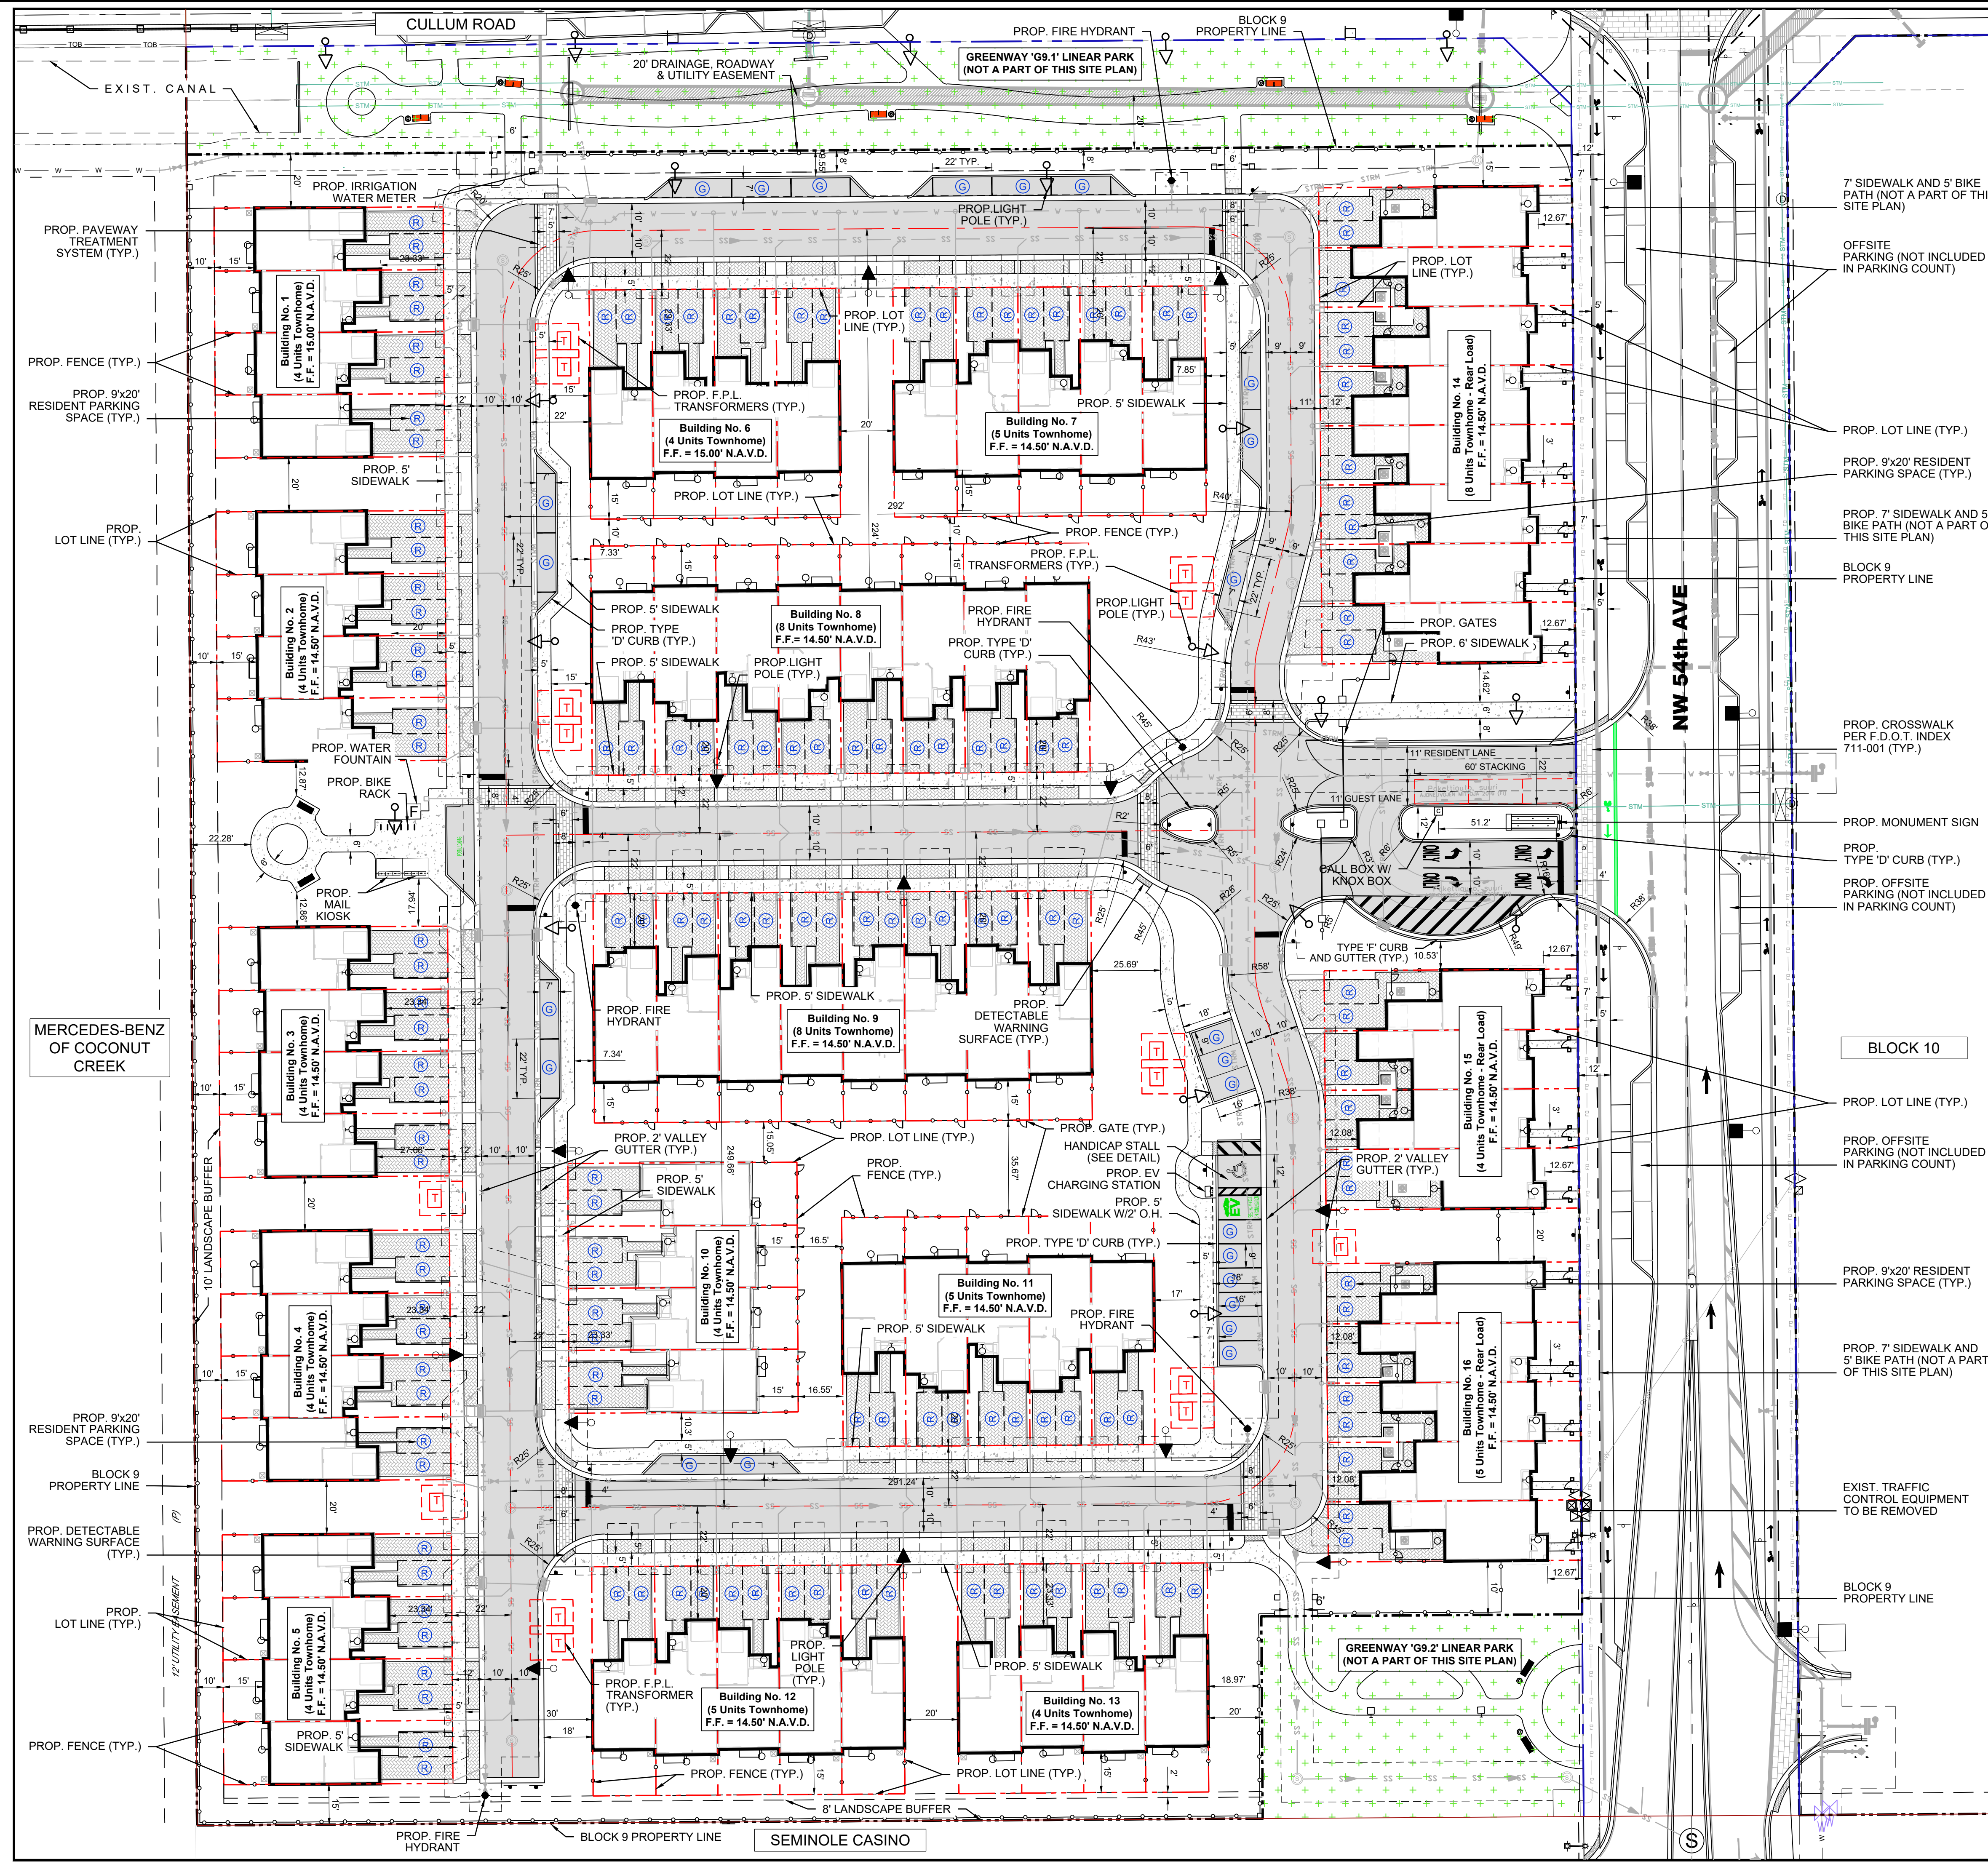

LEGEND

- PROPOSED ADA STALL
- PROPOSED CONCRETE SIDEWALK
- ASPHALT PAVEMENT
- 10'x10' SIGHT TRIANGLE
- FLOW DIRECTION
- PROPOSED GRADE
- EXISTING GRADE
- SEWER / DRAINAGE MANHOLE
- DRAINAGE INLET
- YARD DRAIN BASIN
- SINGLE SEWER SERVICE
- DOUBLE SEWER SERVICE
- C.A.P. CORRUGATED ALUMINUM PIPE
- W.M. WATER MAIN
- G.V. GATE VALVE
- F.H. FIRE HYDRANT
- R.E. RIM ELEVATION
- I.E. INVERT ELEVATION
- E.O.P. EDGE OF PAVEMENT
- P.R.B. POLLUTION RETARDANT BAFFLE
- R.C.P. REINFORCED CONCRETE PIPE
- H.D.P.E. HIGH DENSITY POLYETHYLENE PIPE
- D.W.E. DESIGN WATER ELEVATION
- DRAINAGE STRUCTURE NUMBER
- FIRE HYDRANT ASSEMBLY
- TAPPING SLEEVE & VALVE
- DOUBLE WATER METER
- SINGLE WATER METER
- GATE VALVE
- EXISTING VALVE
- BACTERIOLOGICAL SAMPLING POINT

HSQ GROUP, LLC
 Engineers - Planners - Surveyors
 1001 Yamalo Road, Suite 105
 Boca Raton, Florida 33431 - 561.392.0221
 C26256 - LB7924

**MAINSTREET AT COCONUT CREEK
 BLOCK 9
 SITE PLAN**

DATE: 01/24
 DESIGNED BY: JH
 DRAWN BY: HG
 CHECKED BY: JH

JAY HUEBNER
 LICENSE
 No. 54615
 STATE OF FLORIDA
 PROFESSIONAL ENGINEER

DATE: Jul 18, 2024
 JAY HUEBNER, P.E.
 FLORIDA REGISTRATION NO. - 54615
 PROJECT: 1803-32
 SHEET: SP-1

Call 811 or www.sunshine811.com two full business days before digging to have utilities located and marked.
 Check positive response codes before you dig!